



UNFPA OFFICE INDONESIA

WORKING DRAWING

1908 - REV E

INTERIOR DRAWING LIST UNFPA OFFICE INDONESIA

NOTE :

Number	DRAWING NUMBER	REV	DRAWING TITTLE	SCALE
1	INT - 000		DRAWING LIST	NTS
GENERAL				
2	INT - 101		LAYOUT PLAN	1 : 150
3	INT - 102		FLOOR FINISH PLAN	1 : 150
4	INT - 103		PARTITION PLAN	1 : 150
5	INT - 104		WALL FINISH PLAN	1 : 150
6	INT - 105		CEILING PLAN	1 : 150
7	INT - 106		DOOR PLAN	1 : 150
8	INT - 107		FURNITURE PLAN	1 : 150
9	INT - 108		LIGHTING PLAN	1 : 150
10	INT - 109		LAN & POWER OUTLET PLAN	1 : 150
11	INT - 110		SECTION PLAN	1 : 150
SECTION				
12	INT - 201		SECTION A, SECTION B & SECTION C	1 : 75
13	INT - 202		SECTION D & SECTION E	1 : 75
14	INT - 203		SECTION F & SECTION G	1 : 75
15	INT - 204		SECTION H, SECTION I & SECTION J	1 : 75
16	INT - 205		SECTION K, SECTION L, SECTION M, SECTION N & SECTION O	1 : 75
17	INT - 206		THE PERSPECTIVE	NTS
DETAIL PARTITION				
18	INT - 301		DETAIL PARTITION WG1, WG2 & WG3	1 : 5
19	INT - 302		DETAIL PARTITION WG4, WG5 & WG6	1 : 5
20	INT - 303		DETAIL PARTITION WT1, WT2, WT3, WT4 & WT5	1 : 5
21	INT - 304		KEYPLAN FEATURE WALL	1 : 150
22	INT - 305		DETAIL WALL FINISH 1	1 : 60
23	INT - 306		DETAIL WALL FINISH 2	1 : 20
24	INT - 307		DETAIL WALL FINISH 2A	1 : 30
25	INT - 308		DETAIL WALL FINISH 2B	1 : 30
26	INT - 309		DETAIL WALL FINISH 3	1 : 30
27	INT - 310		DETAIL WALL FINISH 4	1 : 20
28	INT - 311		DETAIL WALL FINISH 5	1 : 30
29	INT - 312		DETAIL WALL FINISH 6	1 : 30
30	INT - 313		DETAIL WALL FINISH 7	1 : 30
DOOR DETAIL				
31	INT - 401		DOOR DETAIL D.02, D.03A & D.03B	1 : 25
32	INT - 402		DOOR DETAIL D.04A, D.04B, D.04C & D.05	1 : 25
33	INT - 403		DOOR DETAIL D.06, D.07, D.08 & D.09	1 : 25
FURNITURE				
34	INT - 501		DETAIL CF-01 (ENTRANCE WALL)	1 : 25
35	INT - 502		DETAIL CF-02 (SHOWCASE PRODUCTS)	1 : 25
36	INT - 503		DETAIL CF-03 (WORKSPACE CABINET)	1 : 25
37	INT - 504		DETAIL CF-04 (CABINET MEETING ROOM)	1 : 25
38	INT - 505		DETAIL CF-05 (CREDENZA)	1 : 10
39	INT - 506		DETAIL CF-06 (QUIET ROOM)	1 : 25
40	INT - 508		DETAIL CF-08 (AMPHITHEATRE AT PANTRY)	1 : 50
41	INT - 509		DETAIL CF-09 (PANTRY)	1 : 20
42	INT - 510		DETAIL CF-10 (CABINET & DISCUSS SPACE)	1 : 50
43	INT - 512		DETAIL CF-12 (CABINET WORKSTATION)	1 : 20
44	INT - 513		DETAIL CF-13 (OPERATIONS ROOM)	1 : 20
45	INT - 514		DETAIL CF-14 (OPERATIONS ROOM)	1 : 20
46	INT - 516		DETAIL CF-16 (OPERATIONS ROOM)	1 : 20

WORKSTATION FURNITURE			
47	INT-517	DETAIL TB-17 (WORKSTATION)	1 : 20
48	INT-518	DETAIL TB-8 (WORKSTATION)	1 : 20
49	INT-519	DETAIL TB-01, TB-02, TB-03 (MEETING TABLE)	1 : 20
50	INT-520	DETAIL TB-04, TB-05 (EXECUTIVE WORKSTATION)	1 : 20
51	INT-521	DETAIL TB-06, TB-07, TB-09, TB-10 (TABLE)	1 : 20


 Bintaro Business Centre Building
 Jl. RC Veteran No. 14 Bintaro
 Phone: +62 21 7357679
 Fax: +62 21 7433946
 www.dezanstudio.com
 admin@dezanstudio.com

CLIENT

UNFPA

PROJECT

UNFPA OFFICE INDONESIA


DRAWING TITLE

DRAWING LIST

DRAWING No.	REVISION
1908 - INT - 000	REV E

SCALE	CHECKED	AN
NTS		
DATE	DRAWN	TR
JANUARY 2020		

NOTE :

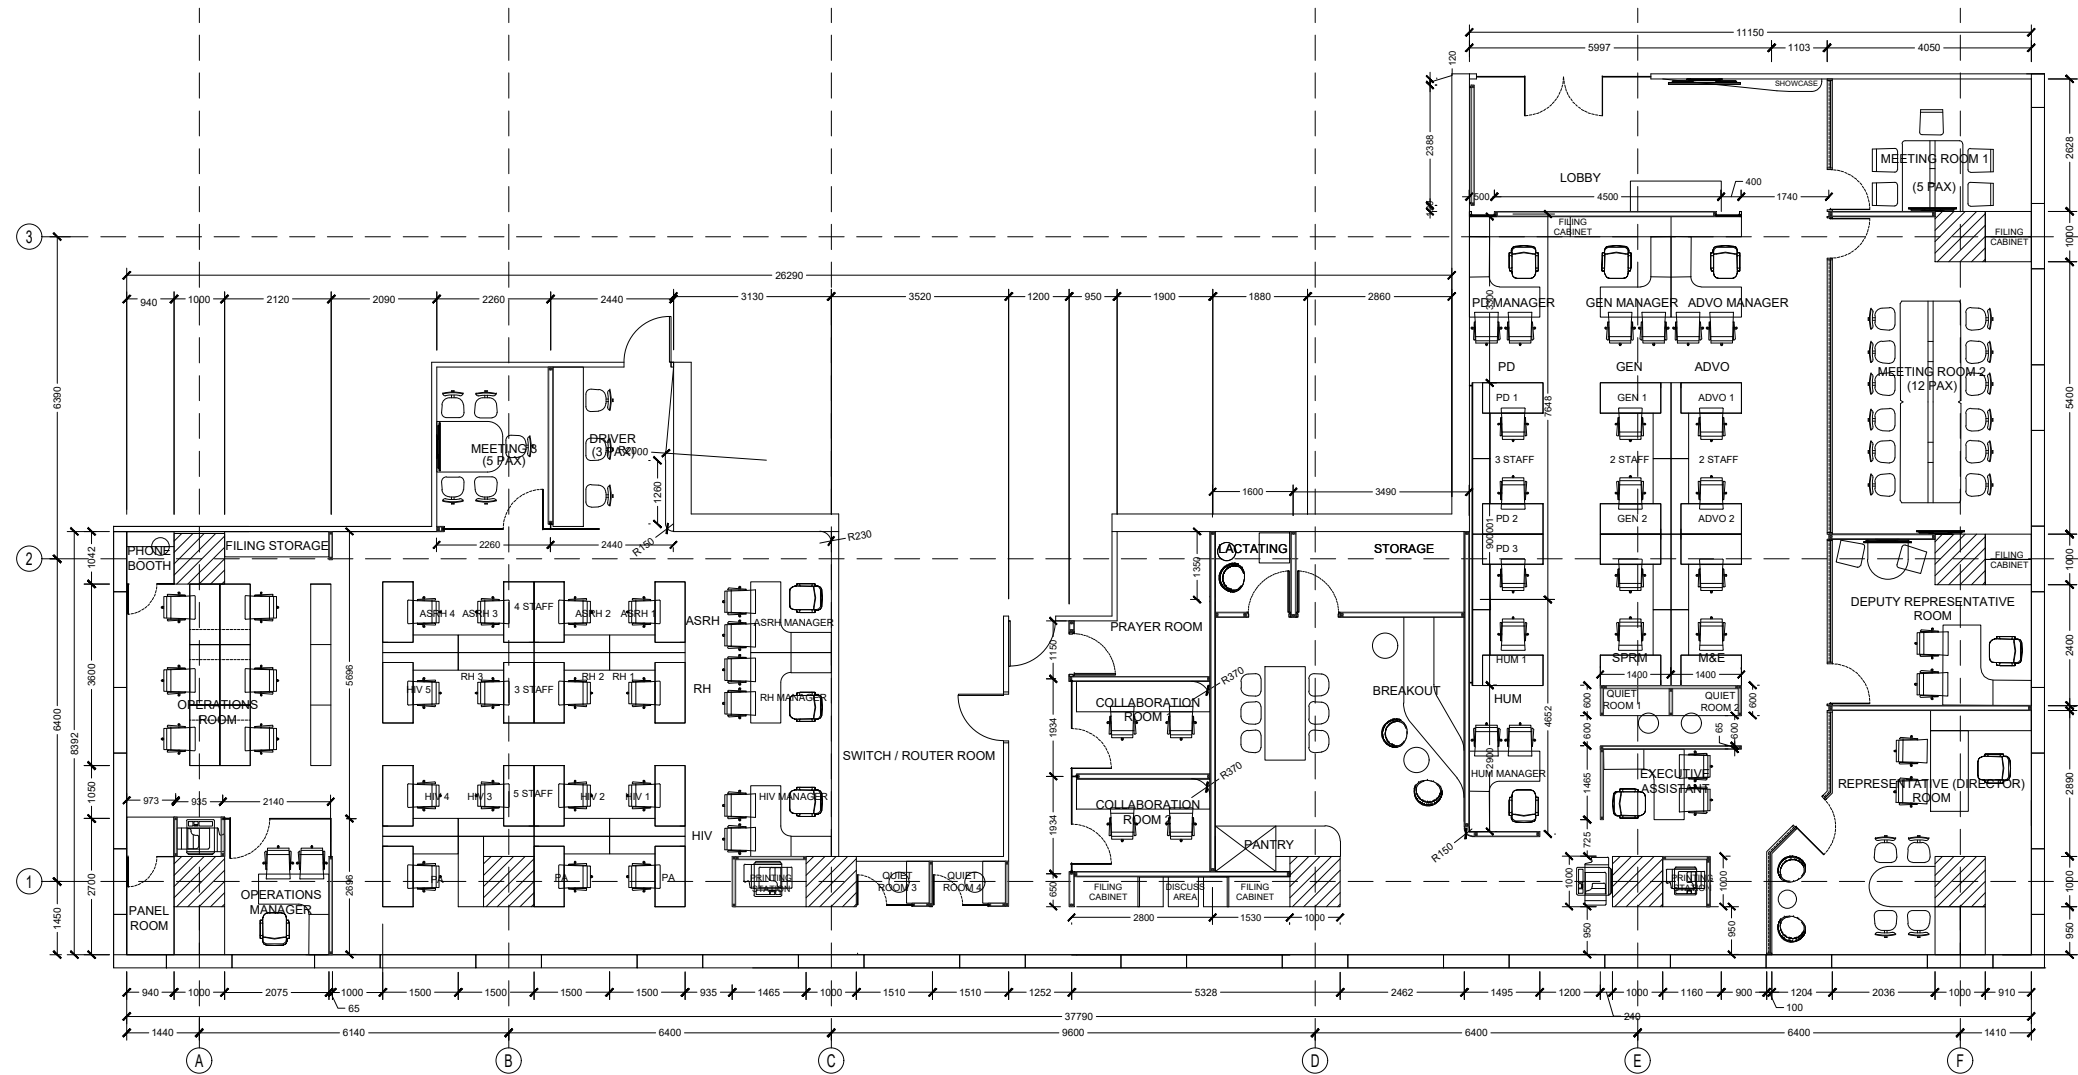

— LAYOUT PLAN
INT-101 SCALE 1 : 150

DEZAN STUDIO
Bintaro Business Centre Building
Jl. RC Veteran No. 1-1 Bintaro
Phone: +62 21 7357679
Fax: +62 21 7433946
www.dezanstudio.com
admin@dezanstudio.com

CLIENT

UNFPA


PROJECT

UNFPA OFFICE INDONESIA

DRAWING TITLE

LAYOUT PLAN

DRAWING No.	REVISION
1908 - INT - 101	REV E
SCALE 1 : 150	CHECKED AN
DATE JANUARY 2020	DRAWN TR

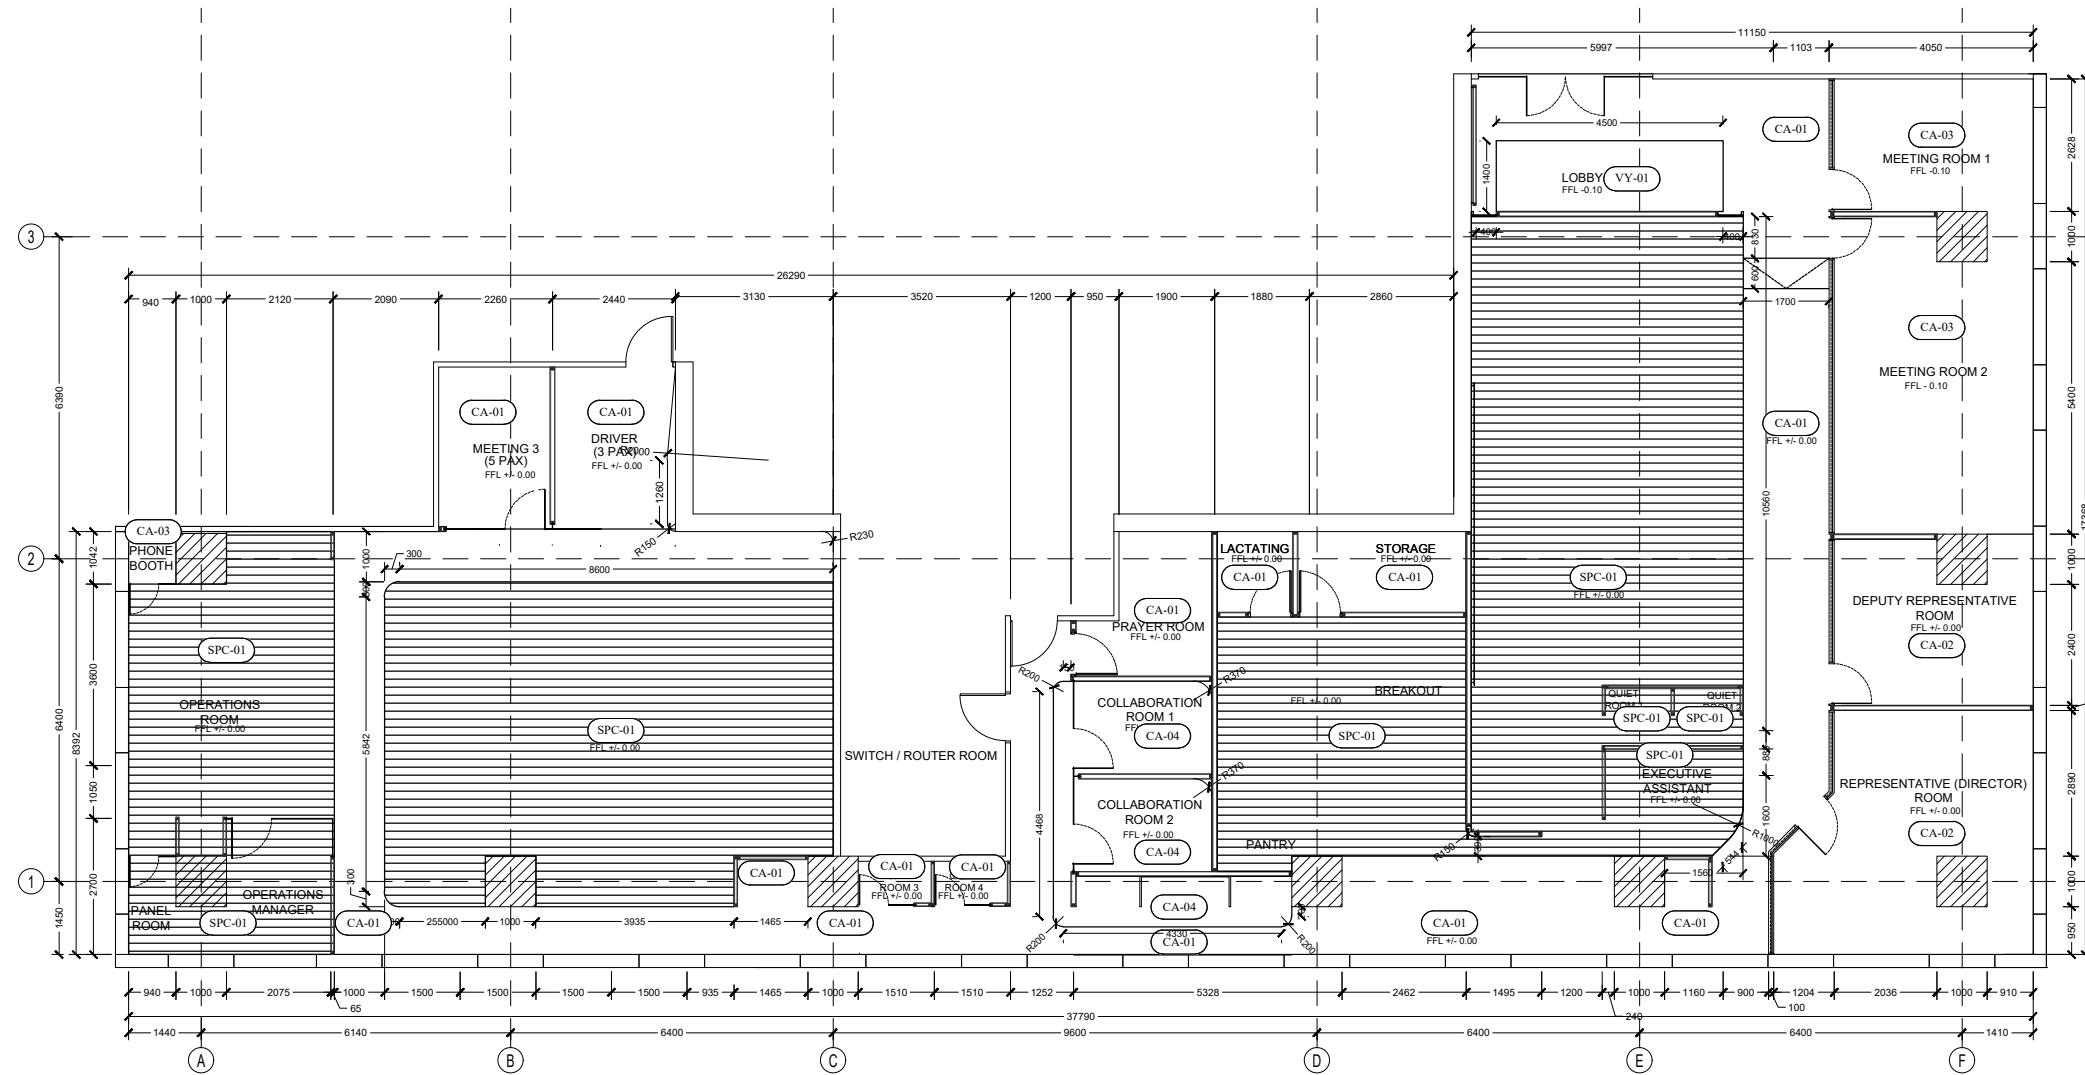


INT-102 FLOOR FINISH PLAN
SCALE 1 : 150

- NOTE :
- SPC-01 SPC EX. KANA
 - CA-01 GREY CARPET EX. TOLI
 - CA-02 GREY GRADATION CARPET EX. VOXFLOOR
 - CA-03 ORANGE GRADATION CARPET EX. MILLIKEN TYPE LAYLINES
 - CA-04 ORANGE CARPET EX.TOLI
 - VY-01 ORANGE VYNIL EX. POLIFLOOR







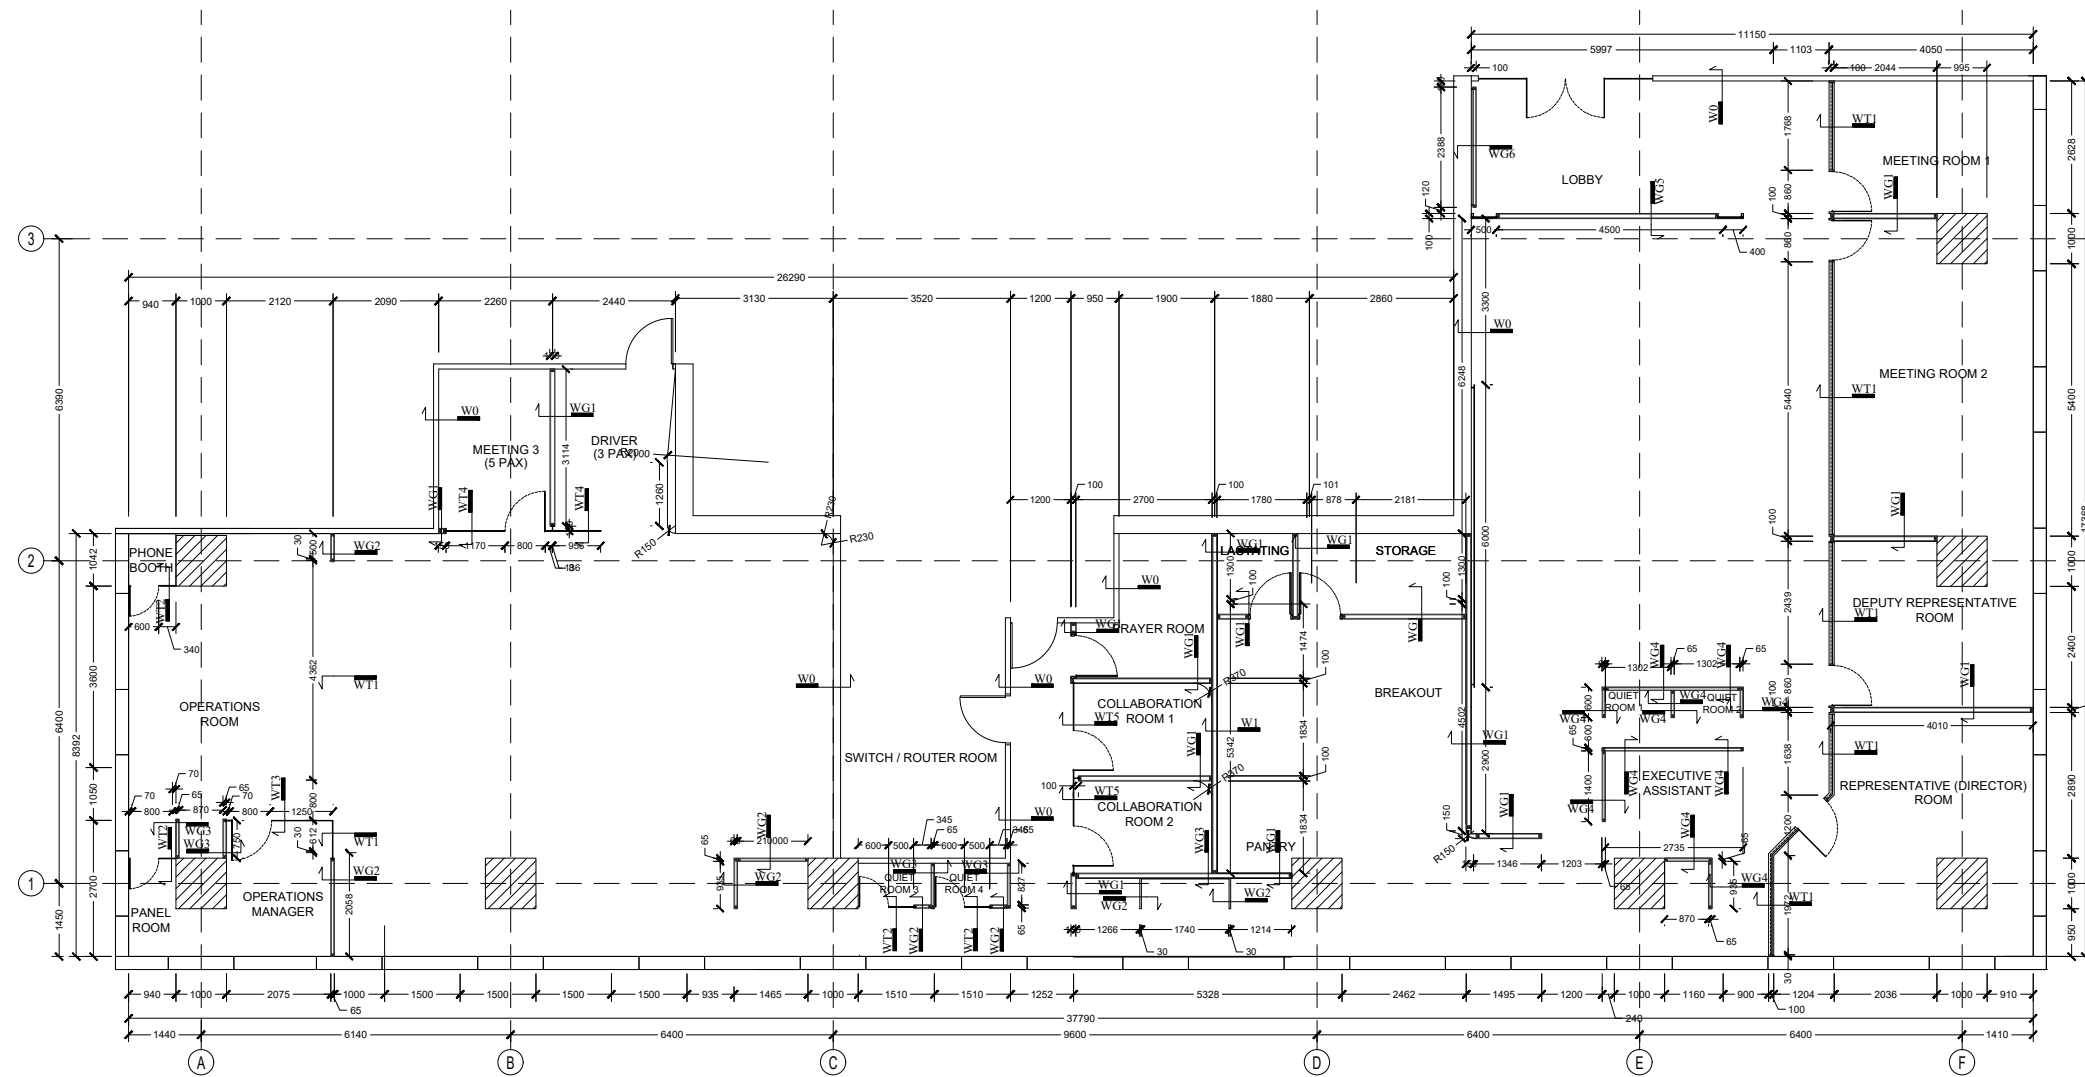





FOR ALL WOOD MATERIAL
PLEASE COVER BY FIRE PROOF
& TERMITE TREATMENT

DEZAN STUDIO
Bintaro Business Centre Building
Jl. RC Veteran No. 1-1 Bintaro
Phone: +62 21 7357679
Fax: +62 21 7433946
www.dezanstudio.com
admin@dezanstudio.com

CLIENT	
UNFPA	
PROJECT	
UNFPA OFFICE INDONESIA	
DRAWING TITLE	
FLOOR FINISH PLAN	
DRAWING No.	REVISION
1908 - INT - 102	REV E
SCALE 1 : 150	CHECKED AN
DATE JANUARY 2020	DRAWN TR





PARTITION PLAN
 SCALE 1 : 150

- NOTE :**
- 1  **W0** : EXISTING PARTITION
 - 1  **WG1** : GYPSUM PARTITION UP TO CEILING W/ ROCKWOOL, W 100MM
 - 1  **WG2** : GYPSUM PARTITION UP TO CEILING W/ ROCKWOOL, W 65MM
 - 1  **WG3** : GYPSUM PARTITION W/ ROCKWOOL + PADDED WALL (INSULATION)
 - 1  **WG4** : GYPSUM PARTITION +1500mm ROCKWOOL+PADDED WALL (INSULATION)
 - 1  **WG5** : GYPSUM PARTITION +2250mm W/ ROCKWOOL, W 100MM+GLASSTONE
 - 1  **WG6** : GYPSUM PARTITION W/ ROCKWOOL, W 100MM
 - 1  **WT1** : 12MM THK TEMPERED GLASS W/ FRAME
 - 1  **WT2** : 12MM THK TEMPERED GLASS UP TO CEILING
 - 1  **WT3** : 12MM THK TEMPERED GLASS +2700mm +GYPSUM BOARD W/ ROCKWOOL
 - 1  **WT4** : 12MM THK TEMPERED GLASS +2400mm +GYPSUM BOARD W/ ROCKWOOL
 - 1  **WT5** : 12MM THK TEMPERED GLASS +2200mm +GYPSUM BOARD W/ ROCKWOOL
- * DETAIL REFER TO INT-301 - INT-303


DEZAN STUDIO
 Bintaro Business Centre Building
 Jl. RC Veteran No. 1-1 Bintaro
 Phone: +62 21 7357679
 Fax: +62 21 7433946
 www.dezanstudio.com
 admin@dezanstudio.com

CLIENT	
UNFPA	
PROJECT	
UNFPA OFFICE INDONESIA	
DRAWING TITLE	
PARTITION PLAN	
DRAWING No.	REVISION
1908 - INT - 103	REV E
SCALE 1 : 150	CHECKED AN
DATE JANUARY 2020	DRAWN TR

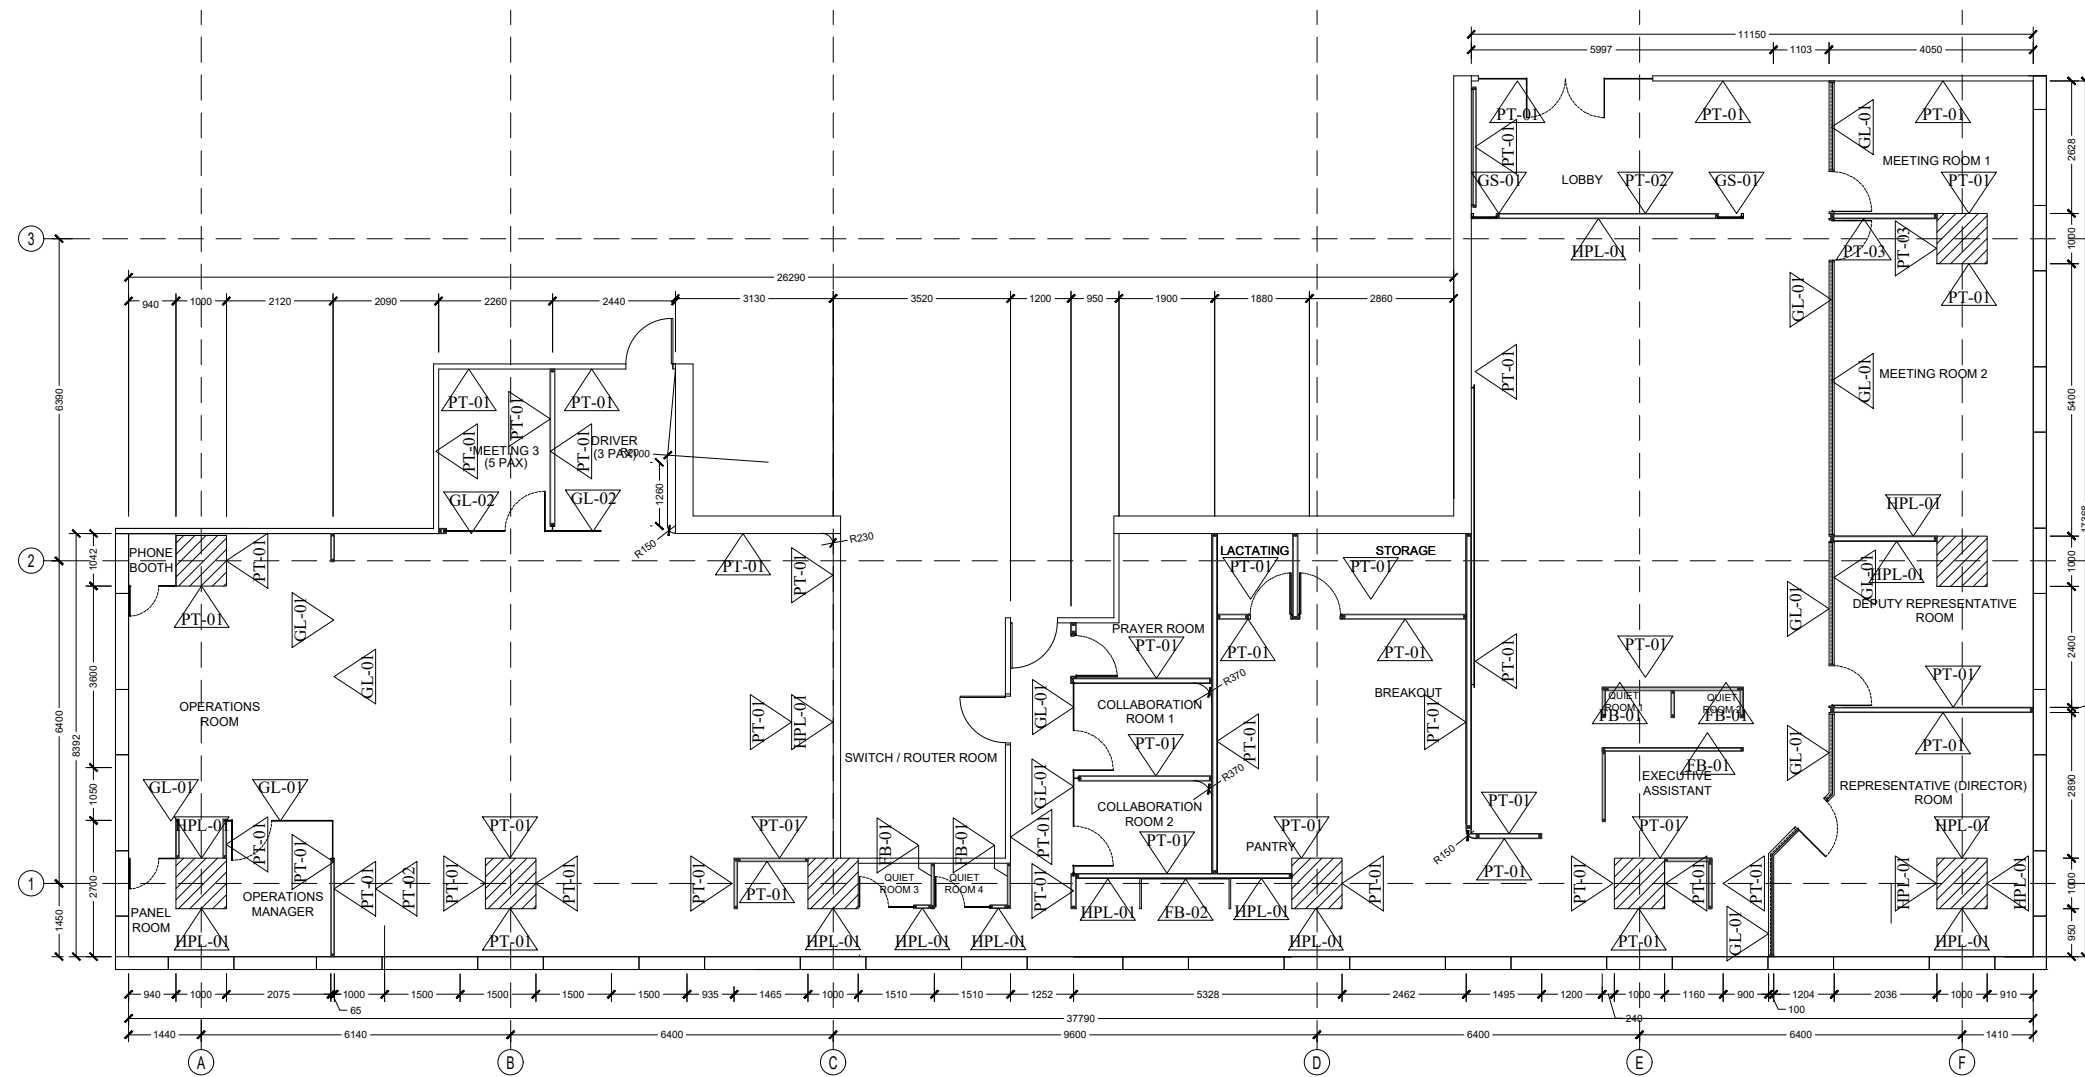


INT-104 WALL FINISHES PLAN
SCALE 1 : 150

- NOTE :
- : EXISTING MATERIAL
 - : WALLPAINT WHITE COLOR
ex. DULUX TYPE COTTON FANTASY
 - : WALLPAINT ORANGE COLOR
ex. DULUX, TYPE MARIGOLD BLOSSOM
 - : WALLPAINT LIGHT ORANGE
ex. DULUX, TYPE TOPAZ SPARKLE
 - : HPL WOOD PATTERN
ex. TACO TH 849 TM ASH AFROMOSIA TIMBER
 - : HPL WHITE COLOR
ex. TACO CHALK TH 040 AA
 - : HPL ORANGE COLOR
ex. TACO CLASSIC ORANGE
 - : 12MM CLEAR TEMPERED GLASS
 - : 12MM CLEAR TEMPERED GLASS ORANGE COLOR
 - : 12MM WHITE GLASS STONE
 - : PADED WALL WITH GREY FABRIC FINISH
 - : PADED WALL WITH ORANGE FABRIC FINISH
- ALL WOOD MATERIAL, COVER FIRE PROOF & TERMITE TREATMENT

DEZAN STUDIO
 Bintaro Business Centre Building
 Jl. RC Veteran No. 1-1 Bintaro
 Phone: +62 21 7357679
 Fax: +62 21 7433946
 www.dezanstudio.com
 admin@dezanstudio.com

CLIENT	
UNFPA	
PROJECT	
UNFPA OFFICE INDONESIA	
DRAWING TITLE	
WALL FINISH PLAN	
DRAWING No.	REVISION
1908 - INT - 104	REV E
SCALE 1 : 150	CHECKED AN
DATE JANUARY 2020	DRAWN TR


NOTE :
 CL-1 : CEILING GYPSUM BOARD WHITE COLOR

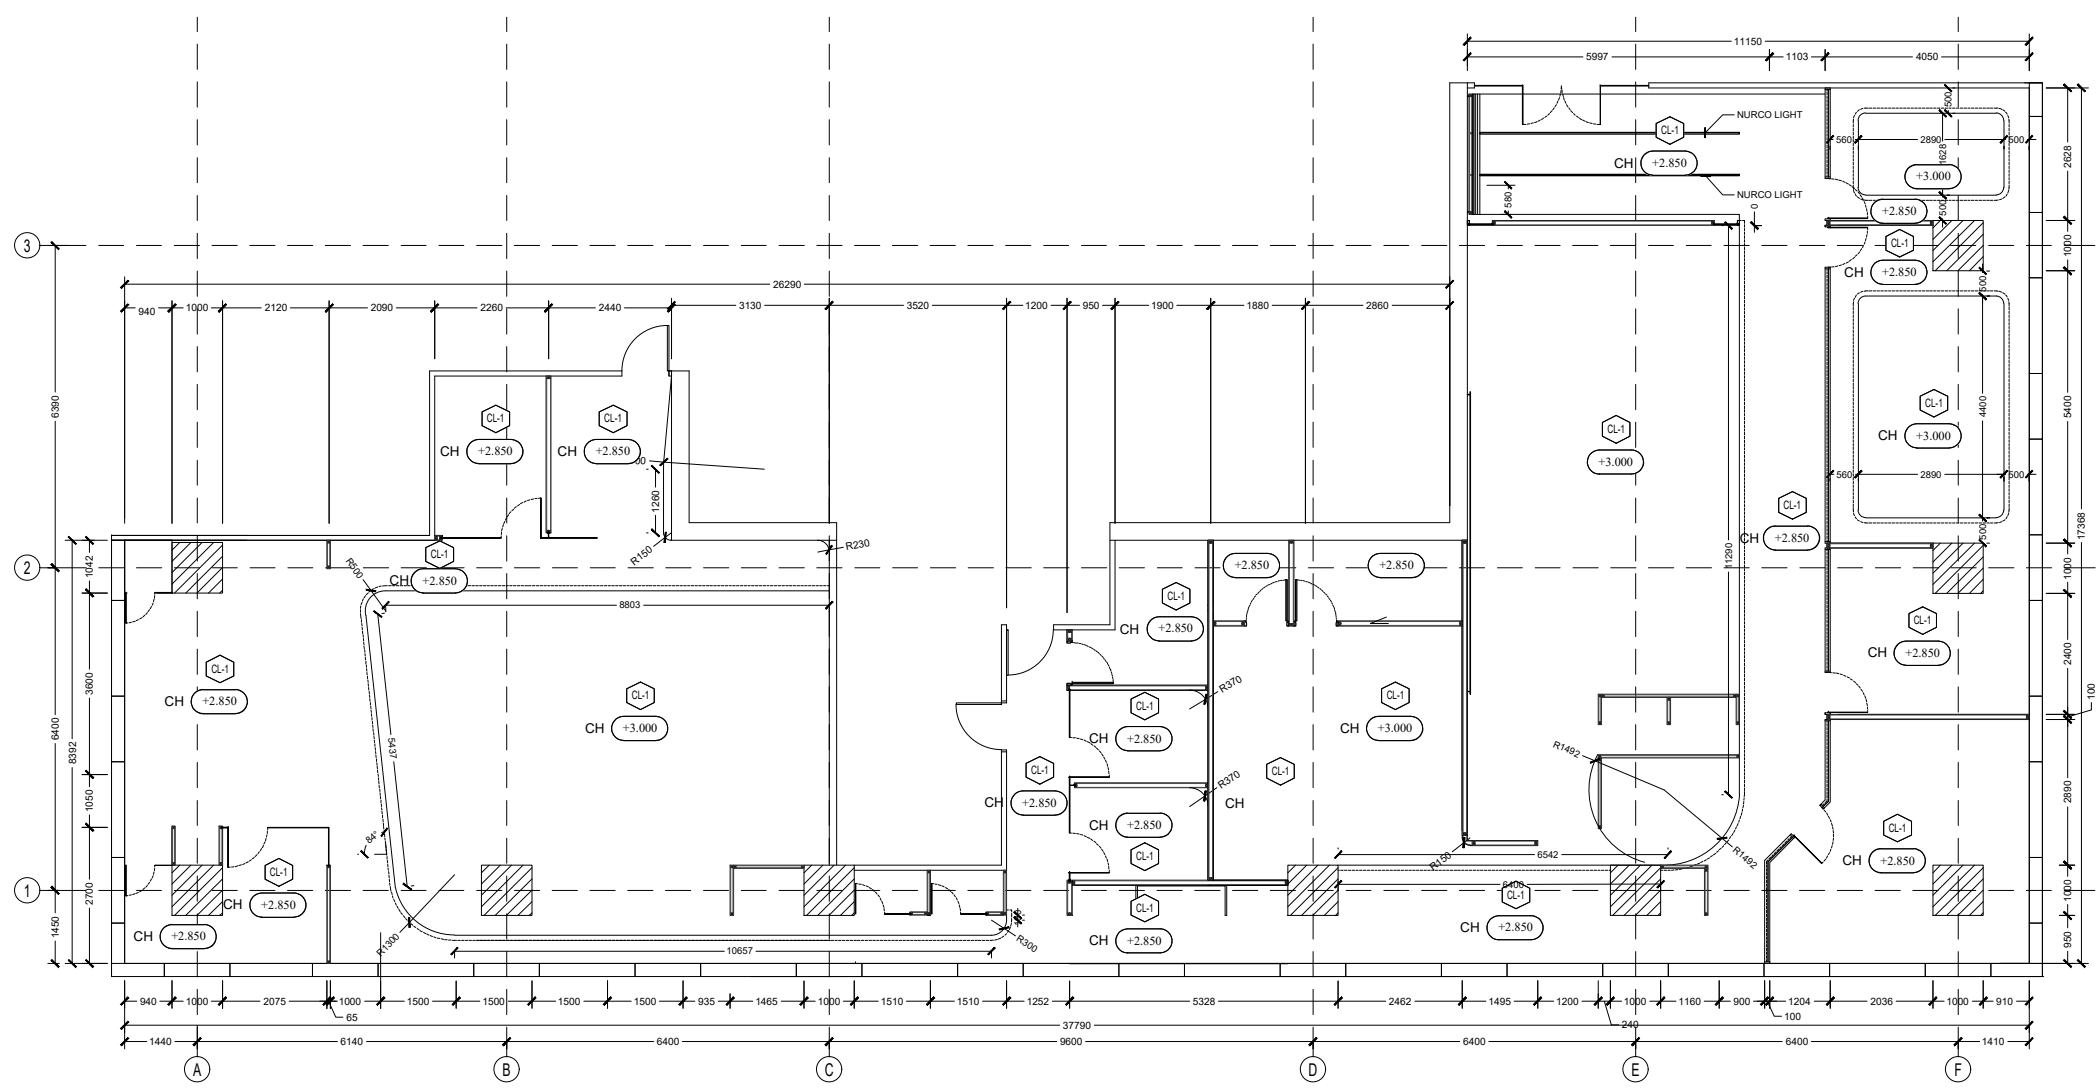

INT-105 CEILING PLAN
 SCALE 1 : 150

DEZAN STUDIO
 Bintaro Business Centre Building
 Jl. RC Veteran No. 1-1 Bintaro
 Phone: +62 21 7357679
 Fax: +62 21 7433946
 www.dezanstudio.com
 admin@dezanstudio.com

CLIENT	
UNFPA	
PROJECT	
UNFPA OFFICE INDONESIA	
DRAWING TITLE	
CEILING PLAN	
DRAWING No.	REVISION
1908 - INT - 105	REV E
SCALE 1 : 150	CHECKED AN
DATE JANUARY 2020	DRAWN TR

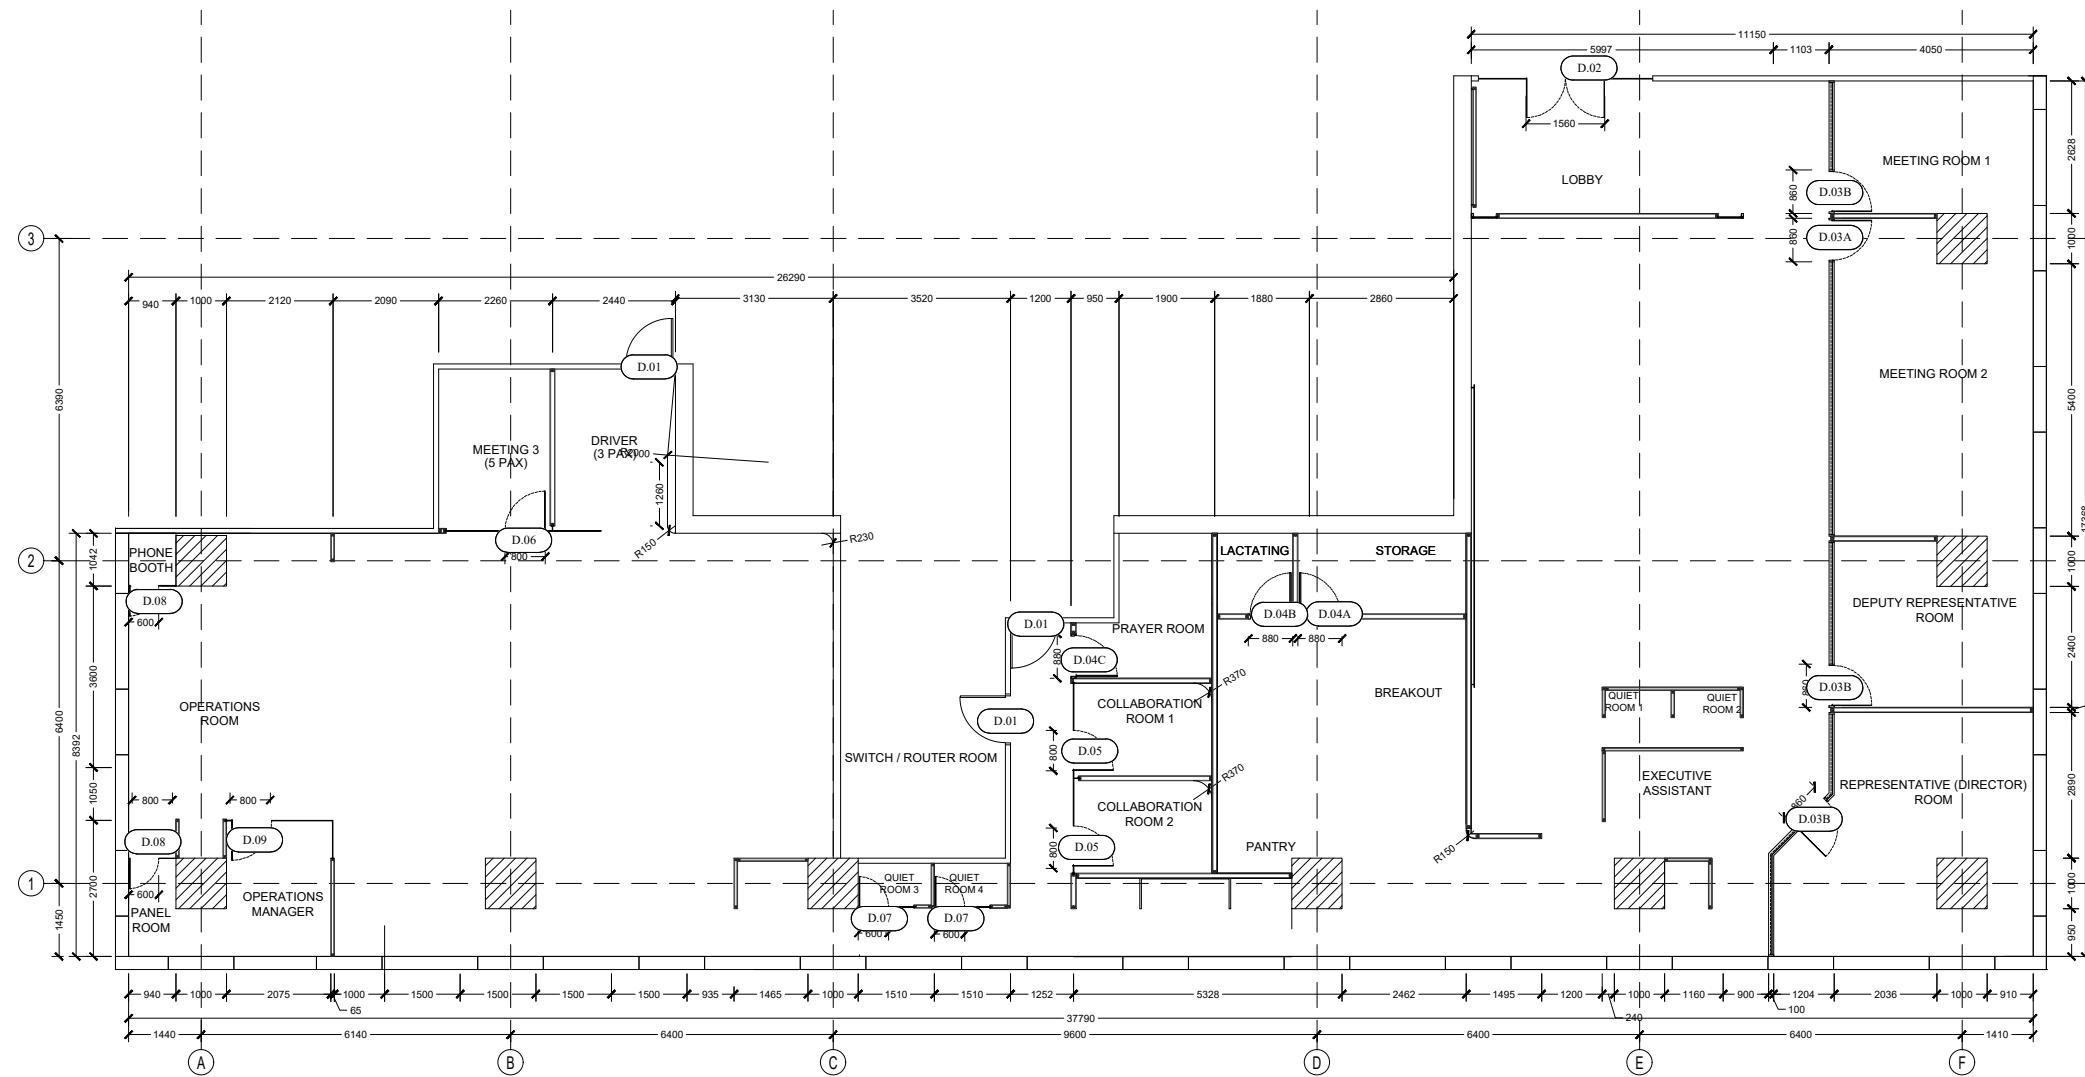

DOOR PLAN
SCALE 1 : 150

NOTE :


- D.01 EXISTING DOOR
- D.02 ENTRANCE 12MM TEMPERED GLASS DOOR 1560 X 2800 MM W/ STICKER INSIDE FACE
- D.03 TEMPERED 12MM GLASS DOOR WITH FRAME 880 X 2700 MM
- D.04 WOOD LAMINATED DOOR WITH FRAME
- D.05 TEMPERED 12MM GLASS DOOR 800 X 2200 MM
- D.06 TEMPERED 12MM GLASS DOOR 800 X 2400 MM
- D.07 TEMPERED 12MM GLASS DOOR 600 X 2200 MM
- D.08 TEMPERED 12MM GLASS DOOR 600 X 2800 MM
- D.09 TEMPERED 12MM GLASS DOOR 800 X 2700 MM

FOR ALL WOOD MATERIAL
PLEASE COVER BY FIRE PROOF
& TERMITE TREATMENT

*DETAIL REFER TO INT-401 - INT-403

DEZAN STUDIO
Bintaro Business Centre Building
Jl. RC Veteran No. 1-1 Bintaro
Phone: +62 21 7357679
Fax: +62 21 7433946
www.dezanstudio.com
admin@dezanstudio.com

CLIENT	
UNFPA	
PROJECT	
UNFPA OFFICE INDONESIA	
DRAWING TITLE	
DOOR PLAN	
DRAWING No.	REVISION
1908 - INT - 106	REV E
SCALE 1 : 150	CHECKED AN
DATE JANUARY 2020	DRAWN TR

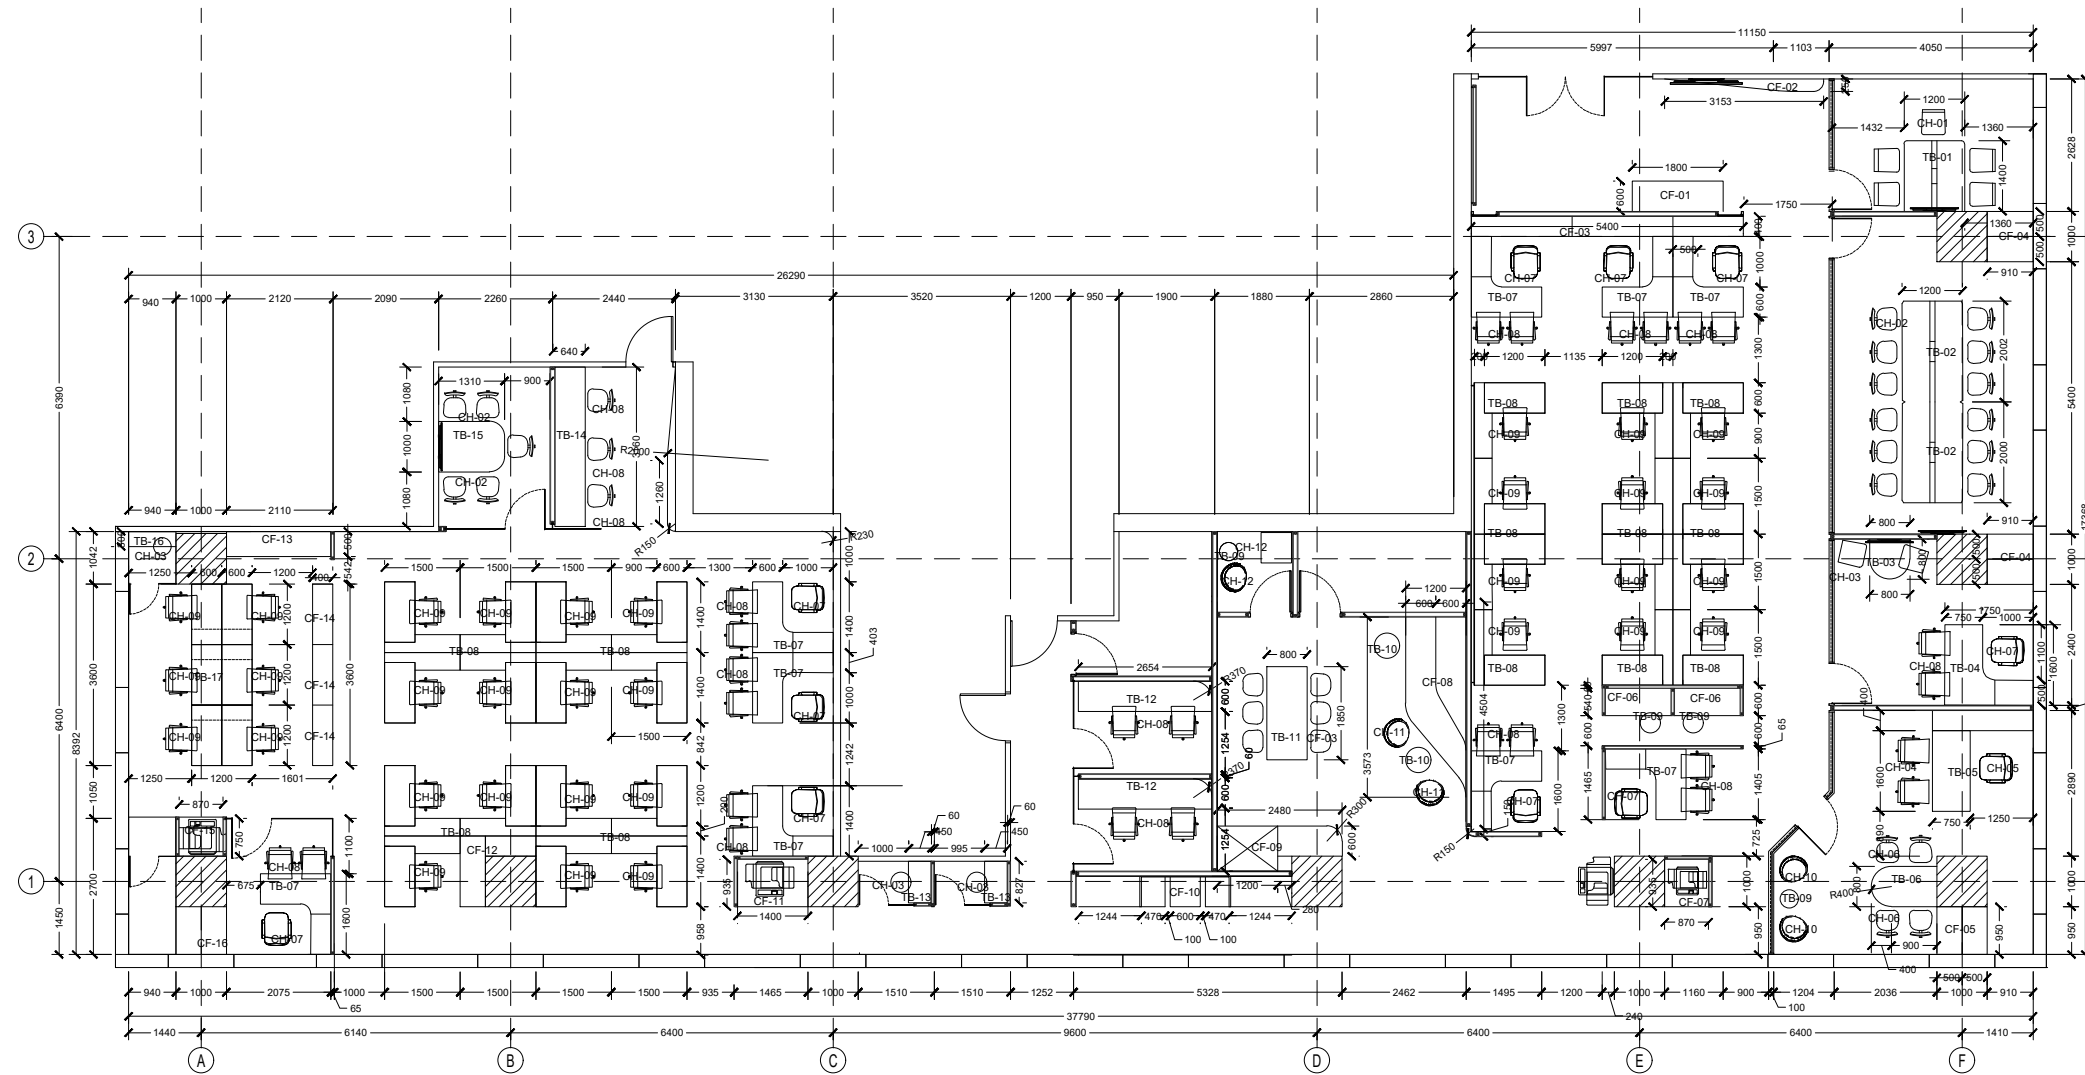

— FURNITURE PLAN
 INT-107 SCALE 1 : 150

NOTE :

- CUSTOM FURNITURE
 CF-01 : LOBBY BENCH
 CF-02 : SHOWCASE PRODUCTS
 CF-03 : CABINET
 CF-04 : CABINET 2
 CF-05 : CRENZNA 1
 CF-06 : QUITE ROOM SEATING
 CF-07 : PRINTING STATION CABINET 1
 CF-08 : AMPHITHEATRE PANTRY
 CF-09 : PANTRY CABINET
 CF-10 : CABINET & DISCUSS SPACE
 CF-11 : PRINTING STATION CABINET 2
 CF-12 : CABINET 3
 CF-13 : CABINET 4
 CF-14 : CRENZNA 2
 CF-15 : PRINTING STATION 3
 CF-16 : CABINET 5


- TABLE
 TB-01 : MEETING TABLE 1
 TB-02 : MEETING TABLE 2
 TB-03 : MEETING TABLE 3
 TB-04 : WORKSTATION 1
 TB-05 : DIRECTOR WORKSTATION
 TB-06 : MEETING TABLE 4
 TB-07 : WORKSTATION 2
 TB-08 : WORKSTATION 3
 TB-09 : ROUND TABLE 1
 TB-10 : ROUND TABLE 2
 TB-11 : PANTRY TABLE
 TB-12 : COLLABORATION TABLE
 TB-13 : QUIET ROOM TABLE
 TB-14 : DRIVER WORKSTATION
 TB-15 : MEETING TABLE 5
 TB-16 : PHONE BOOTH TABLE

- CHAIR
 CH-01 : MEETING CHAIR 1
 CH-02 : MEETING CHAIR 2
 CH-03 : BARSTOOL
 CH-04 : CHAIR 1
 CH-05 : DIRECTOR CHAIR
 CH-06 : CHAIR 2
 CH-07 : CHAIR 3
 CH-08 : CHAIR 4
 CH-09 : CHAIR 5
 CH-10 : ARMCHAIR DERECTOR
 CH-11 : BEANBAG
 CH-12 : NURSERY ROOM CHAIR

*DETAIL REFER TO INT-501 - INT-516

DEZAN STUDIO
 Bintaro Business Centre Building
 Jl. RC Veteran No. 1-1 Bintaro
 Phone: +62 21 7357679
 Fax: +62 21 7433946
 www.dezanstudio.com
 admin@dezanstudio.com

CLIENT	
UNFPA	
PROJECT	
UNFPA OFFICE INDONESIA	
DRAWING TITLE	
FURNITURE PLAN	
DRAWING No.	REVISION
1908 - INT - 107	REV E
SCALE 1 : 150	CHECKED AN
DATE JANUARY 2020	DRAWN TR

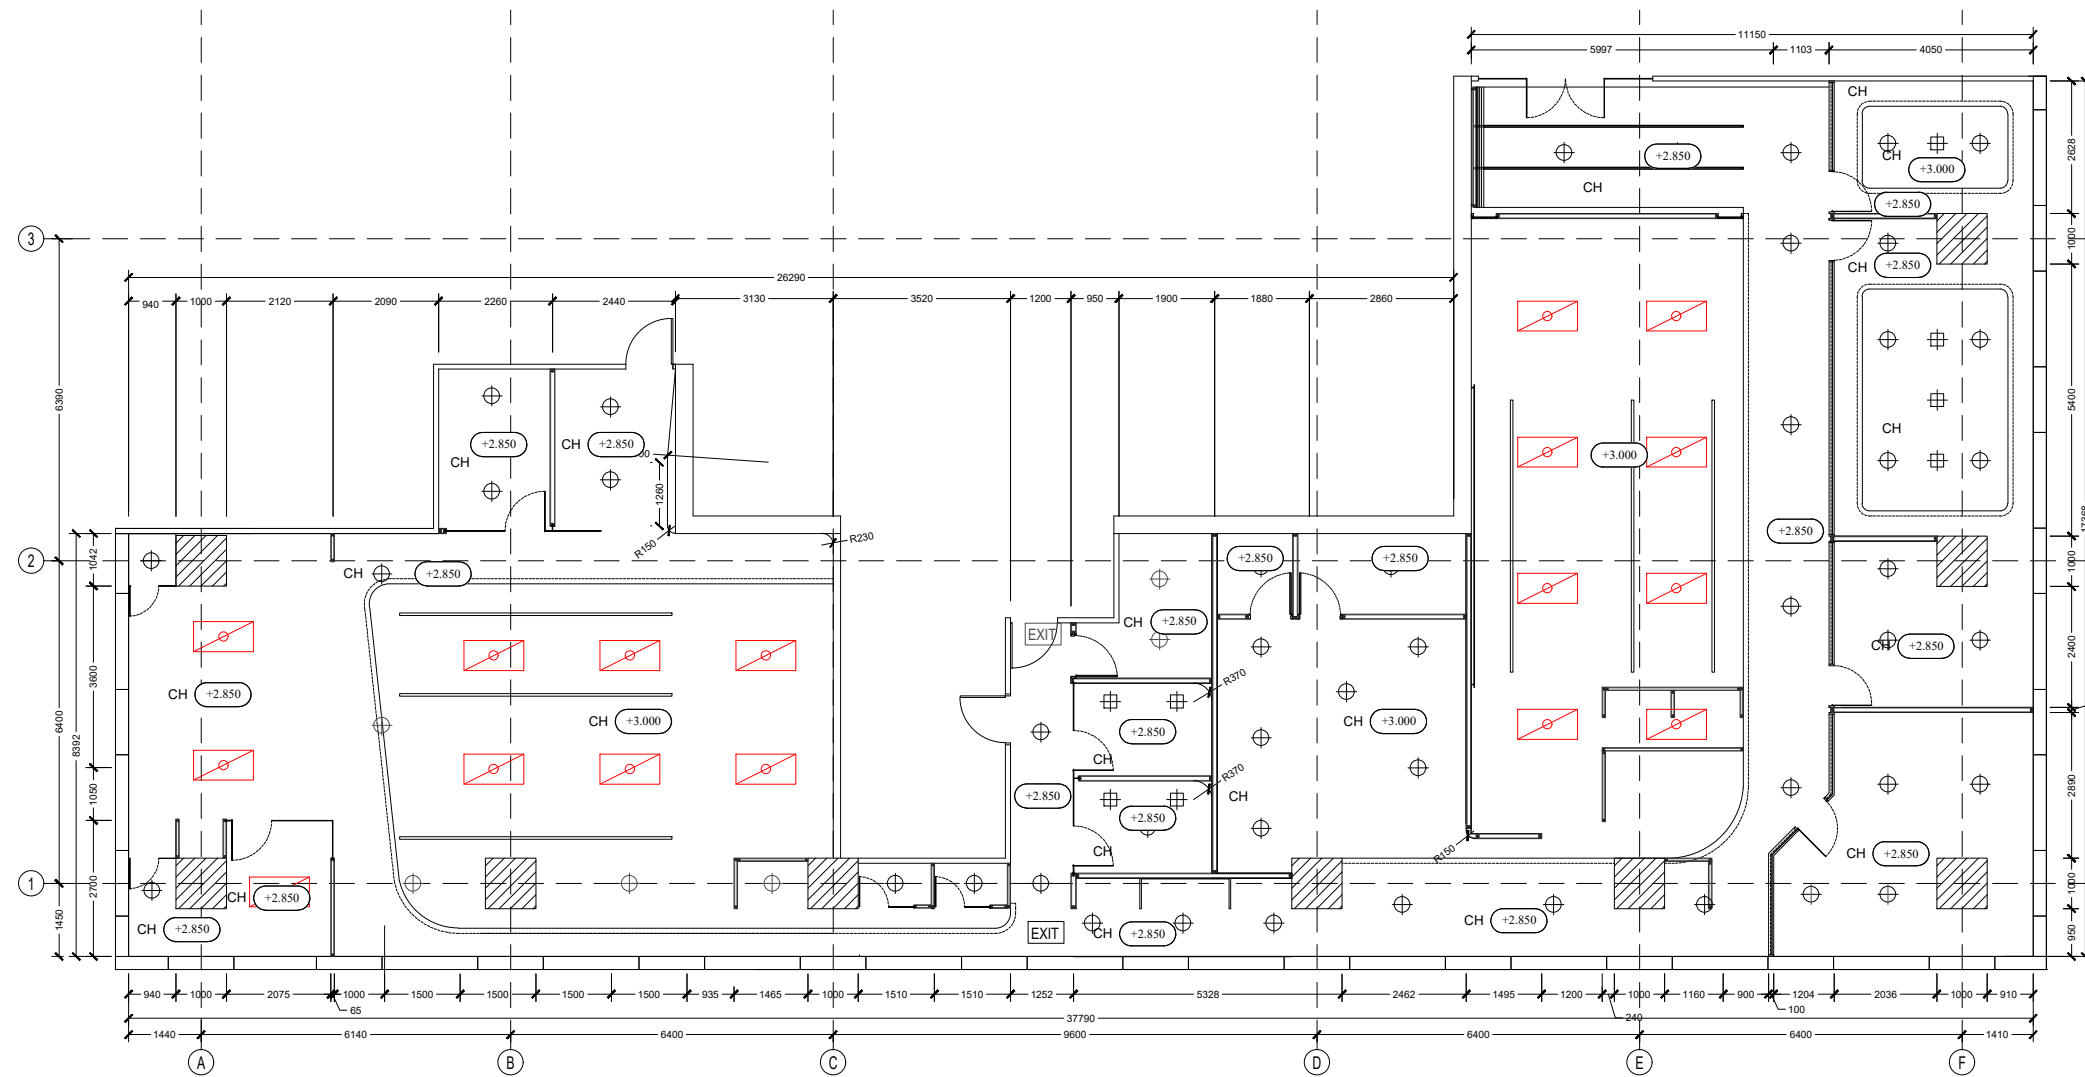


INT-108 LIGHTING PLAN
SCALE 1 : 150

- NOTE :
- RECESSED MOUNTED LOUVRE MIRROR REFLECTOR
HIGH EFFICIENCY CAT.2 LIGHT FL 3x28W T5
(INTEGRATED DIFFUSER AC SUPPLY/RETURN)
 - RECESSED MOUNTED LOUVRE MIRROR REFLECTOR
HIGH EFFICIENCY CAT.2 LIGHT FL 2x14W T5
(INTEGRATED DIFFUSER AC SUPPLY/RETURN)
 - TCW097 2xT5 28W/84, ELECTRONIC BALLAST
 - DOWNLIGHT
 - HANGING LAMP
 - EXISTING EXIT LAMP LED 4 WATT
 - CEILING SPEAKER BRAND TOA
SUBJECT TO TEST
 - SMOKE DETECTOR BRAND NOHMI FROM JAYA TEKNIK
SUBJECT TO TEST
 - SPRINKLER
SUBJECT TO TEST
 - RELOCATION EQUIPMENT
 - NEW EQUIPMENT
 - TAKE OUT
 - NEW SINGLE SWITCH
 - NEW DOUBLE SWITCH
 - HANGING STRIP LAMP
 - ALL RED LINES
REFER TO NEW DESIGN
- NOTE: FOR EXISTING LAMPS / NOT DRAWN
USE THE EXISTING SWITCH

DEZAN STUDIO
 Bintaro Business Centre Building
 Jl. RC Veteran No. 1-1 Bintaro
 Phone: +62 21 7357679
 Fax: +62 21 7433946
 www.dezanstudio.com
 admin@dezanstudio.com

CLIENT	
UNFPA	
PROJECT	
UNFPA OFFICE INDONESIA	
DRAWING TITLE	
LIGHTING PLAN	
DRAWING No.	REVISION
1908 - INT - 108	REV E
SCALE 1 : 150	CHECKED AN
DATE JANUARY 2020	DRAWN TR

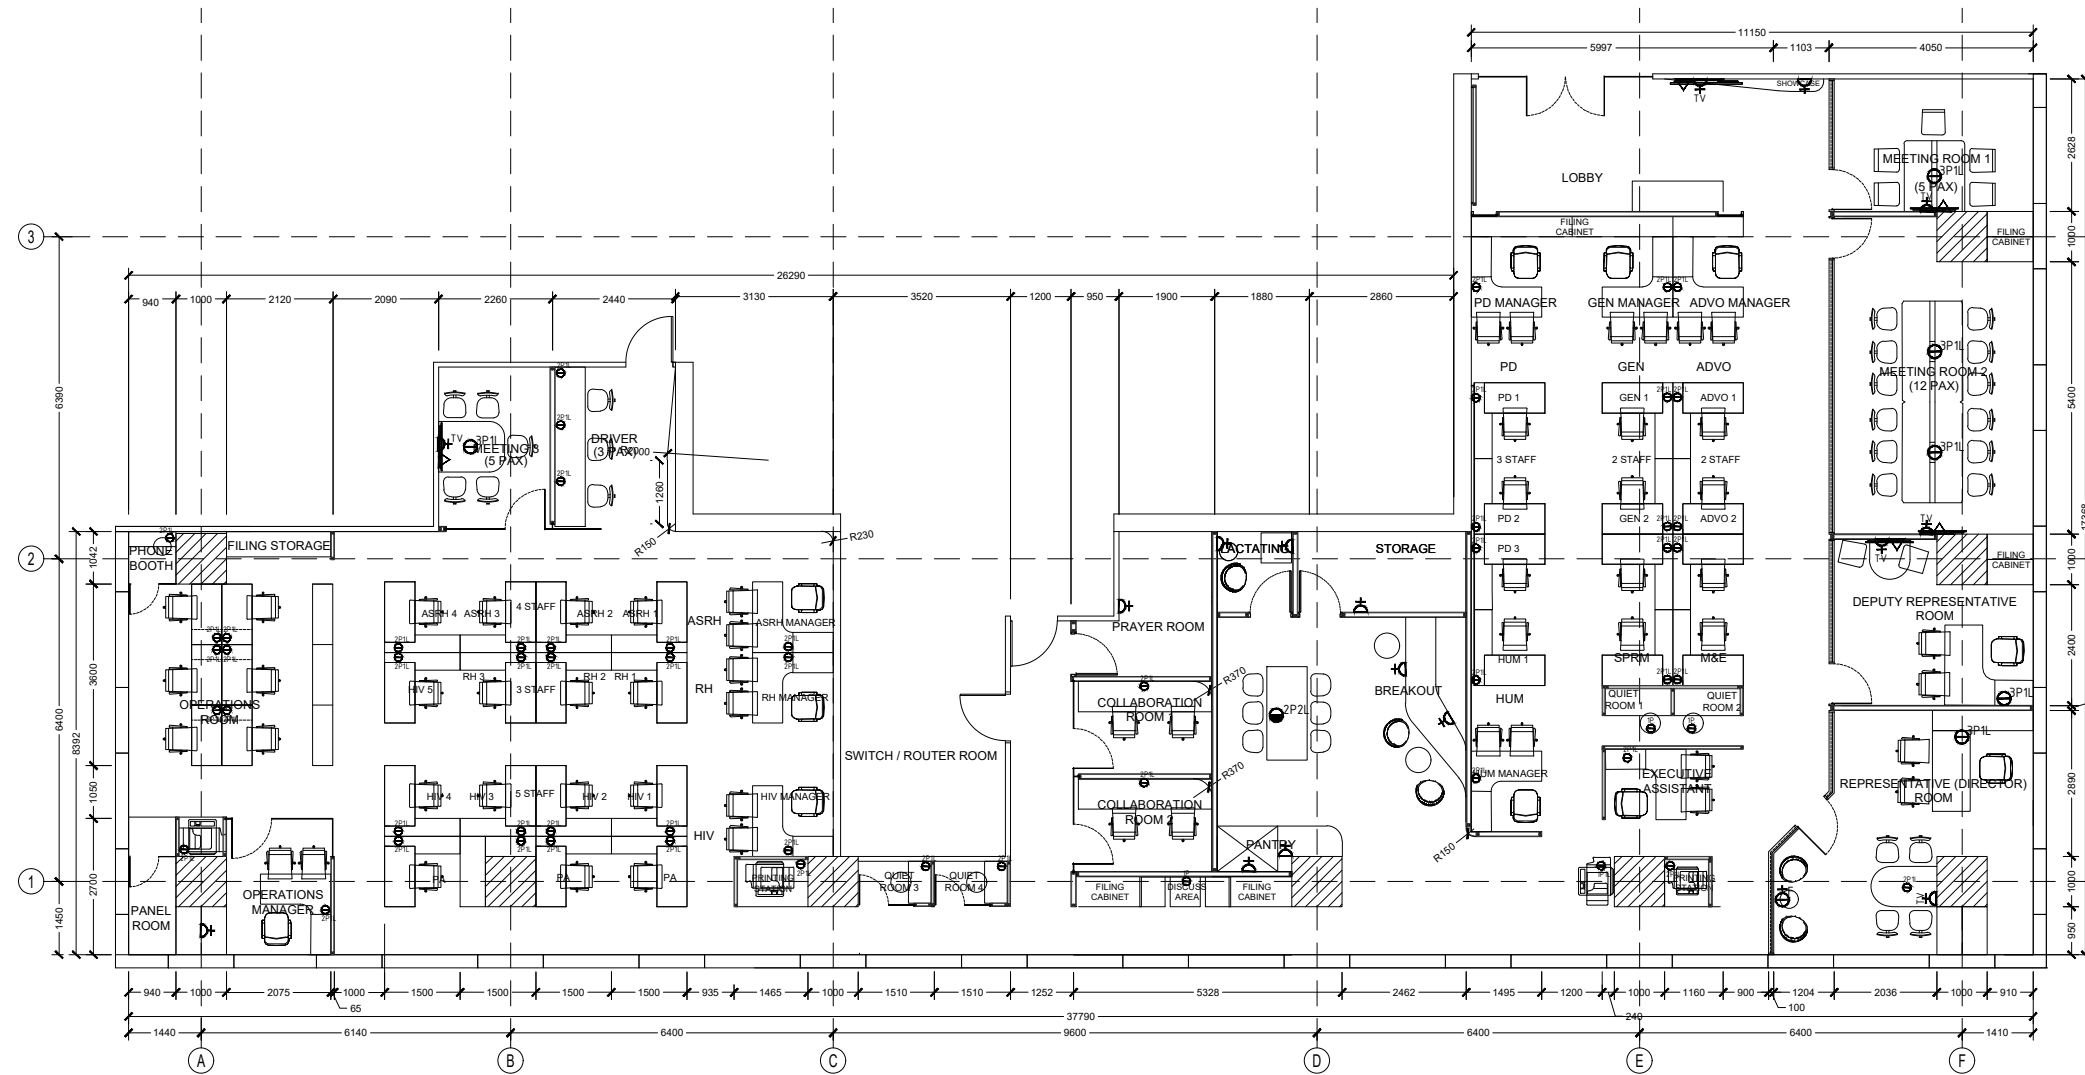

INT-109 LAN & POWER OUTLET PLAN
SCALE 1 : 150

NOTE :

	POWER OUTLET, ON FLOOR
	POWER OUTLET, CLOSE TO SOUND SYSTEM
	POWER OUTLET ON WALL
	POWER OUTLET H±1500 UNTUK TV + HDMI
	2 POWER OUTLET ACCOMMODATE 10.000 VA FOR UPS
	TELEPON OUTLET
	LAN, CLOSE TO SOUND SYSTEM
	LAN ON WALL
	1 POWER OUTLET + 1 LAN (UNDER THE TABLE)
	1 POWER OUTLET + 1 LAN (ON FLOOR)
	1 POWER OUTLET + 1 LAN (ON DESK)
	2 POWER OUTLET + 2 LAN (ON DESK)
	2 POWER OUTLET + 2 LAN (ON FLOOR)
	3 POWER OUTLET + 3 LAN (ON FLOOR)
	4 POWER OUTLET + 4 LAN (ON FLOOR)
	MOTORIZED SCREEN
	PANEL UPS
	RAK SERVER
	PANEL ELEKTRIKAL

DEZAN STUDIO
 Bintaro Business Centre Building
 Jl. RC Veteran No. 1-1 Bintaro
 Phone: +62 21 7357679
 Fax: +62 21 7433946
 www.dezanstudio.com
 admin@dezanstudio.com

CLIENT

UNFPA


PROJECT

UNFPA OFFICE INDONESIA

DRAWING TITLE

LAN & POWER OUTLET PLAN

DRAWING No.	REVISION
1908 - INT - 109	REV E
SCALE 1 : 150	CHECKED AN
DATE JANUARY 2020	DRAWN TR

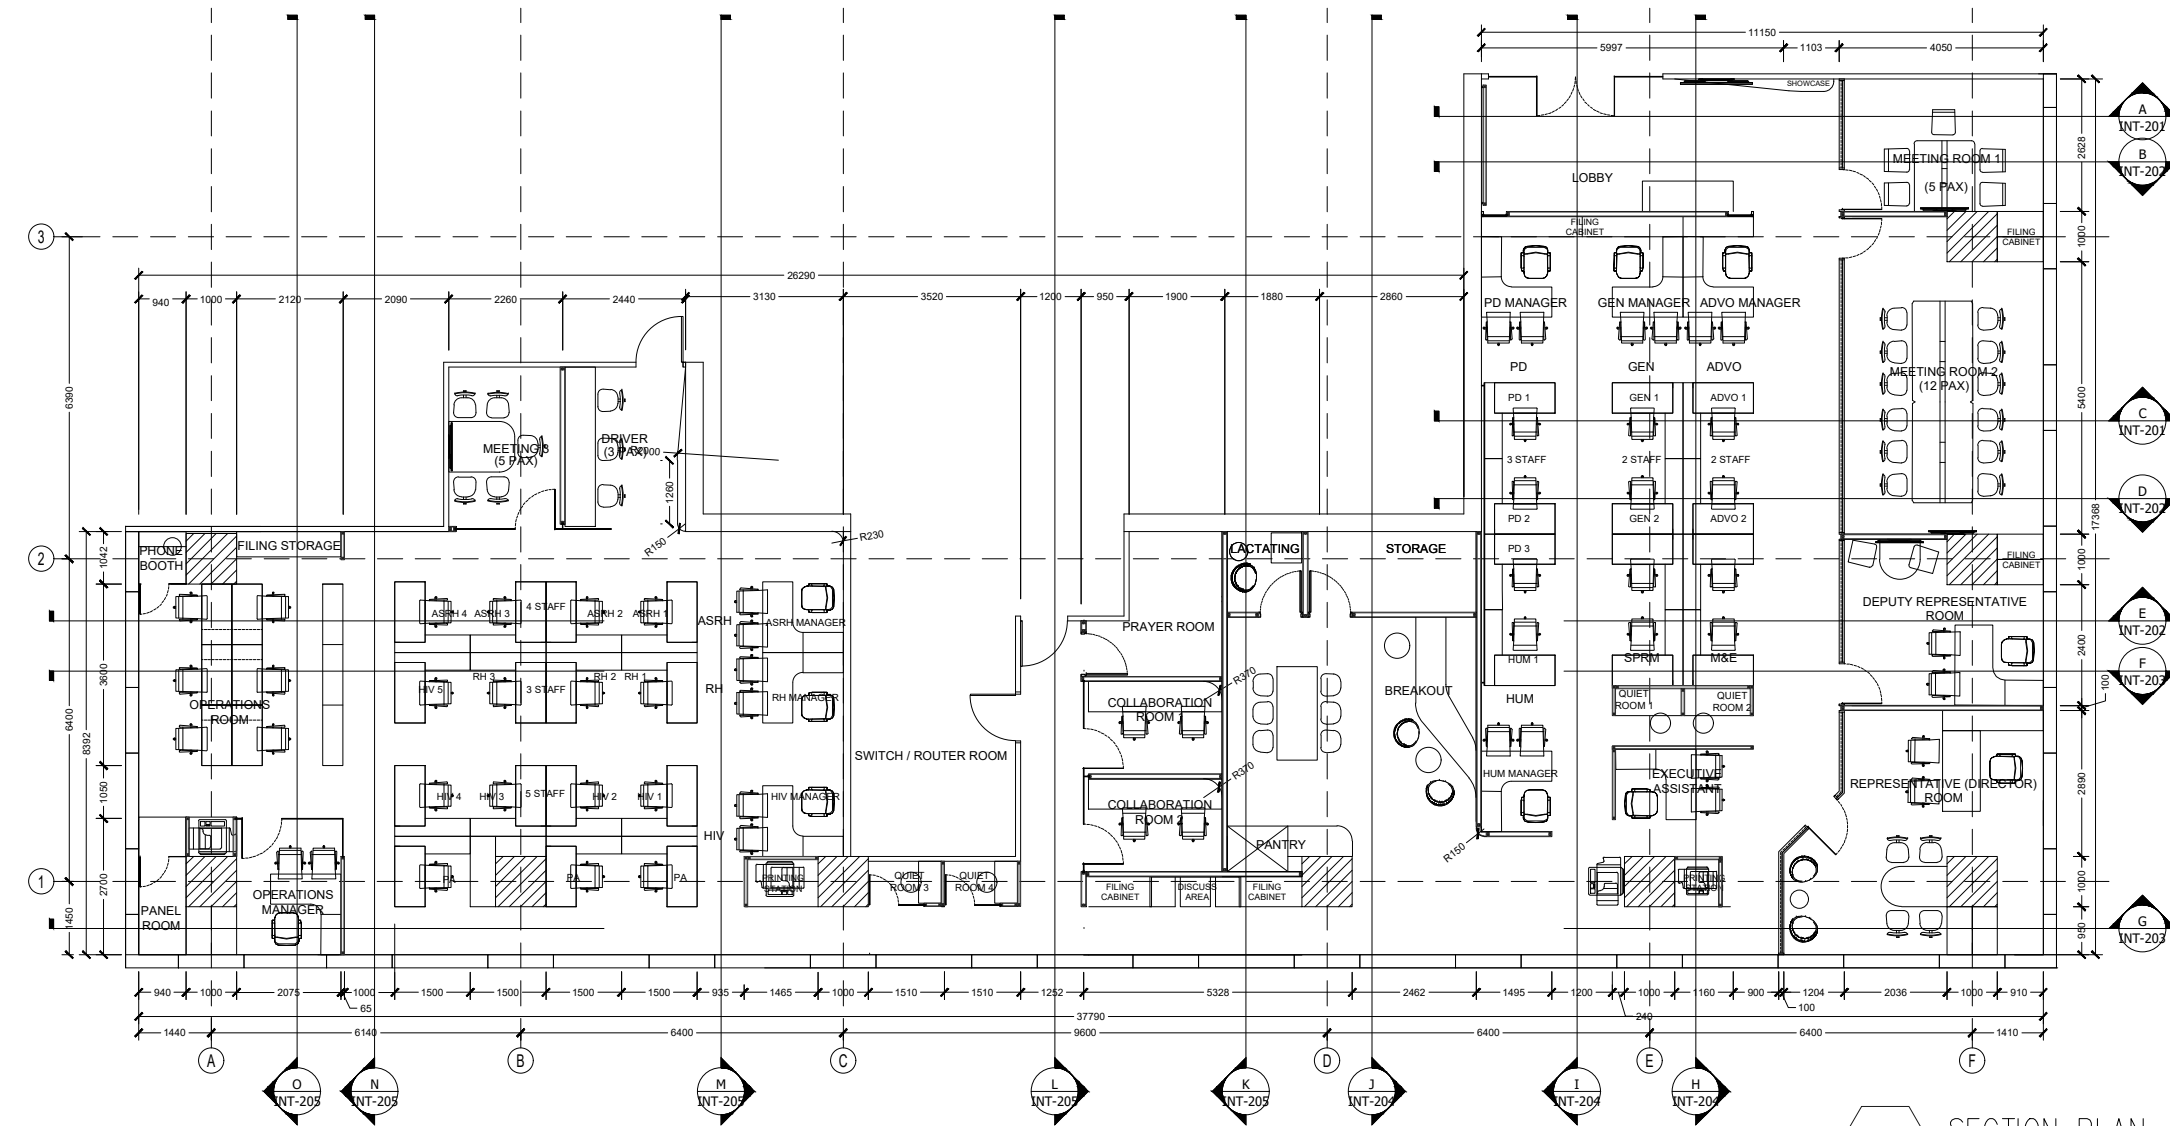


SECTION PLAN
INT-110
SCALE 1 : 150

NOTE :


DEZAN STUDIO
Bintaro Business Centre Building
Jl. RC Veteran No. 14 Bintaro
Phone: +62 21 7357679
Fax: +62 21 7433946
www.dezanstudio.com
admin@dezanstudio.com

CLIENT	
UNFPA	
PROJECT	
UNFPA OFFICE INDONESIA	
DRAWING TITLE	
SECTION PLAN	
DRAWING No.	REVISION
1908 - INT - 110	REV E
SCALE 1 : 150	CHECKED AN
DATE JANUARY 2020	DRAWN TR


NOTE :

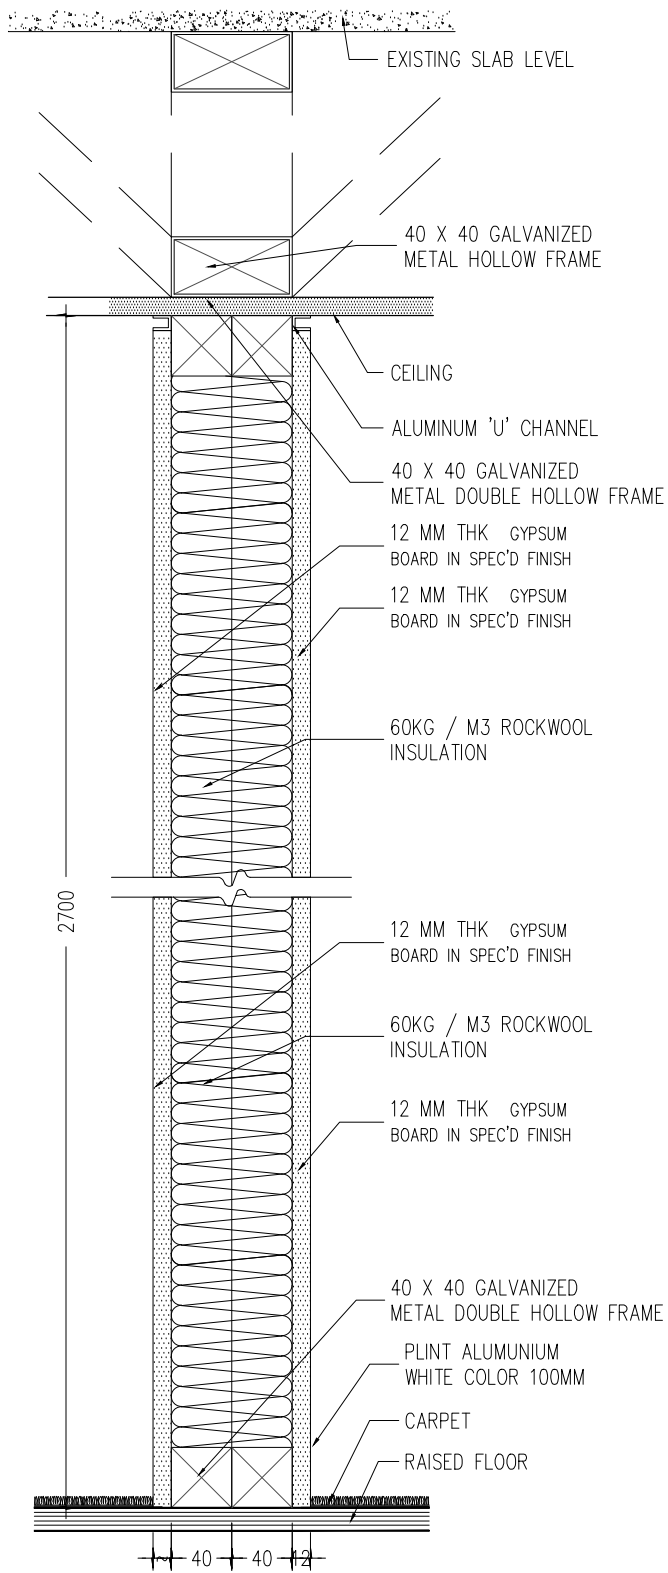

1 DETAIL PARTITION WG1
INT-301 SCALE 1:5

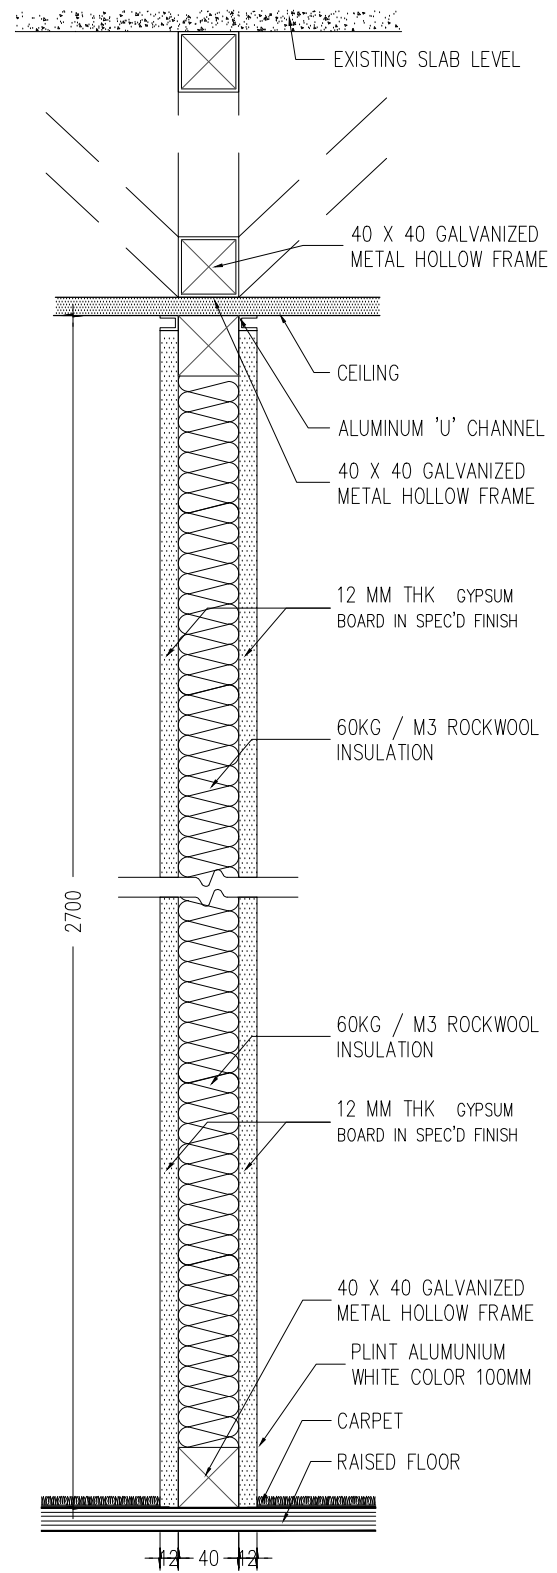

2 DETAIL PARTITION WG2
INT-301 SCALE 1:5

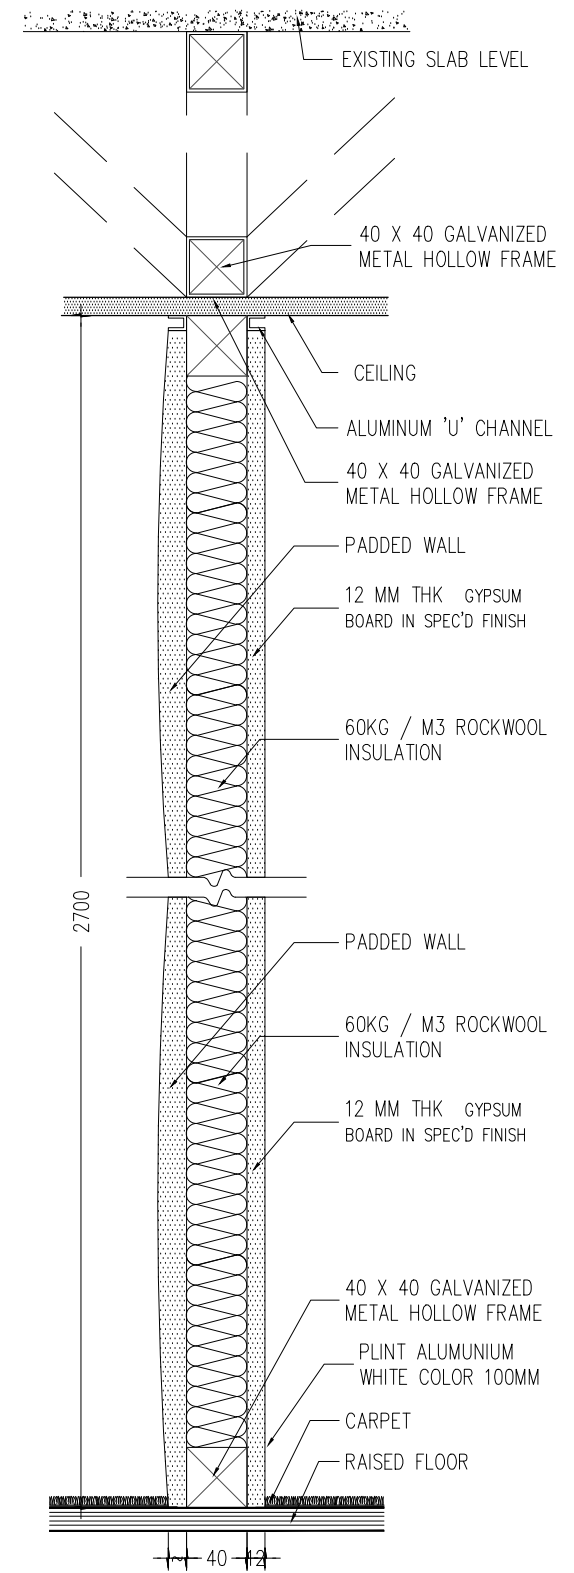

3 DETAIL PARTITION WG3
INT-301 SCALE 1:5

Bintaro Business Centre Building
Jl. RC Veteran No. 1-1 Bintaro
Phone: +62 21 7357679
Fax: +62 21 7433946
www.dezanstudio.com
admin@dezanstudio.com



CLIENT

UNFPA

PROJECT


UNFPA OFFICE INDONESIA

DRAWING TITLE


DETAIL PARTITION WG1, WG2 & WG3

DRAWING No.	REVISION
1908 - INT - 301	REV A
SCALE 1 : 5	CHECKED AN
DATE JANUARY 2020	DRAWN TR


NOTE :

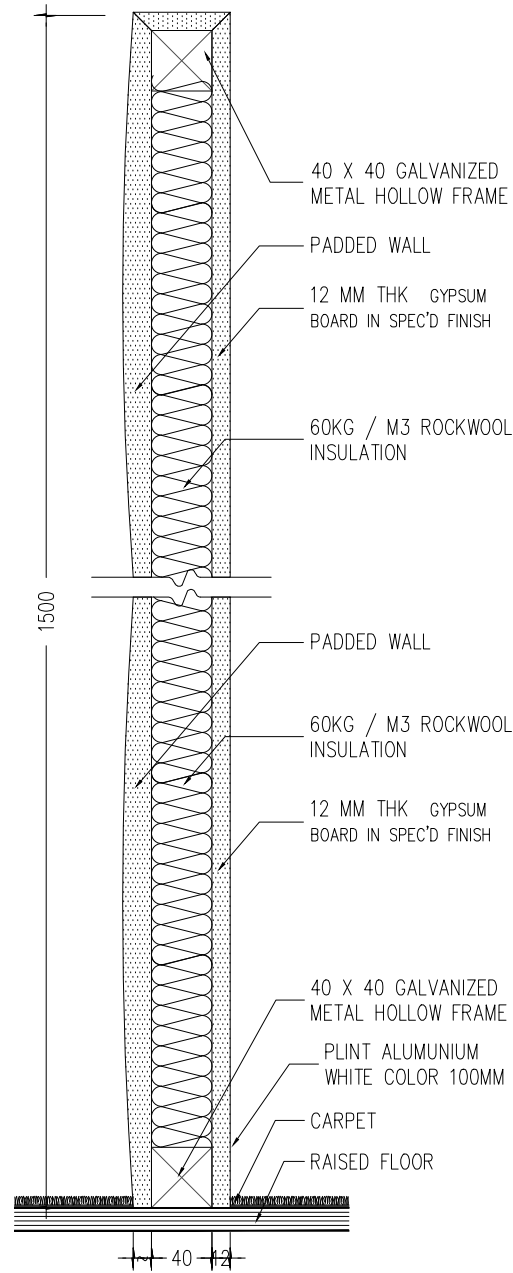

1 DETAIL PARTITION WG4
INT-302 SCALE 1:5

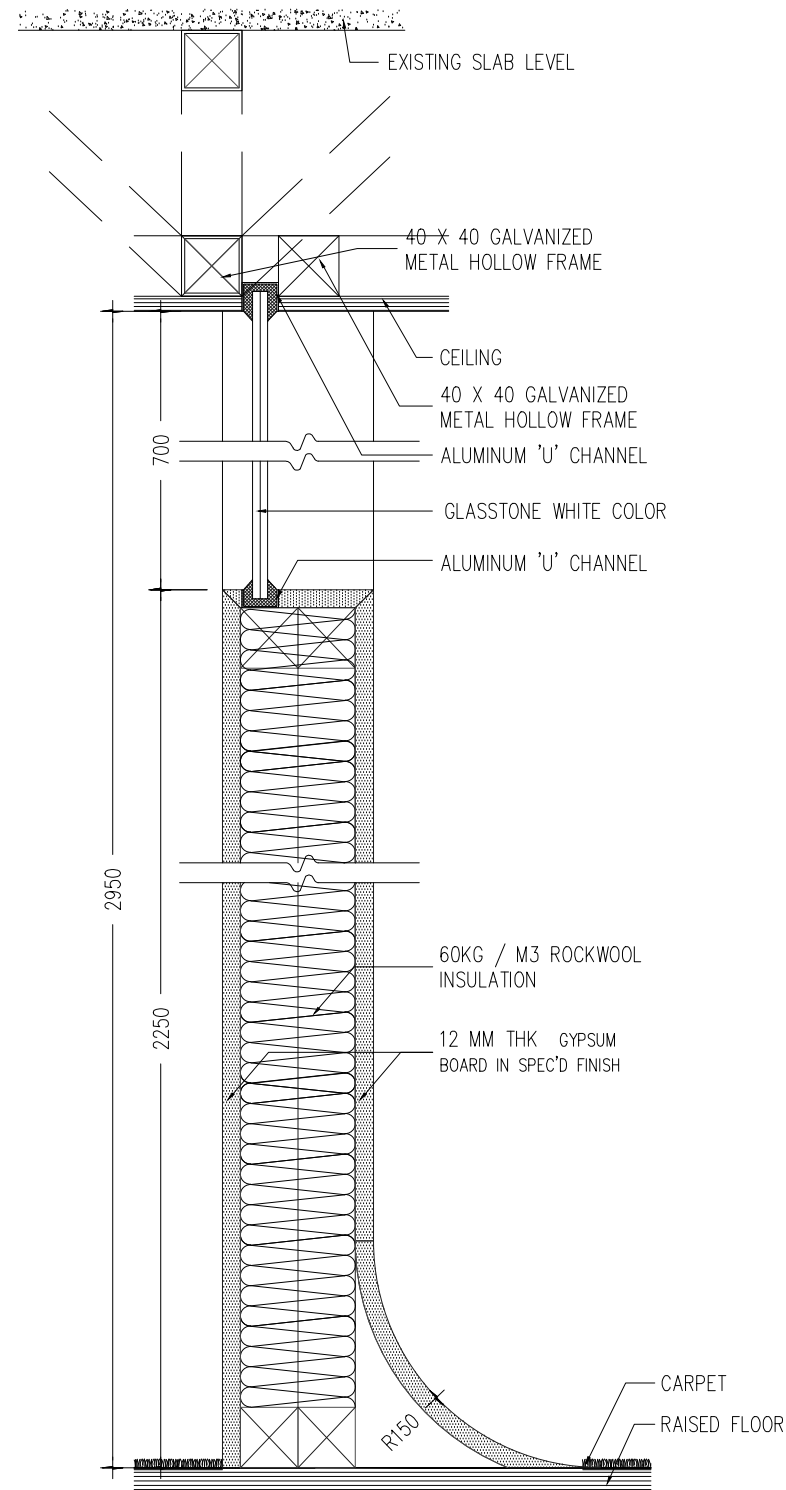

2 DETAIL PARTITION WG5
INT-302 SCALE 1:5

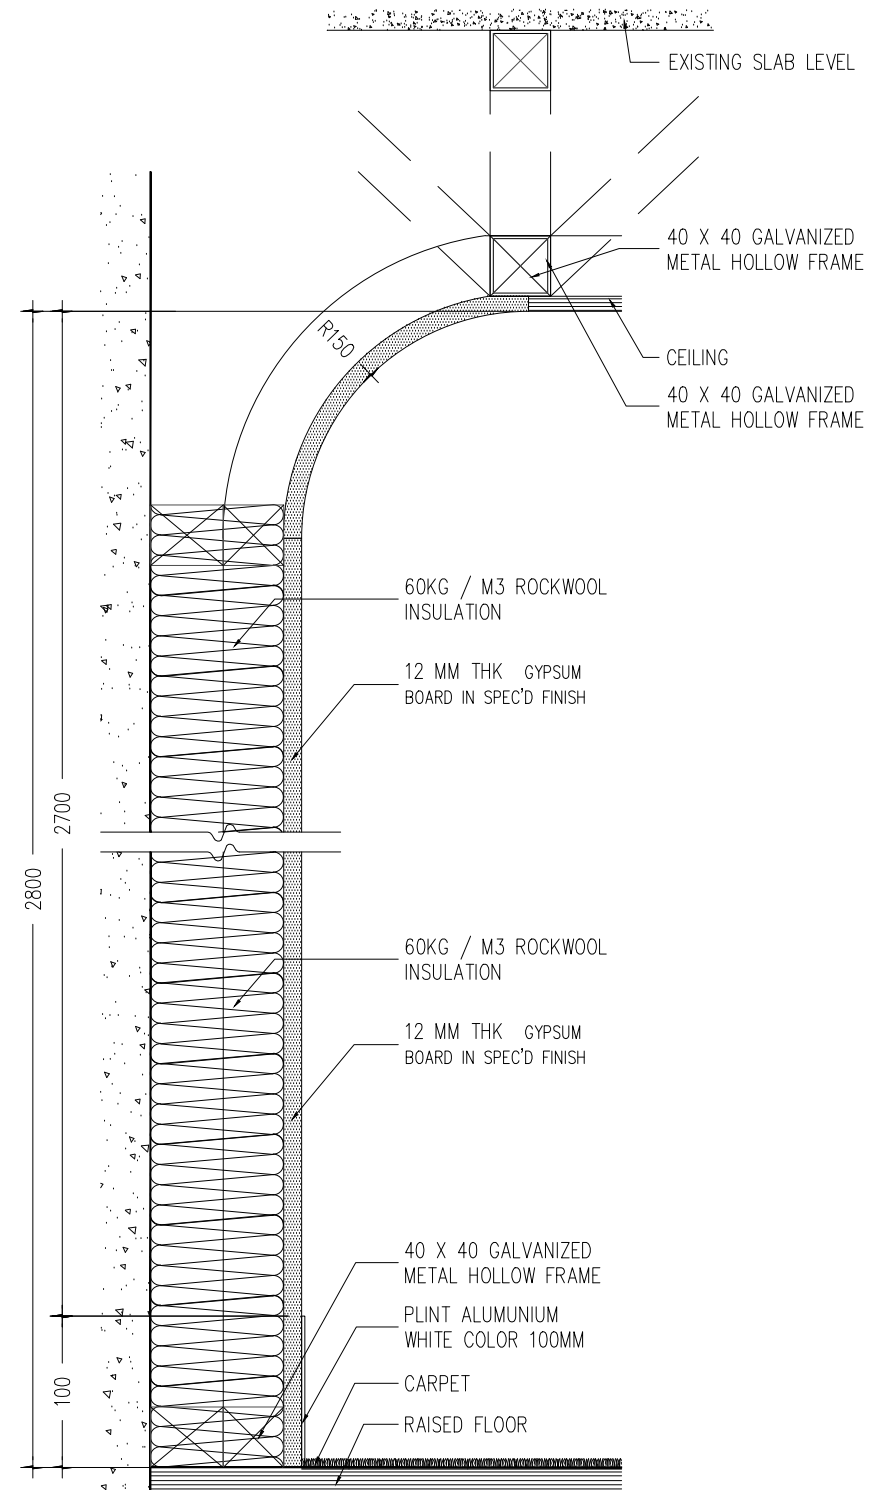

3 DETAIL PARTITION WG6
INT-302 SCALE 1:5


DEZAN
STUDIO
 Bintaro Business Centre Building
 Jl. RC Veteran No. 1-1 Bintaro
 Phone: +62 21 7357679
 Fax: +62 21 7433946
 www.dezanstudio.com
 admin@dezanstudio.com


CLIENT
UNFPA

PROJECT
UNFPA OFFICE INDONESIA

DRAWING TITLE
DETAIL PARTITION WG4, WG5 & WG6

DRAWING No.	REVISION
1908 - INT - 302	REV A
SCALE 1 : 5	CHECKED AN
DATE JANUARY 2020	DRAWN TR

NOTE :

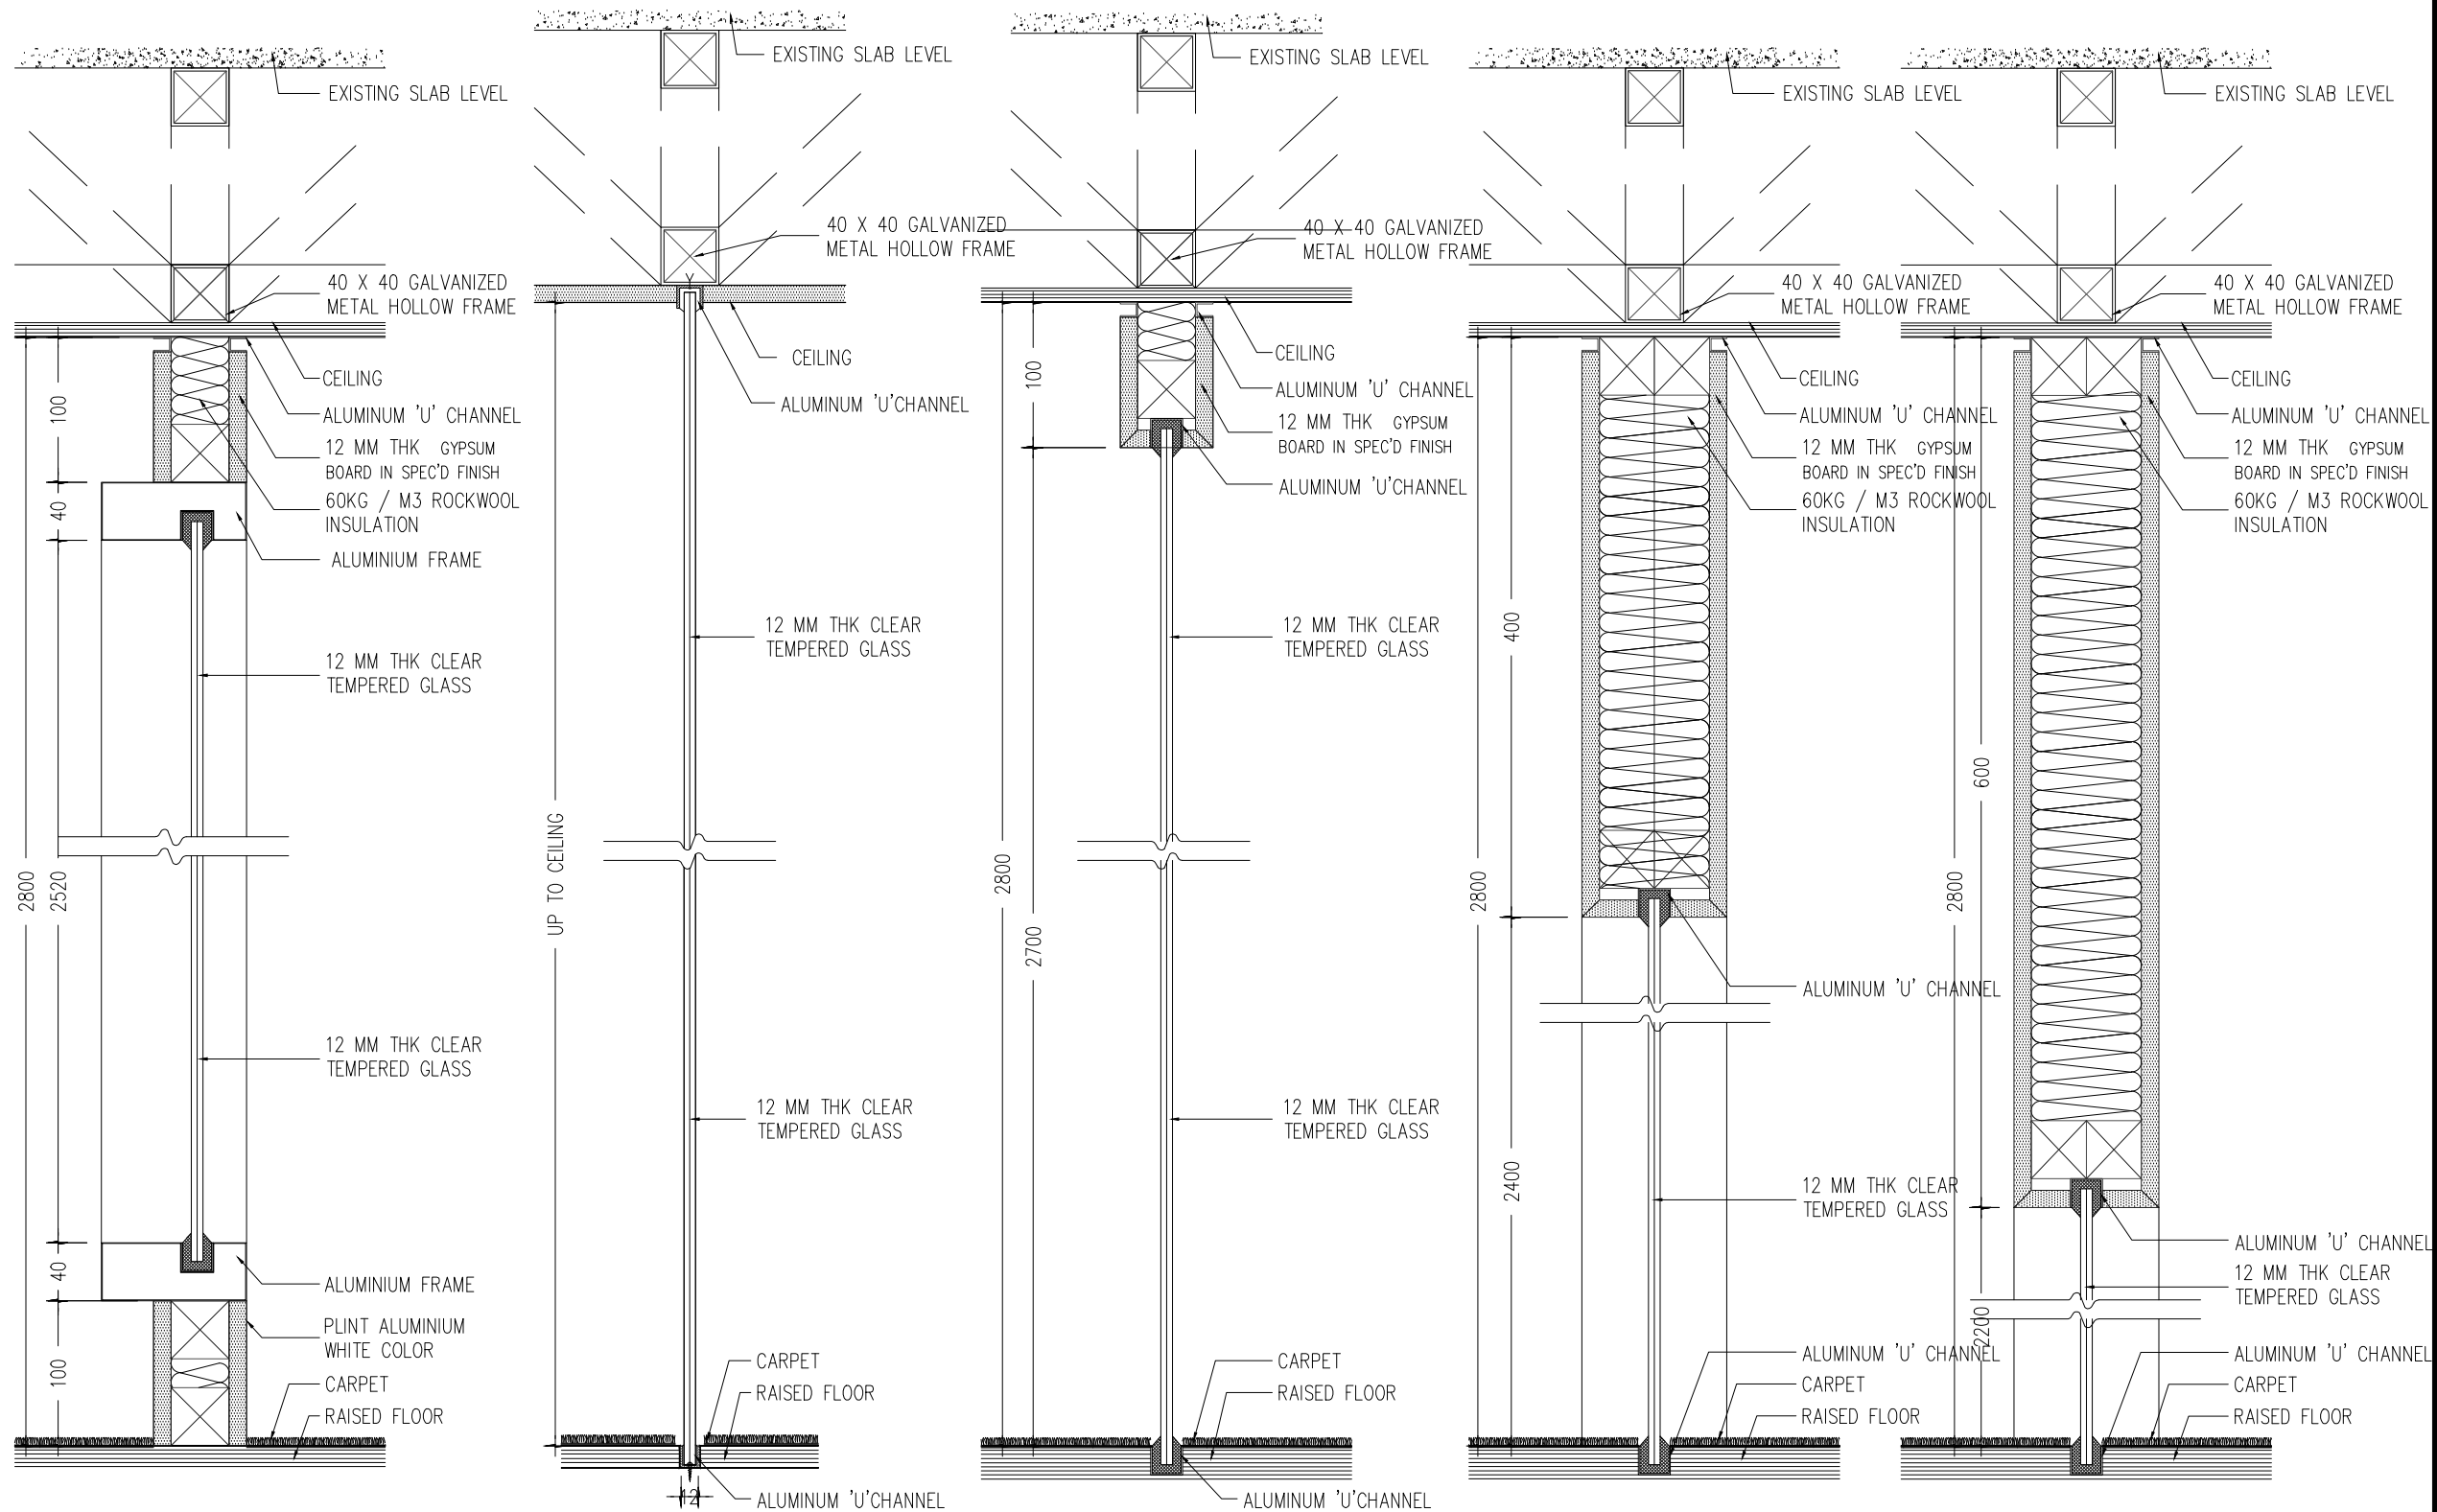

1 DETAIL PARTITION WT1
INT-303 SCALE 1:5

2 DETAIL PARTITION WT2
INT-303 SCALE 1:5

3 DETAIL PARTITION WT3
INT-303 SCALE 1:5

4 DETAIL PARTITION WT4
INT-303 SCALE 1:5

5 DETAIL PARTITION WT5
INT-303 SCALE 1:5

Bintaro Business Centre Building
Jl. RC Veteran No. 1-1 Bintaro
Phone: +62 21 7357679
Fax: +62 21 7433946
www.dezanstudio.com
admin@dezanstudio.com



CLIENT

UNFPA


PROJECT

UNFPA OFFICE INDONESIA

DRAWING TITLE
DETAIL PARTITION WT1, WT2, WT3
WT4, & WT5

DRAWING No.	REVISION
1908 - INT - 303	REV A
SCALE 1 : 5	CHECKED AN
DATE JANUARY 2020	DRAWN TR

NOTE :
 * DETAIL REFER TO INT-305 - 313






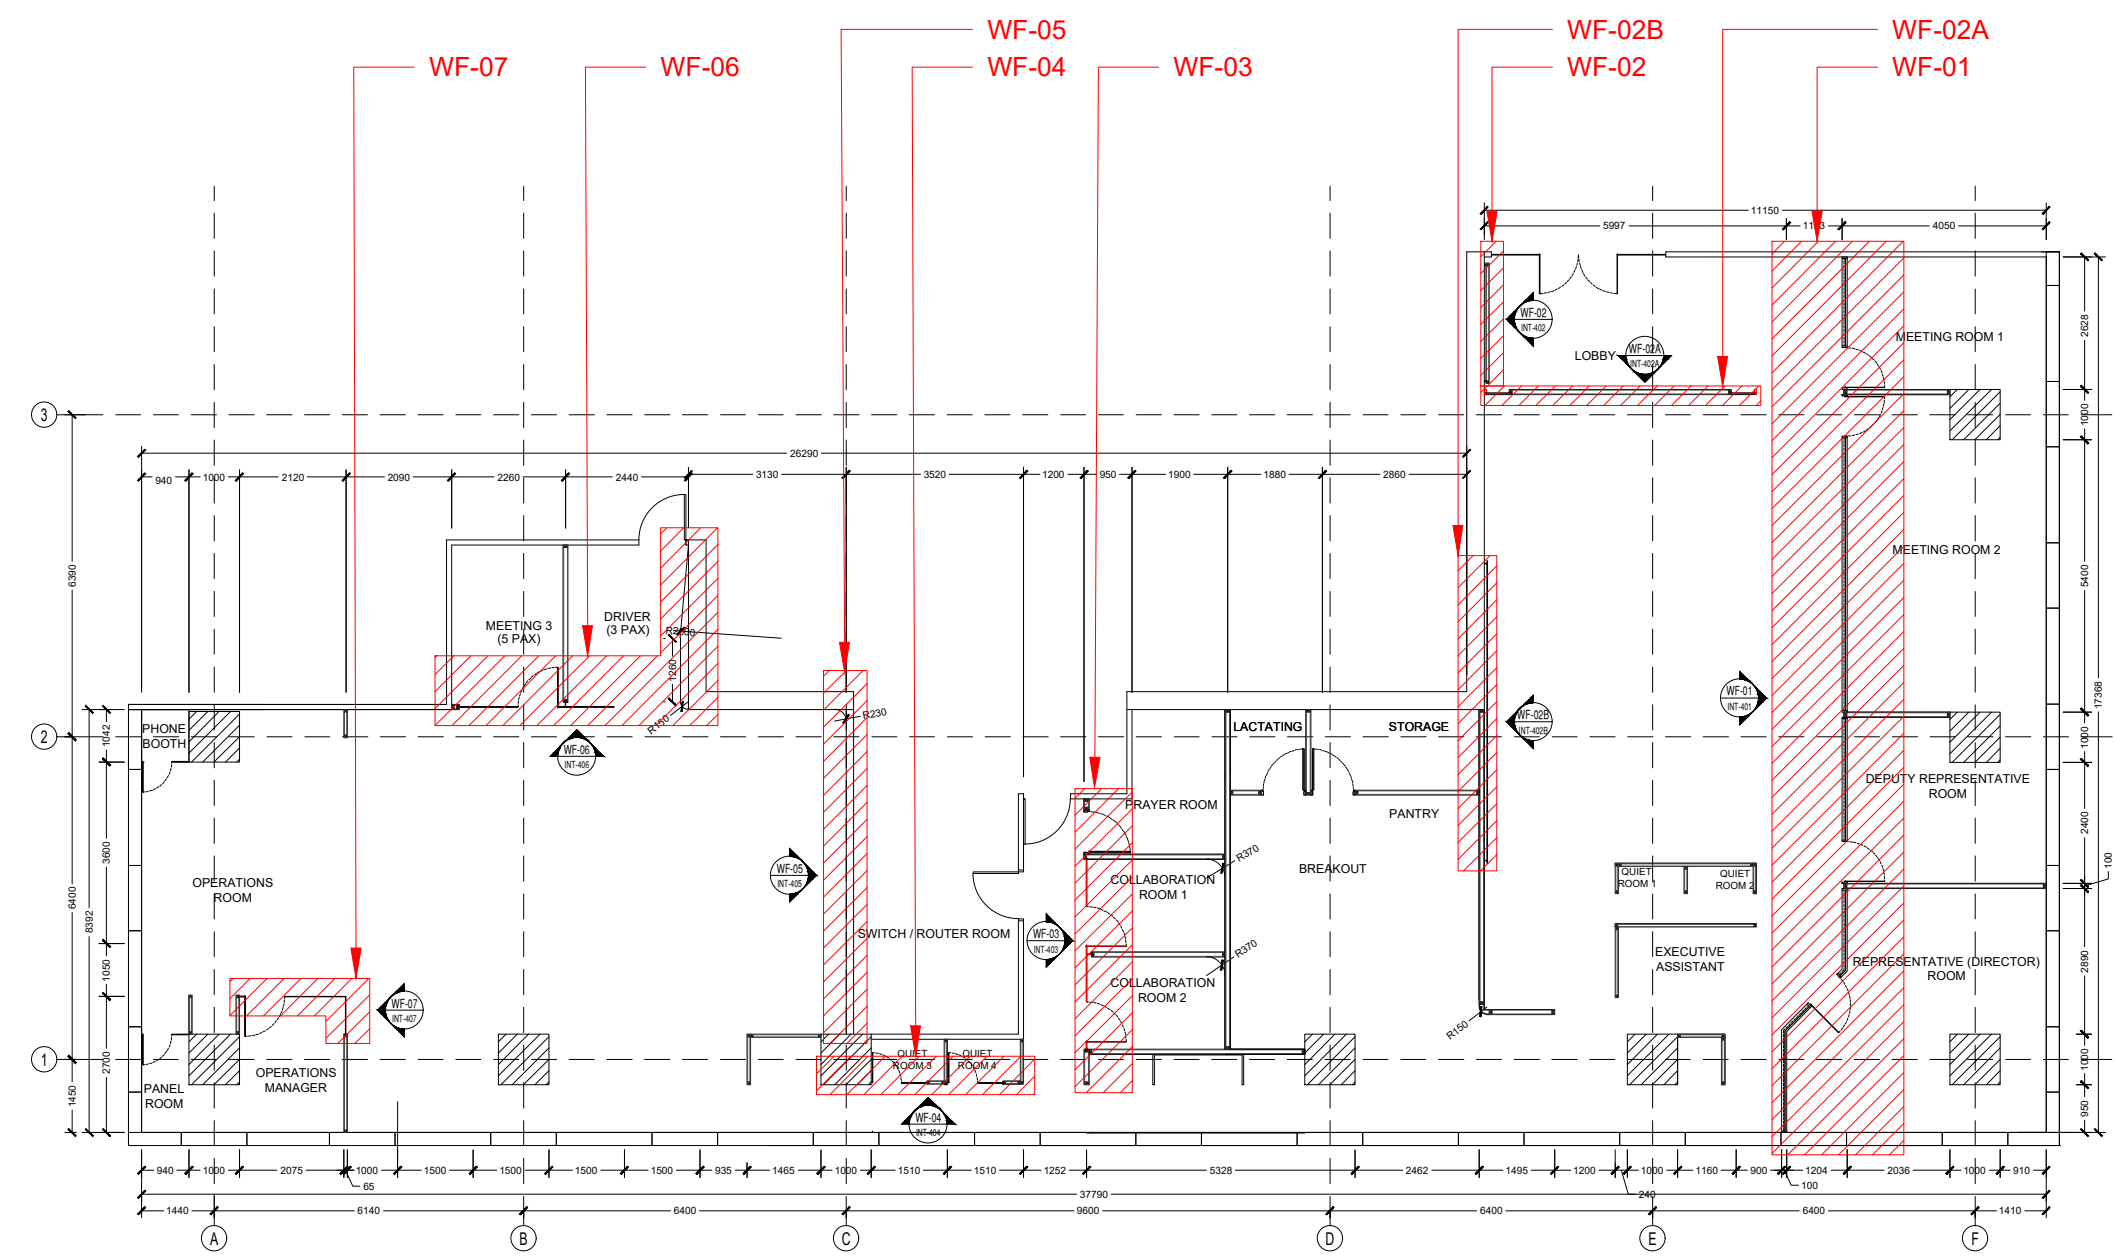


INT-103.A FEATURE WALL PLAN
 SCALE 1 : 150

DEZAN STUDIO
 Bintaro Business Centre Building
 Jl. RC Veteran No. 1-1 Bintaro
 Phone: +62 21 7357679
 Fax: +62 21 7433946
 www.dezanstudio.com
 admin@dezanstudio.com

CLIENT	
UNFPA	
PROJECT	
UNFPA OFFICE INDONESIA	
DRAWING TITLE	
KEYPLAN FEATURE WALL	
DRAWING No.	REVISION
1908 - INT - 304	REV E
SCALE 1 : 150	CHECKED AN
DATE JANUARY 2020	DRAWN TR

NOTE :

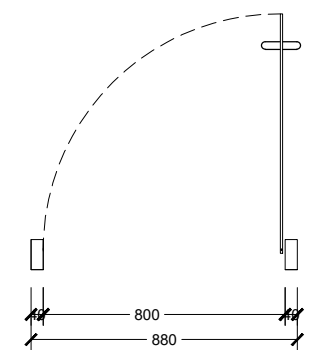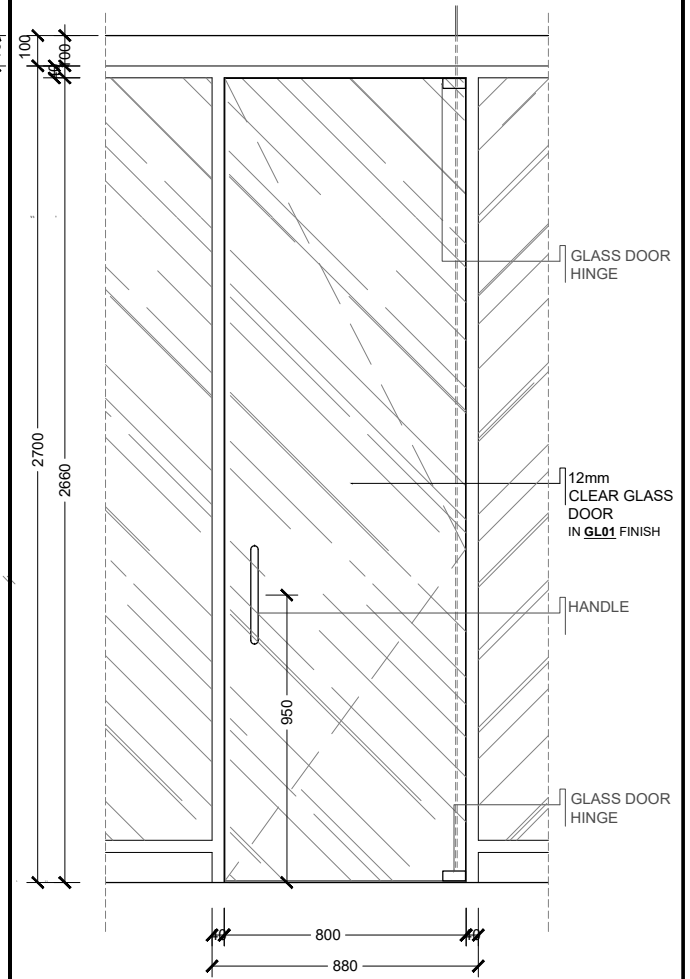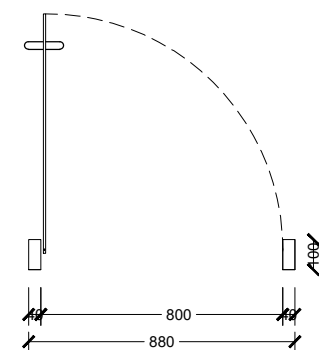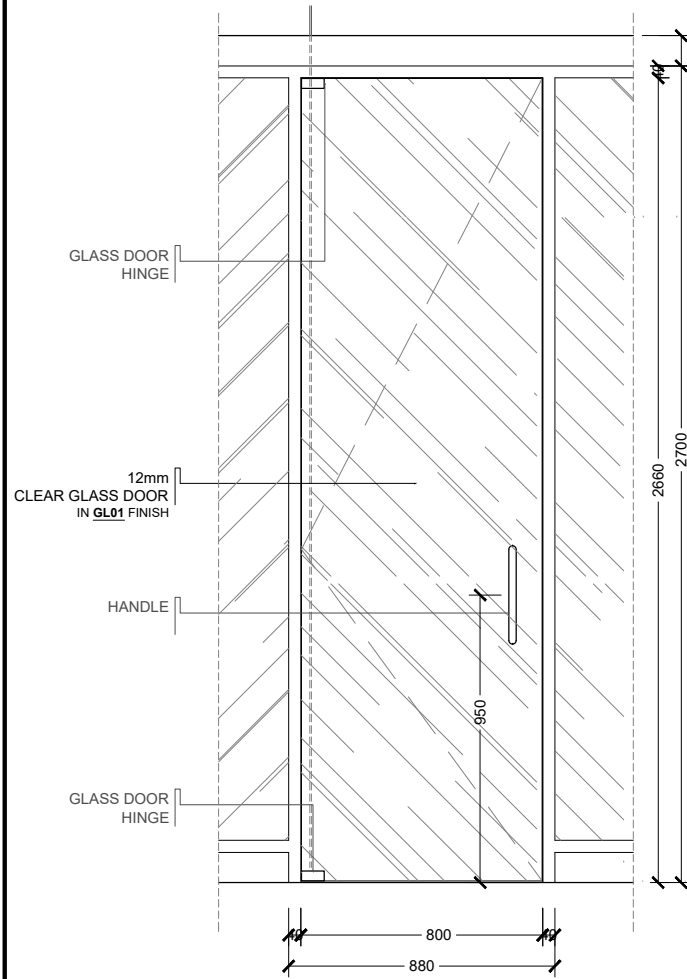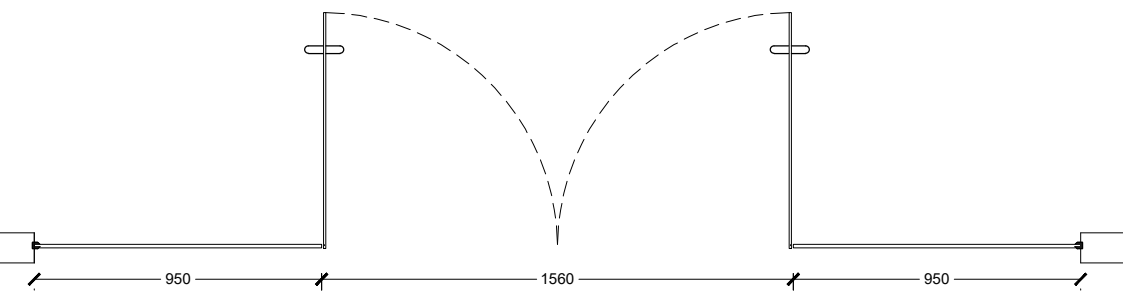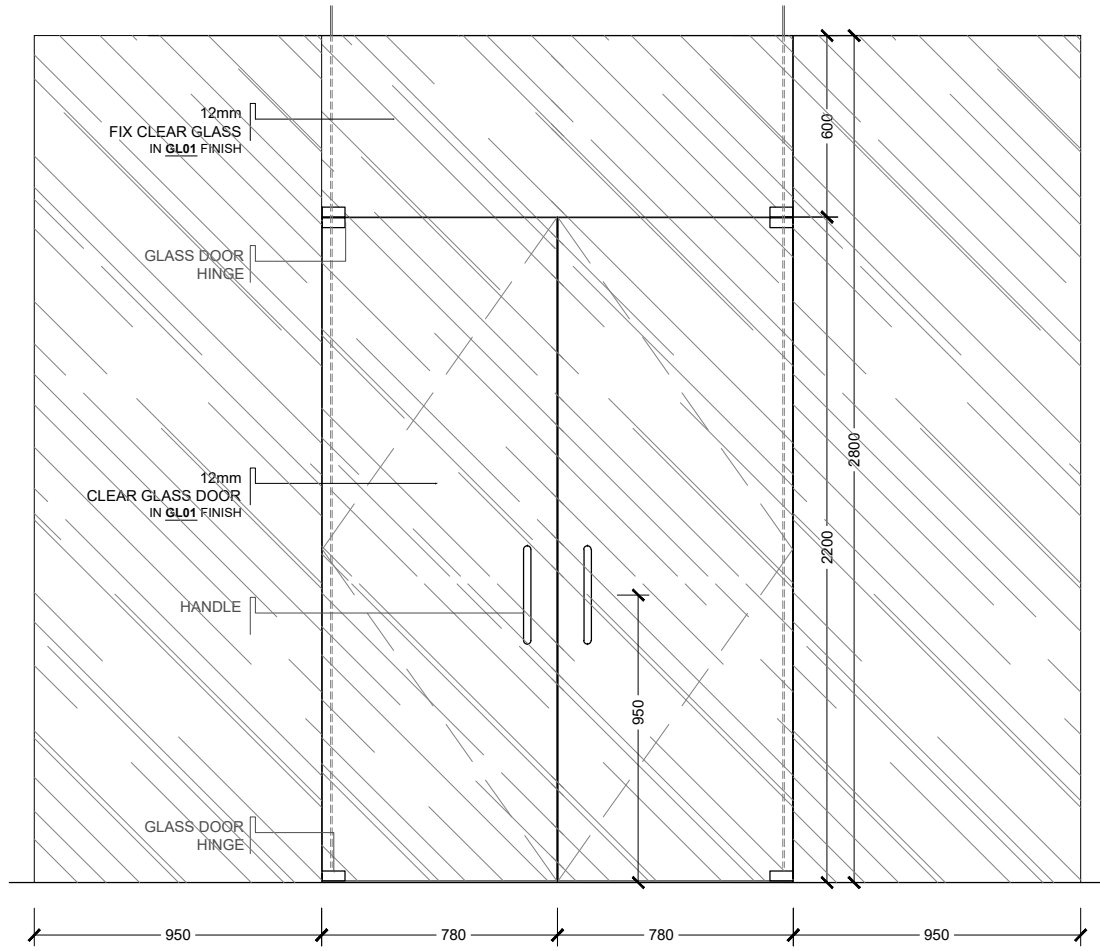

D.02		ITEM	SPECIFICATION
1 UNIT	FRAME	-	
	DOOR	TEMPERED GLASS	
	WINDOWS	-	
SCALE 1:25	HANDLE	TO BE SPECIFIED	
LOCATION:	ENGSEL	-	
	LOBBY	OTHER ACCESSORIES	SANDBLAST IN GLASS

D.03A		ITEM	SPECIFICATION
2 UNIT	FRAME	ALUMINIUM	
	DOOR	TEMPERED GLASS	
	WINDOWS	-	
SCALE 1:25	HANDLE	TO BE SPECIFIED	
LOCATION:	ENGSEL	-	
	MEETING & OPERATIONS ROOM	OTHER ACCESSORIES	SANDBLAST IN GLASS

D.03B		ITEM	SPECIFICATION
3 UNIT	FRAME	ALUMINIUM	
	DOOR	TEMPERED GLASS	
	WINDOWS	-	
SCALE 1:25	HANDLE	TO BE SPECIFIED	
LOCATION:	ENGSEL	-	
	MEETING & REPRESENTATIVE	OTHER ACCESSORIES	SANDBLAST IN GLASS


 Bintaro Business Centre Building
 Jl. RC Veteran No. 1-1 Bintaro
 Phone: +62 21 7357679
 Fax: +62 21 7433946
 www.dezanstudio.com
 admin@dezanstudio.com

CLIENT

UNFPA

PROJECT

UNFPA OFFICE INDONESIA









DRAWING TITLE

DOOR DETAIL D.02, D.03A & D.03B

DRAWING No.	REVISION
1908 - INT - 401	REV A

SCALE	CHECKED	AN
1 : 25		
DATE	DRAWN	TR
JANUARY 2020		

NOTE :

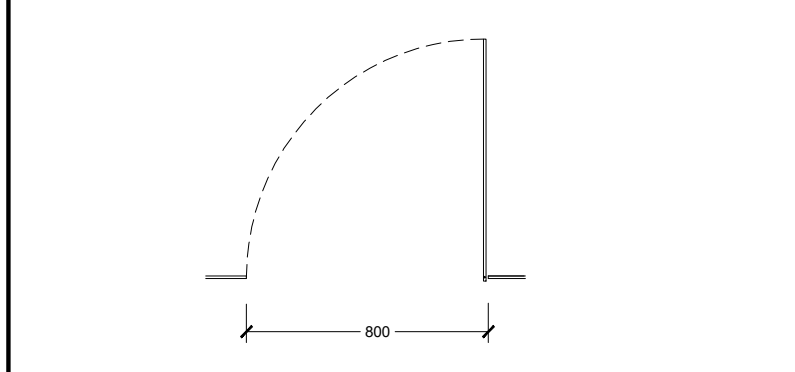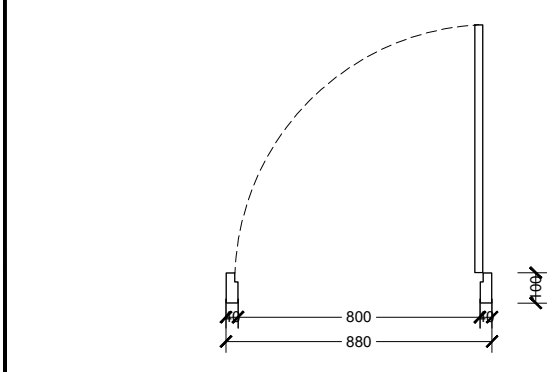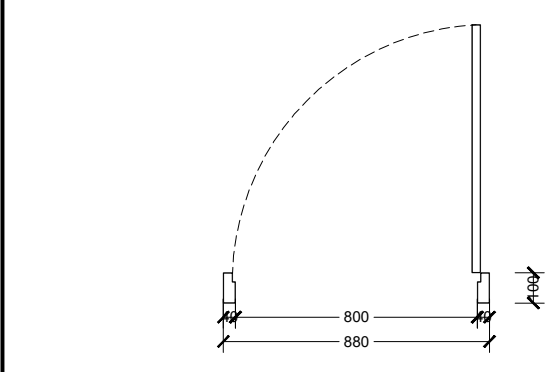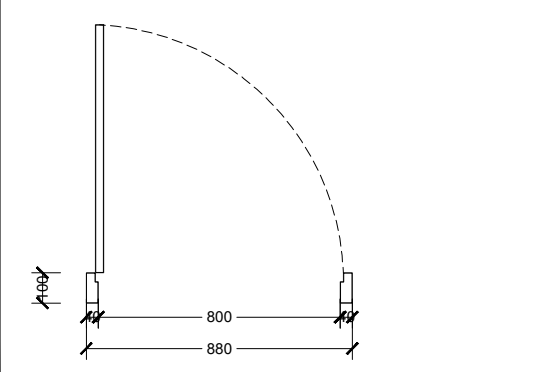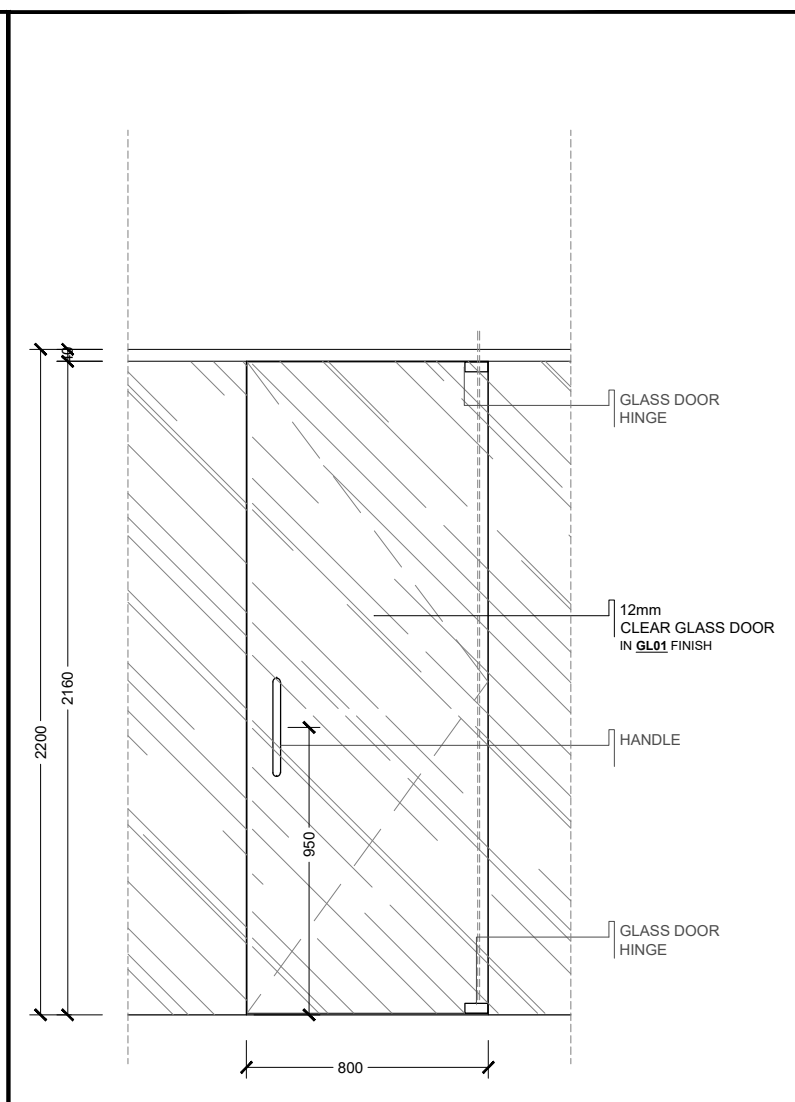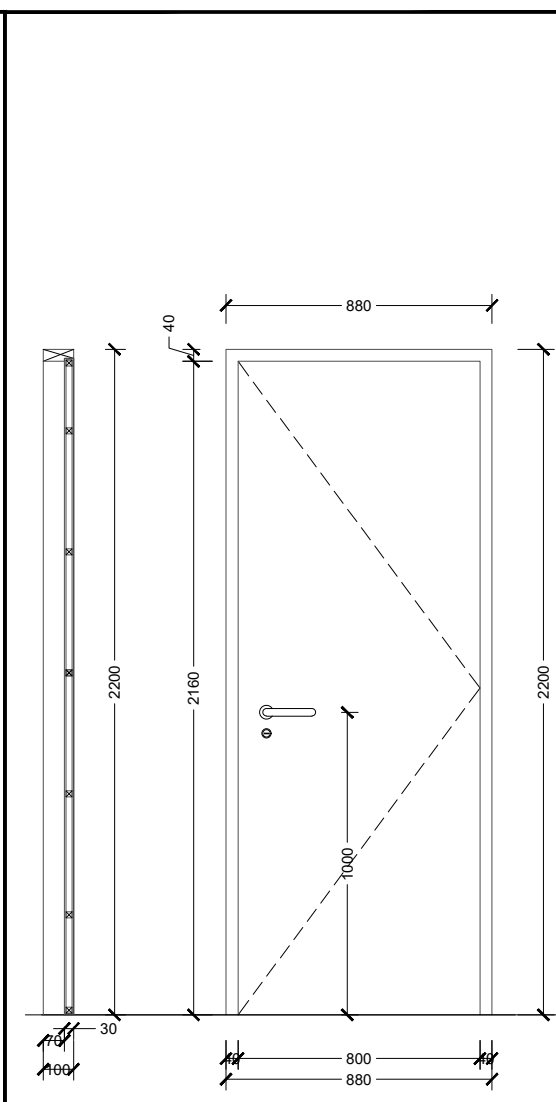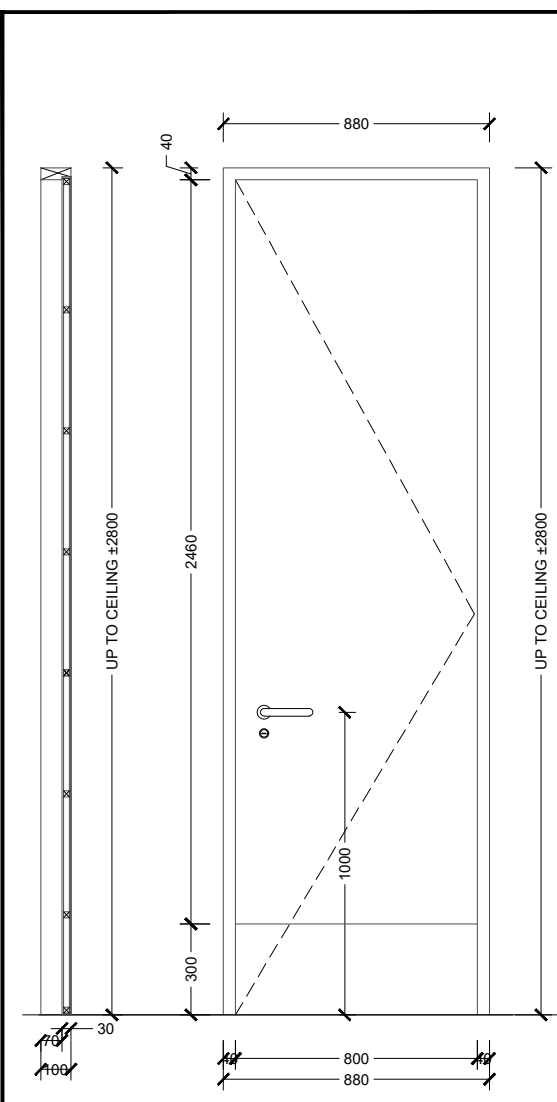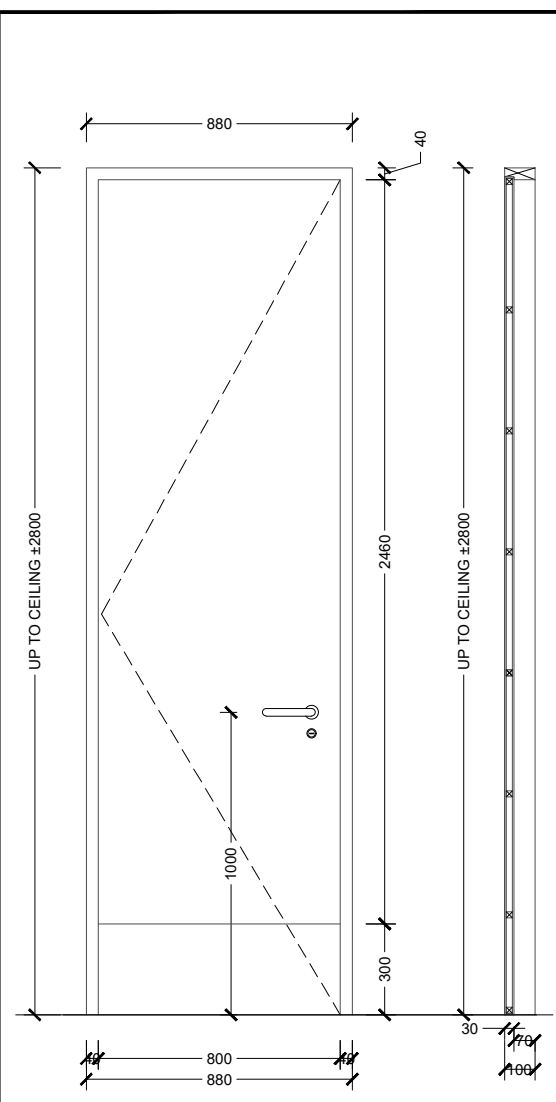

Bintaro Business Centre Building
 Jl. RC Veteran No. 1-1 Bintaro
 Phone: +62 21 7357679
 Fax: +62 21 7433946
 www.dezanstudio.com
 admin@dezanstudio.com

CLIENT

UNFPA

PROJECT

UNFPA OFFICE INDONESIA

DRAWING TITLE

DOOR DETAIL D.04A, D.04B, D.04C & D.05

DRAWING No. REVISION

1908 - INT - 402 REV A

SCALE 1 : 25 CHECKED AN

DATE JANUARY 2020 DRAWN TR









D.04A 1 UNIT	ITEM	SPECIFICATION
	FRAME	ALUMINIUM FRAME
SCALE 1:25	DOOR	PLYWOOD FIN.HPL WHITE COLOR
	WINDOWS	-
LOCATION: STORAGE	HANDLE	TO BE SPECIFIED
	ENGSEL	-
	OTHER ACCESSORIES	-

D.04B 1 UNIT	ITEM	SPECIFICATION
	FRAME	ALUMINIUM FRAME
SCALE 1:25	DOOR	PLYWOOD FIN.HPL WHITE COLOR
	WINDOWS	-
LOCATION: LACTATING	HANDLE	TO BE SPECIFIED
	ENGSEL	-
	OTHER ACCESSORIES	-

D.04C 1 UNIT	ITEM	SPECIFICATION
	FRAME	ALUMINIUM FRAME
SCALE 1:25	DOOR	PLYWOOD FIN.HPL WHITE COLOR
	WINDOWS	-
LOCATION: PRAYER ROOM	HANDLE	TO BE SPECIFIED
	ENGSEL	-
	OTHER ACCESSORIES	-

D.05 2 UNIT	ITEM	SPECIFICATION
	FRAME	-
SCALE 1:25	DOOR	TEMPERED GLASS
	WINDOWS	-
LOCATION: COLLABORATION ROOM	HANDLE	TO BE SPECIFIED
	ENGSEL	-
	OTHER ACCESSORIES	-

NOTE :

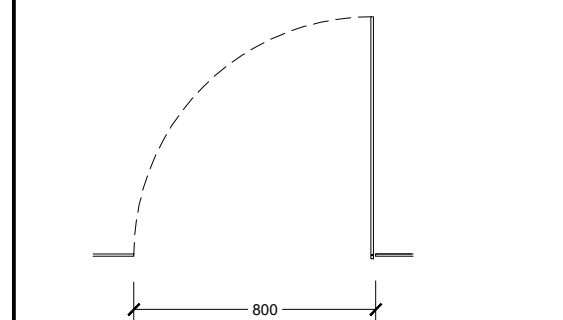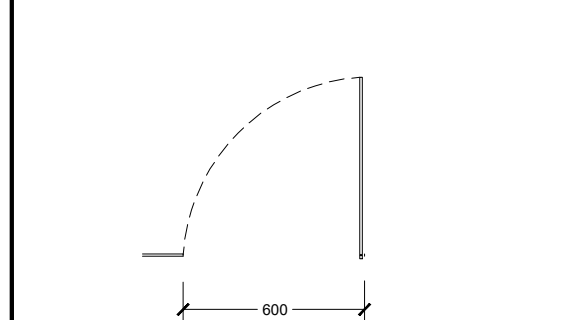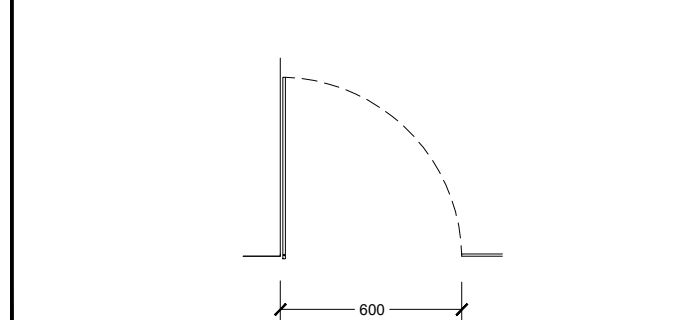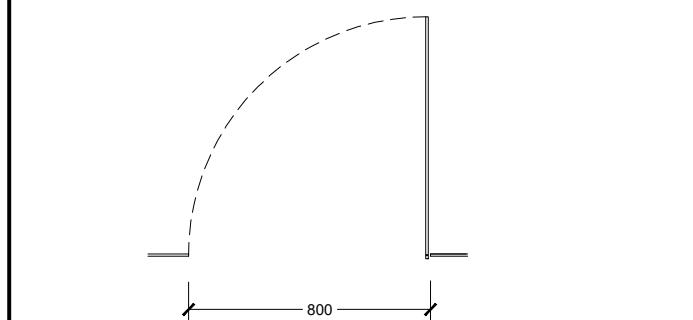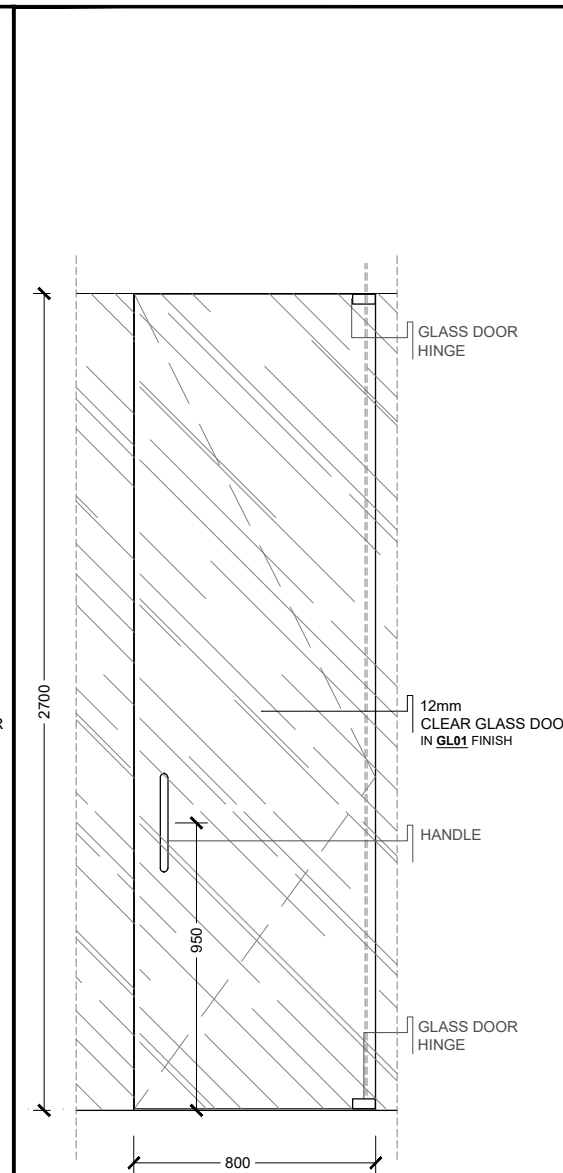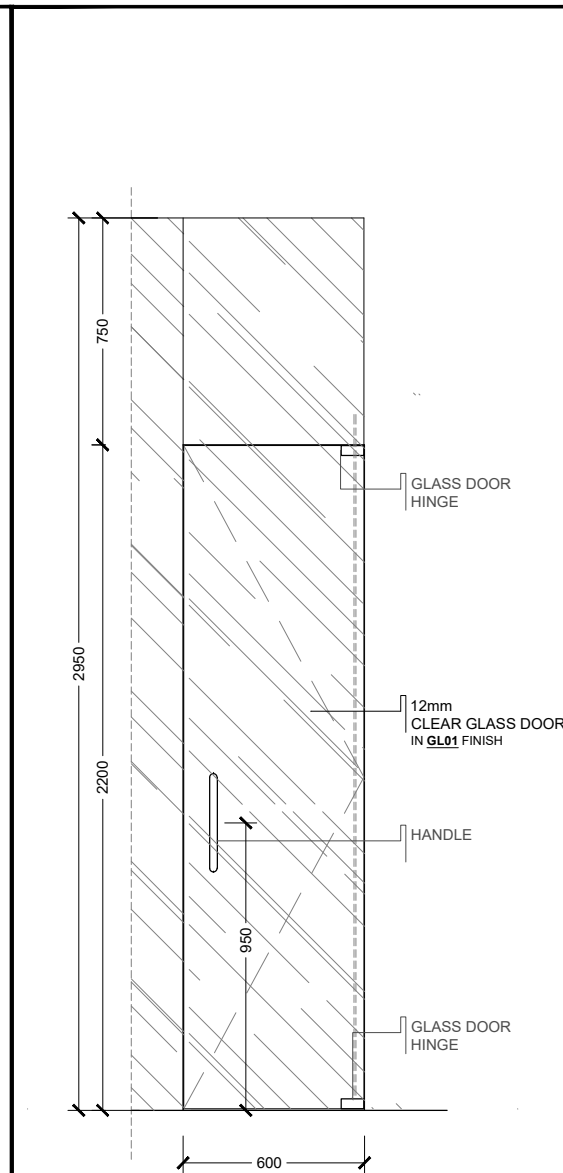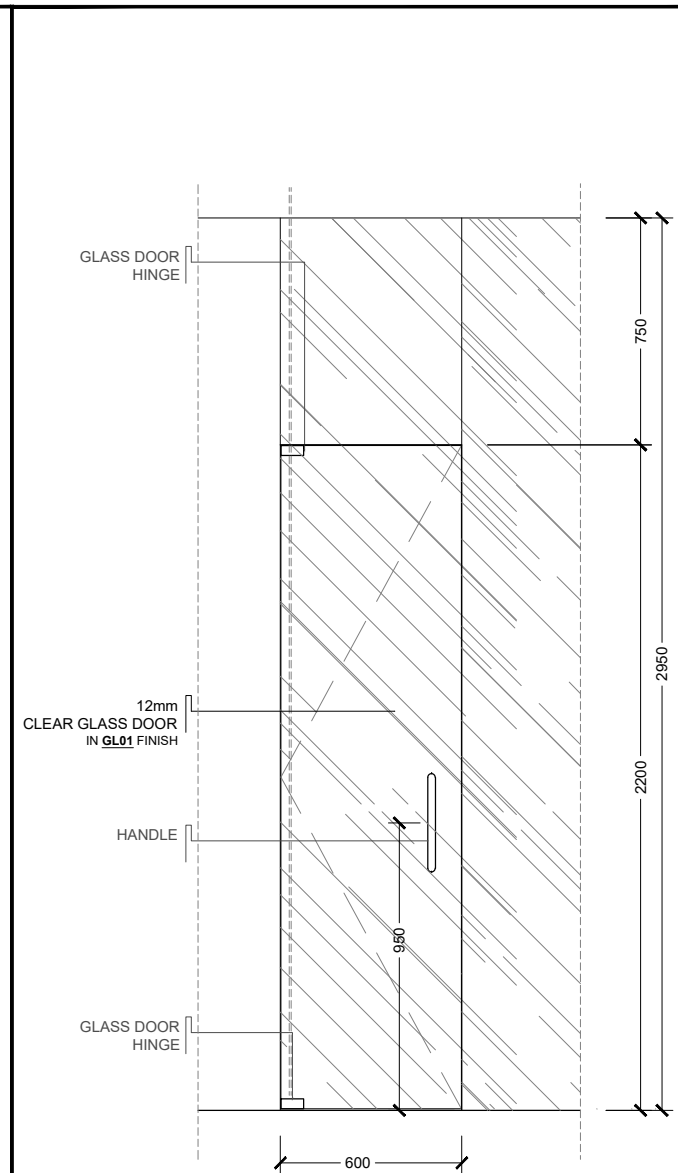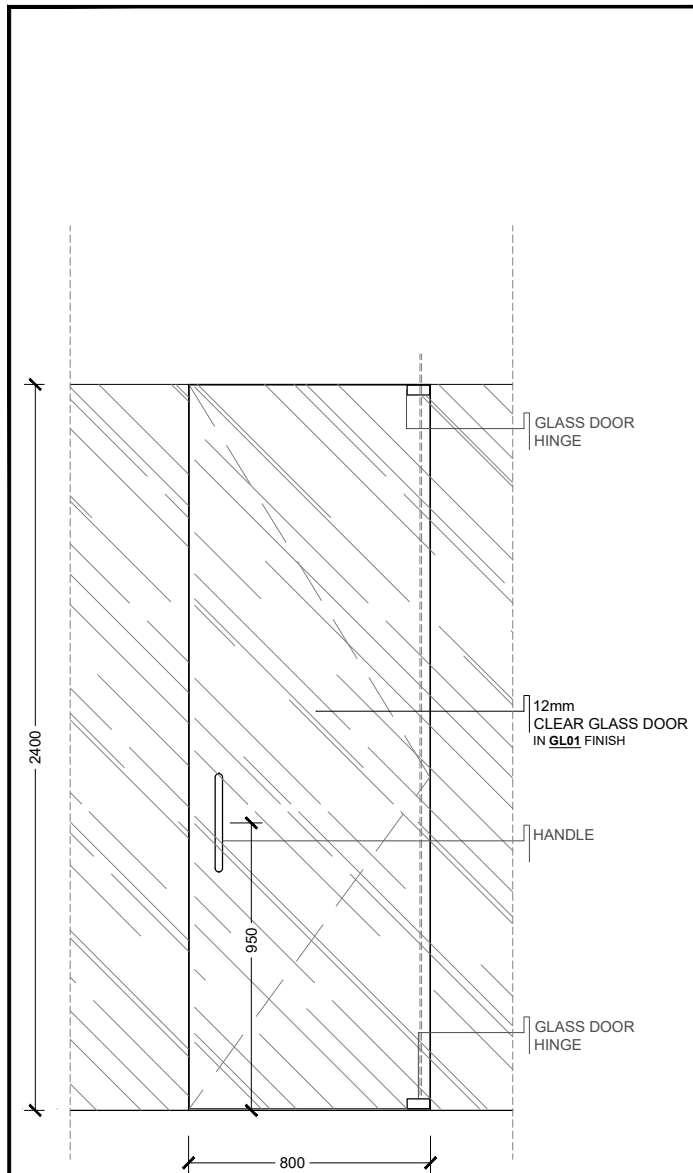

D.06 1 UNIT	ITEM	SPECIFICATION
	FRAME	-
SCALE 1:25	DOOR	TEMPERED GLASS
	WINDOWS	-
LOCATION: MEETING 3	HANDLE	TO BE SPECIFIED
	ENGSEL	-
	OTHER ACCESSORIES	

D.07 2 UNIT	ITEM	SPECIFICATION
	FRAME	-
SCALE 1:25	DOOR	TEMPERED GLASS
	WINDOWS	-
LOCATION: QUIET ROOM 3 & 4	HANDLE	TO BE SPECIFIED
	ENGSEL	-
	OTHER ACCESSORIES	

D.08 2 UNIT	ITEM	SPECIFICATION
	FRAME	-
SCALE 1:25	DOOR	TEMPERED GLASS
	WINDOWS	-
LOCATION: PHONE BOOTH & PANEL ROOM	HANDLE	TO BE SPECIFIED
	ENGSEL	-
	OTHER ACCESSORIES	SANDBLAST IN GLASS

D.09 1 UNIT	ITEM	SPECIFICATION
	FRAME	-
SCALE 1:25	DOOR	TEMPERED GLASS
	WINDOWS	-
LOCATION: OPERATIONS MANAGER	HANDLE	TO BE SPECIFIED
	ENGSEL	-
	OTHER ACCESSORIES	SANDBLAST IN GLASS


 Bintaro Business Centre Building
 Jl. RC Veteran No. 1-1 Bintaro
 Phone: +62 21 7357679
 Fax: +62 21 7433946
 www.dezanstudio.com
 admin@dezanstudio.com

CLIENT

UNFPA




PROJECT

UNFPA OFFICE INDONESIA


DRAWING TITLE

DOOR DETAIL D.06, D.07, D.08 & D.09

DRAWING No.	REVISION
1908 - INT - 403	REV A
SCALE 1 : 25	CHECKED AN
DATE JANUARY 2020	DRAWN TR

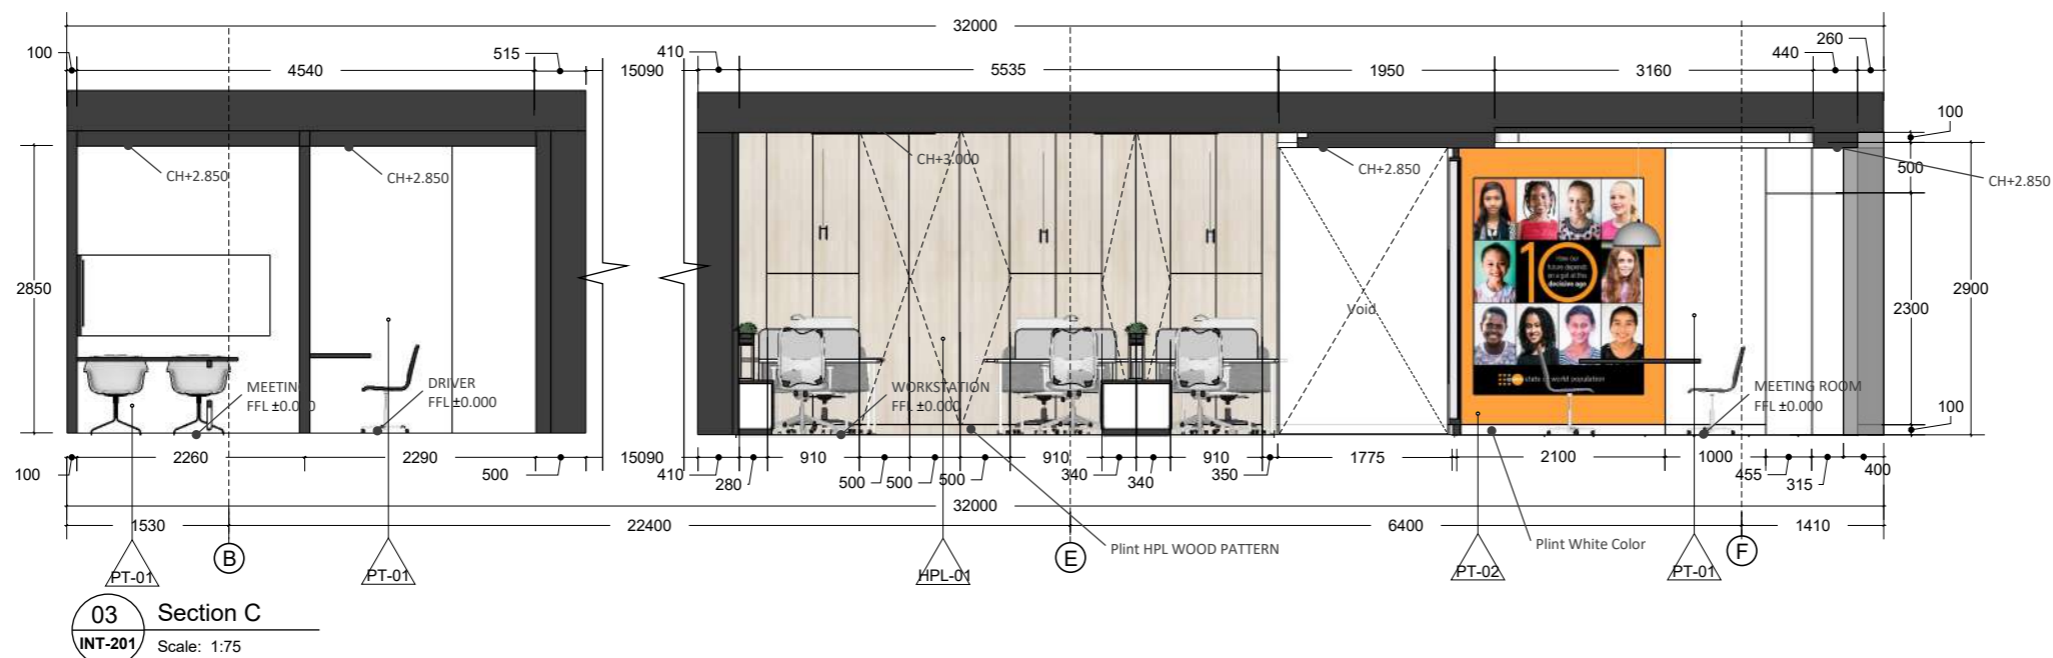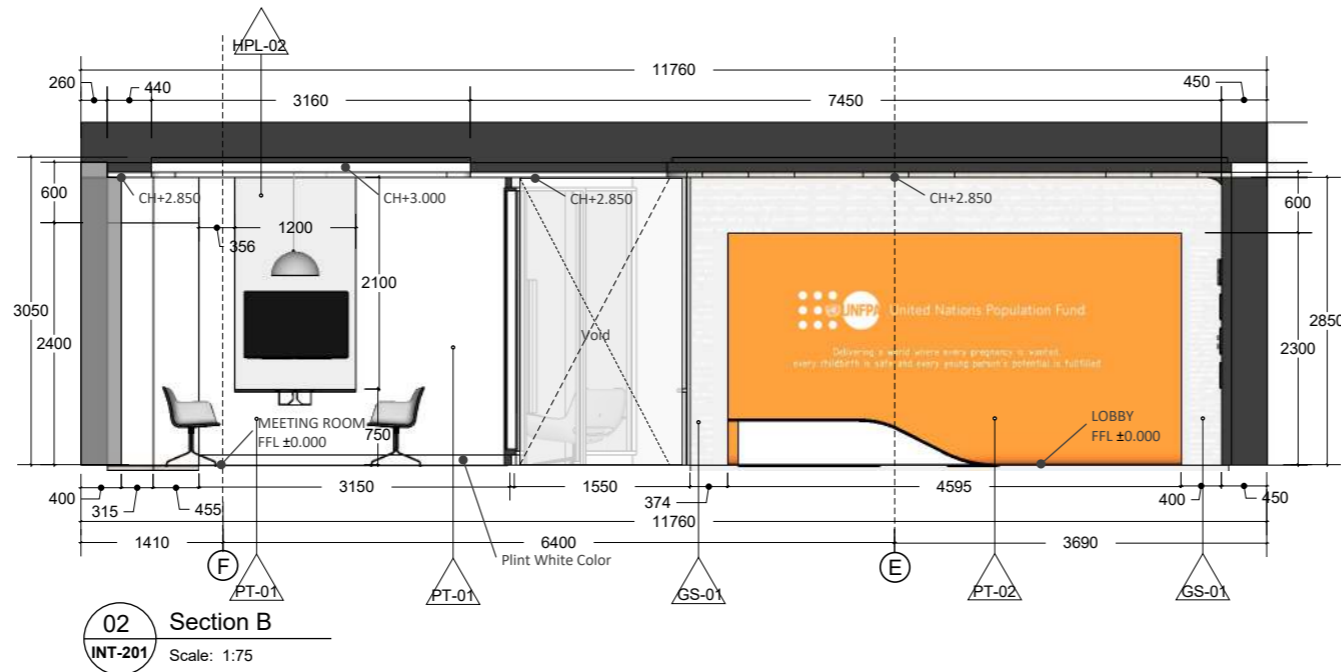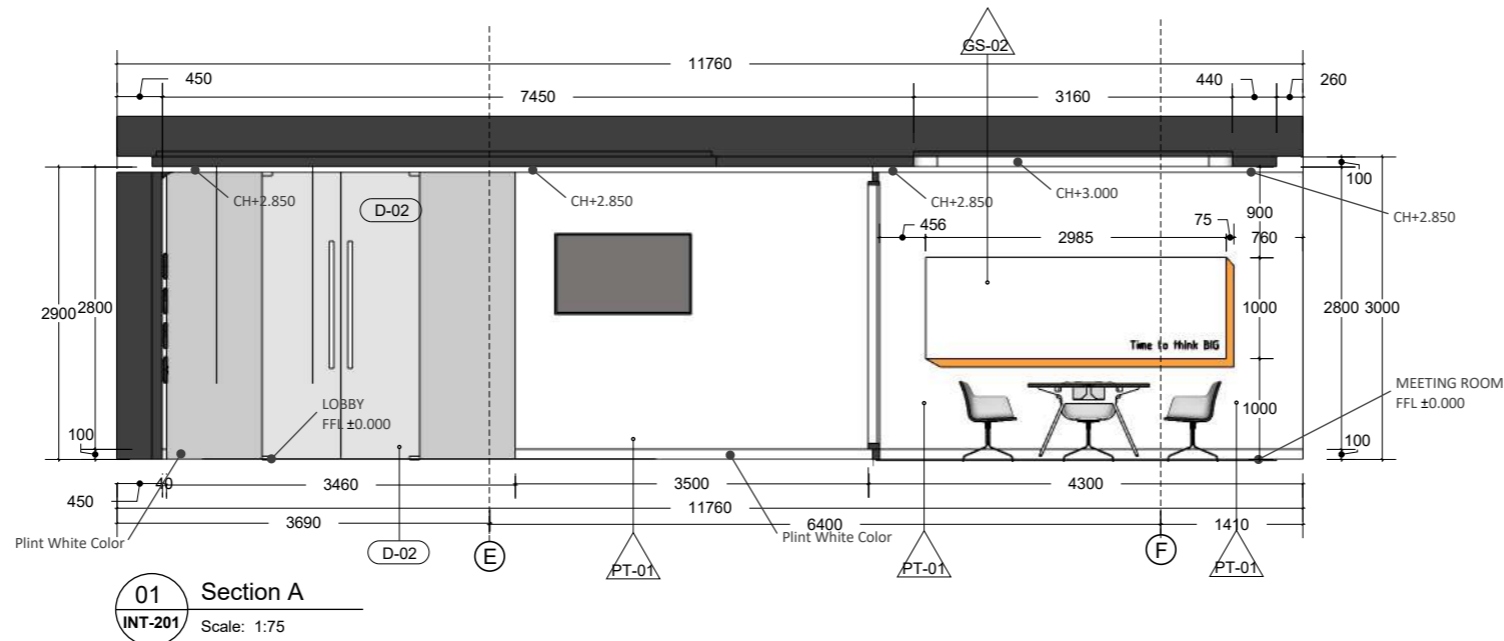

NOTE :

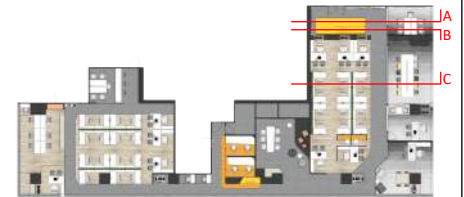


KEYPLAN


- : EXISTING MATERIAL
 - : WALLPAIN WHITE COLOR
ex. DULUX TYPE COTTON FANTASY
 - : WALLPAIN ORANGE COLOR
ex. DULUX TYPE MARIGOLD BLOSSOM
 - : WALLPAIN LIGHT ORANGE
ex. DULUX TYPE TOPAZ SPARKLE
 - : HPL WOOD PATTERN
ex. TACO TH 849 TM ASH AFROMOSIA TIMBER
 - : HPL WHITE COLOR
ex. TACO CHALK TH 040 AA
 - : HPL ORANGE COLOR
ex. TACO CLASSIC ORANGE
 - : 12MM CLEAR TEMPERED GLASS
 - : 12MM CLEAR TEMPERED GLASS ORANGE COLOR
 - : 12MM WHITE GLASS STONE
 - : PADED WALL WITH GREY FABRIC FINISH
 - : PADED WALL WITH ORANGE FABRIC FINISH
- ALL WOOD MATERIAL COVER FIRE PROOF & TERMITE TREATMENT

DEZAN STUDIO
Bintaro Business Centre Building
Jl. RC Veteran No. 1-1 Bintaro
Phone: +62 21 7357679
Fax: +62 21 7433946
www.dezanstudio.com
admin@dezanstudio.com

CLIENT	
UNFPA	
PROJECT	
UNFPA OFFICE	
DRAWING TITLE	
SECTION A SECTION B SECTION C	
DRAWING No.	REVISION
INT-201	REV A
SCALE 1:75 @A3	CHECKED AN
DATE 05 Februari, 2020	DRAWN TR

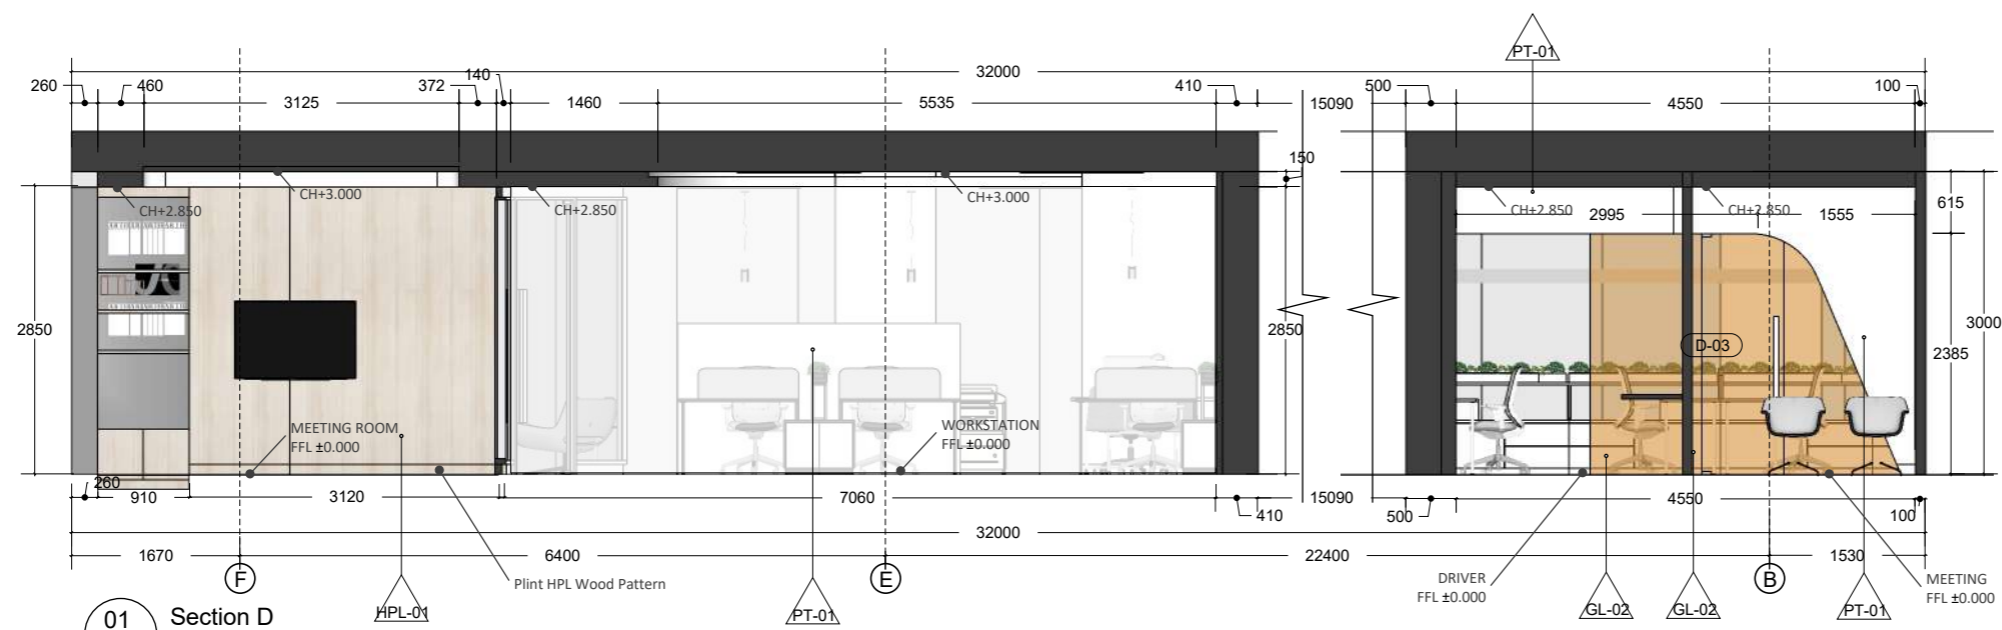

01 Section D
INT-202 Scale: 1:75

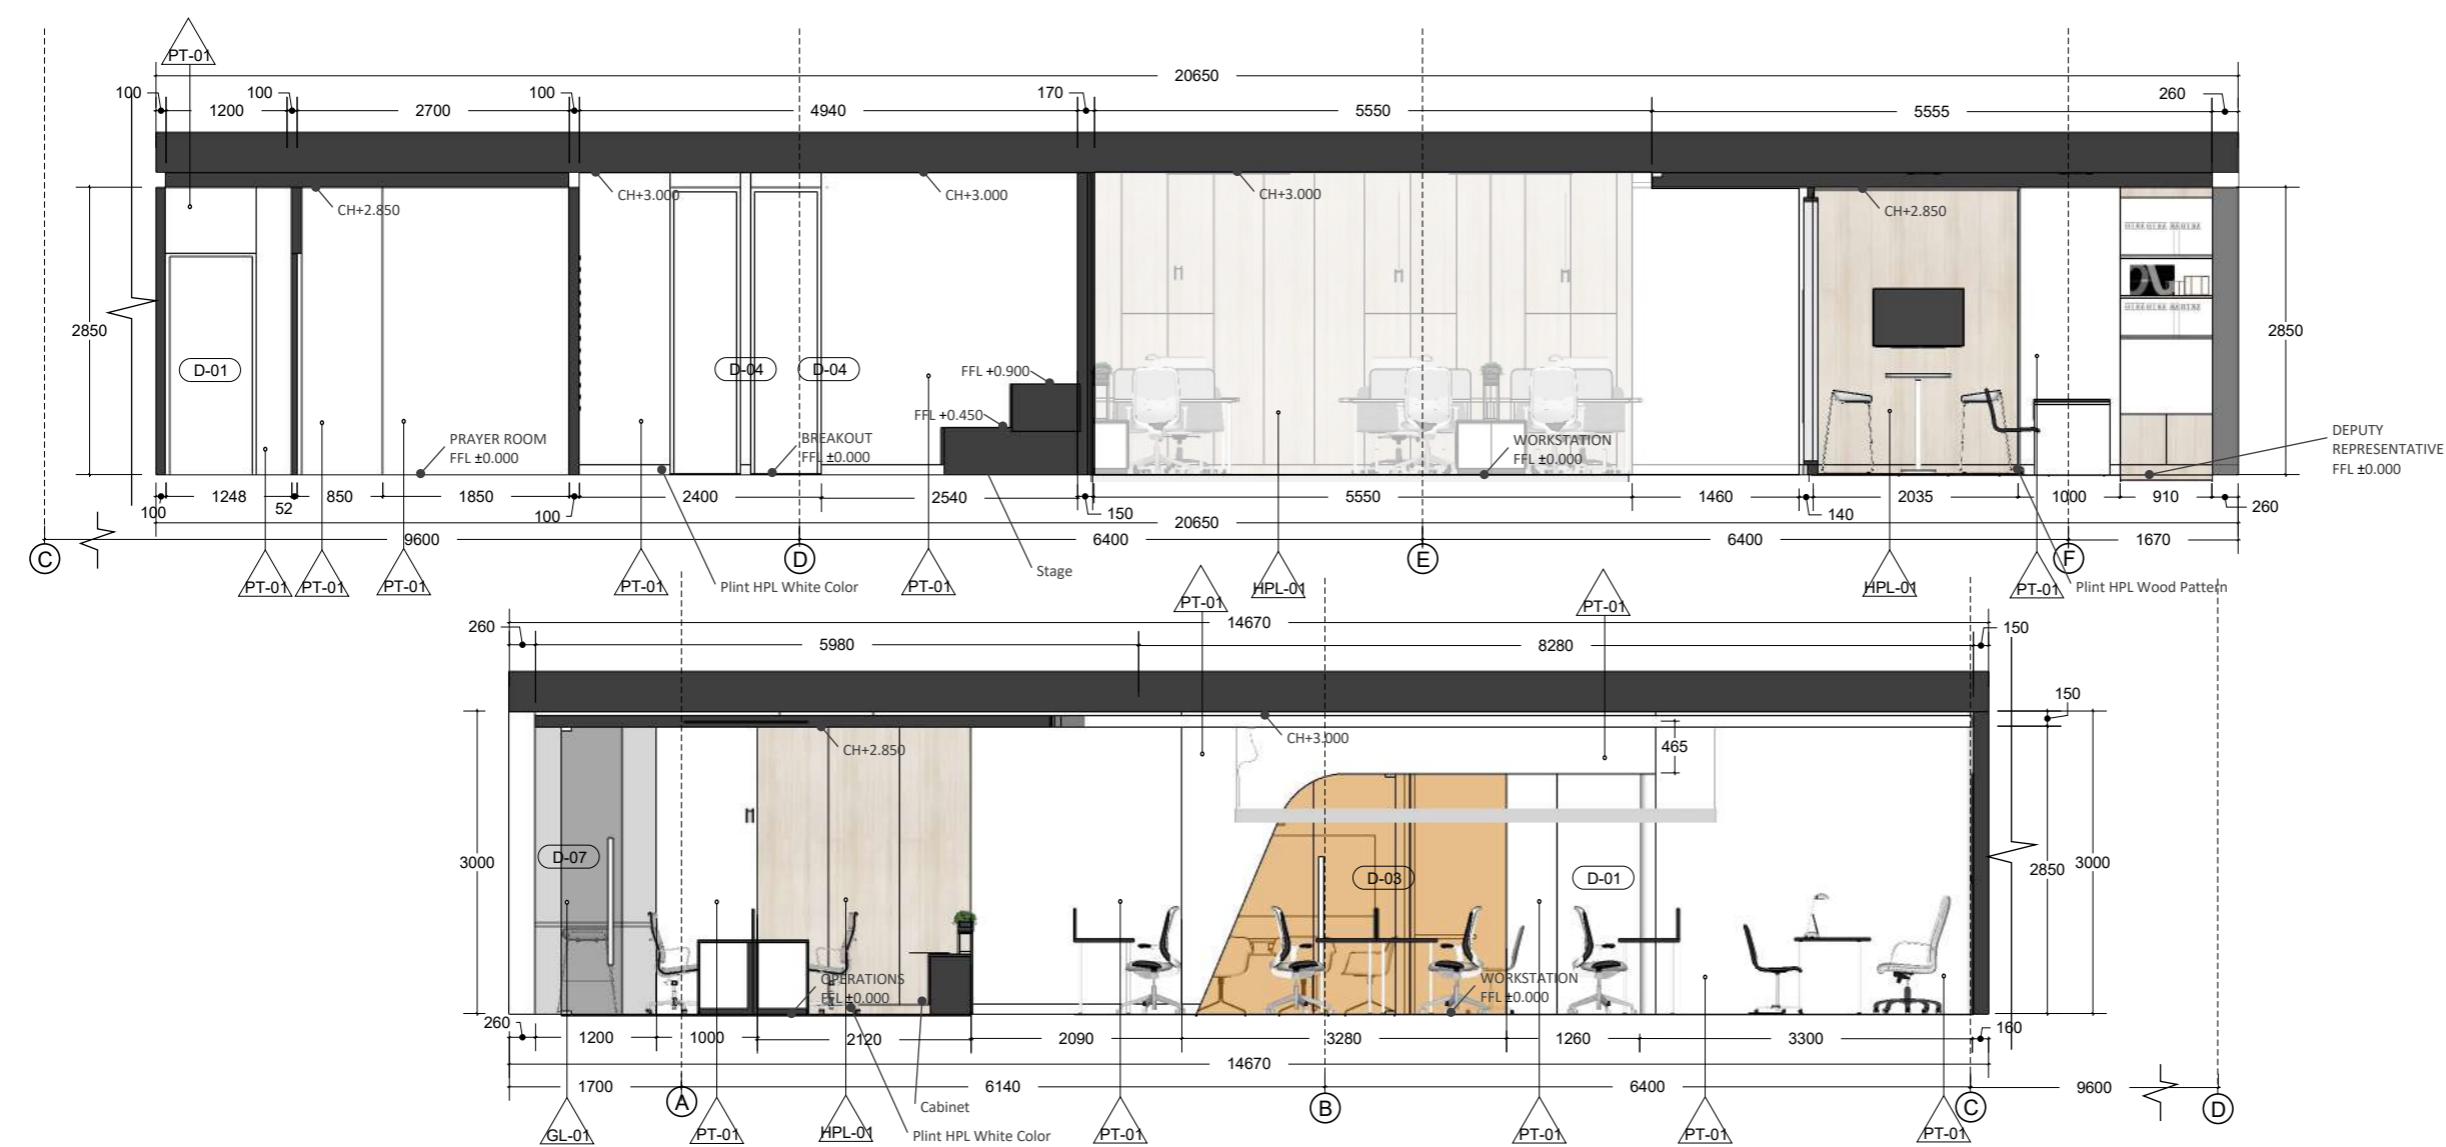

02 Section E
INT-202 Scale: 1:75


- NOTE :
-
- KEYPLAN
- △WFX : EXISTING MATERIAL
 - △PT-01 : WALLPAPER WHITE COLOR
ex. DULUX TYPE COTTON FANTASY
 - △PT-02 : WALLPAPER ORANGE COLOR
ex. DULUX TYPE MARIGOLD BLOSSOM
 - △PT-03 : WALLPAPER LIGHT ORANGE
ex. DULUX TYPE TOPAZ SPARKLE
 - △HPL-01 : HPL WOOD PATTERN
ex. TACO TH 849 TM ASH AFROMOSIA TIMBER
 - △HPL-02 : HPL WHITE COLOR
ex. TACO CHALK TH 040 AA
 - △HPL-03 : HPL ORANGE COLOR
ex. TACO CLASSIC ORANGE
 - △GL-01 : 12MM CLEAR TEMPERED GLASS
 - △GL-02 : 12MM CLEAR TEMPERED GLASS ORANGE COLOR
 - △GS-01 : 12MM WHITE GLASS STONE
 - △FB-01 : PADED WALL WITH GREY FABRIC FINISH
 - △FB-02 : PADED WALL WITH ORANGE FABRIC FINISH
- ALL WOOD MATERIAL COVER FIRE PROOF & TERMITE TREATMENT

DEZAN STUDIO
Bintaro Business Centre Building
Jl. RC Veteran No. 1-1 Bintaro
Phone: +62 21 7357679
Fax: +62 21 7433946
www.dezanstudio.com
admin@dezanstudio.com

CLIENT	
UNFPA	
PROJECT	
UNFPA OFFICE	
DRAWING TITLE	
SECTION D SECTION E	
DRAWING No.	REVISION
INT-202	REV A
SCALE 1:75 @A3	CHECKED AN
DATE 05 Februari, 2020	DRAWN TR



01 Section F
INT-203 Scale: 1:75

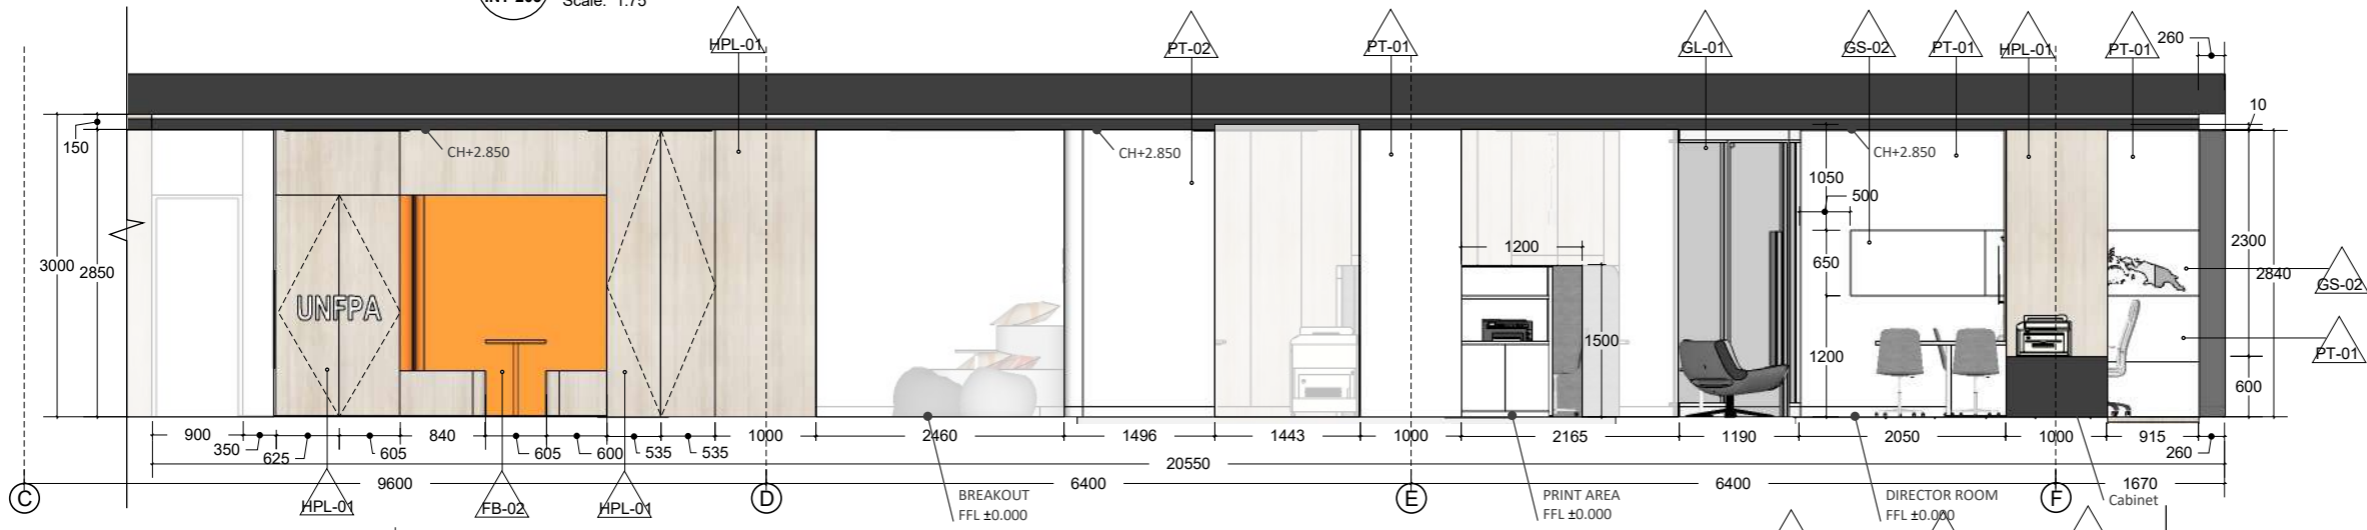

02 Section G
INT-203 Scale: 1:75






- : EXISTING MATERIAL
- : WALLPAPER WHITE COLOR
ex. DULUX TYPE COTTON FANTASY
- : WALLPAPER ORANGE COLOR
ex. DULUX TYPE MARIGOLD BLOSSOM
- : WALLPAPER LIGHT ORANGE
ex. DULUX TYPE TOPAZ SPARKLE
- : HPL WOOD PATTERN
ex. TACO TH 849 TM ASH AFROMOSIA TIMBER
- : HPL WHITE COLOR
ex. TACO CHALK TH 040 AA
- : HPL ORANGE COLOR
ex. TACO CLASSIC ORANGE
- : 12MM CLEAR TEMPERED GLASS
- : 12MM CLEAR TEMPERED GLASS ORANGE COLOR
- : 12MM WHITE GLASS STONE
- : PADED WALL WITH GREY FABRIC FINISH
- : PADED WALL WITH ORANGE FABRIC FINISH
- ALL WOOD MATERIAL COVER FIRE PROOF & TERMITE TREATMENT


DEZAN
STUDIO

Bintaro Business Centre Building
Jl. RC Veteran No. 1-1 Bintaro
Phone: +62 21 7357679
Fax: +62 21 7433946
www.dezanstudio.com
admin@dezanstudio.com

CLIENT	
UNFPA	
PROJECT	
UNFPA OFFICE	
DRAWING TITLE	
SECTION F SECTION G	
DRAWING No.	REVISION
INT-203	REV A
SCALE 1:75 @A3	CHECKED AN
DATE 05 Februari, 2020	DRAWN TR

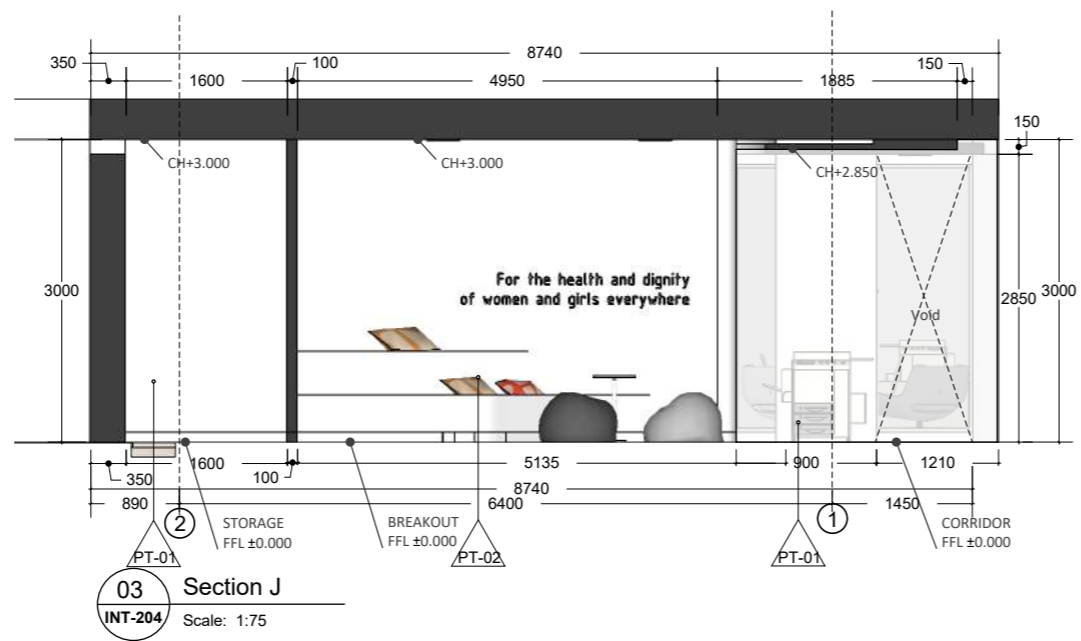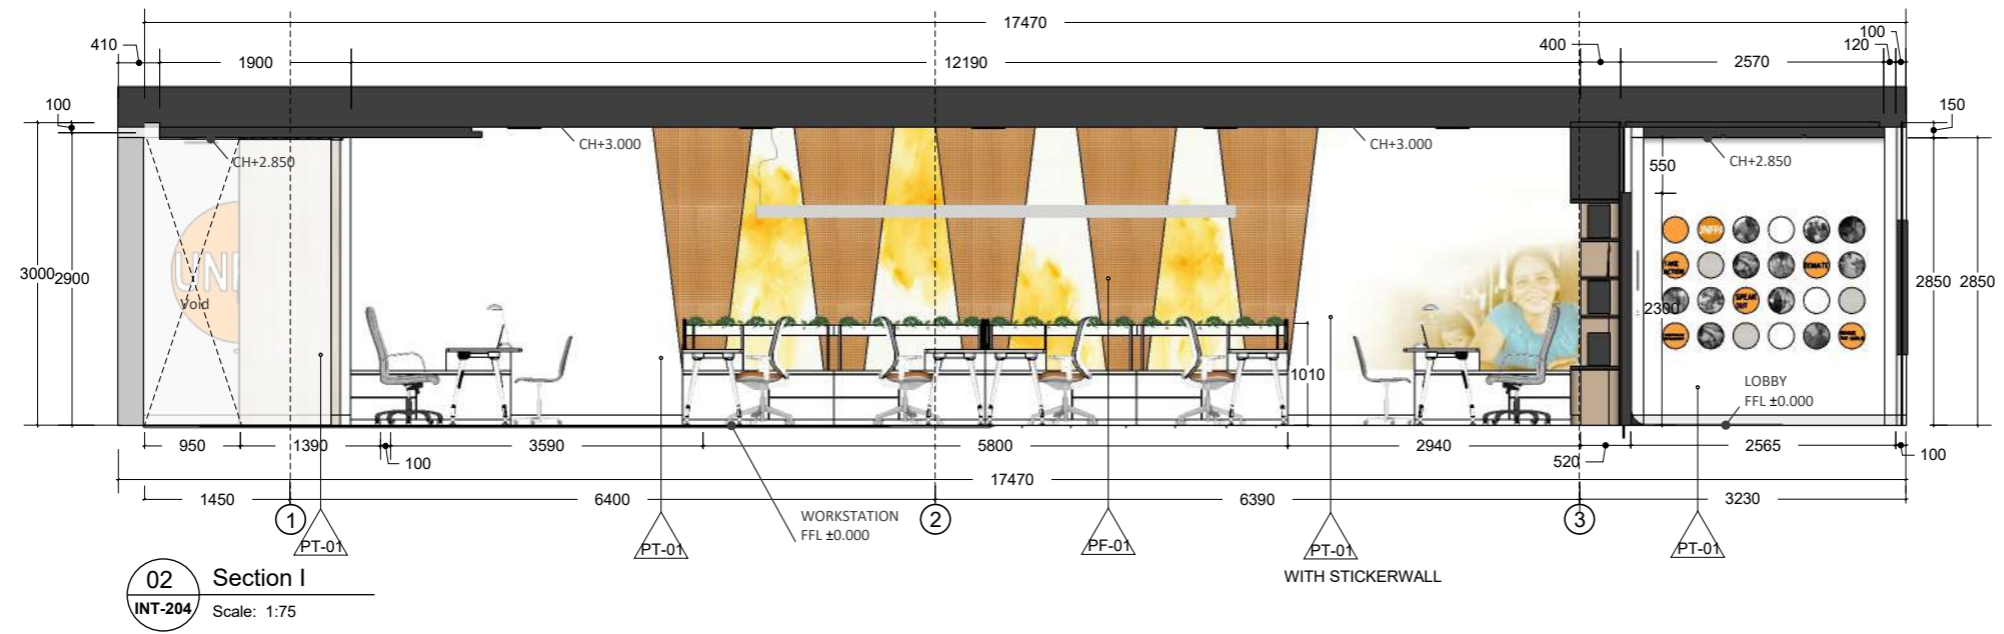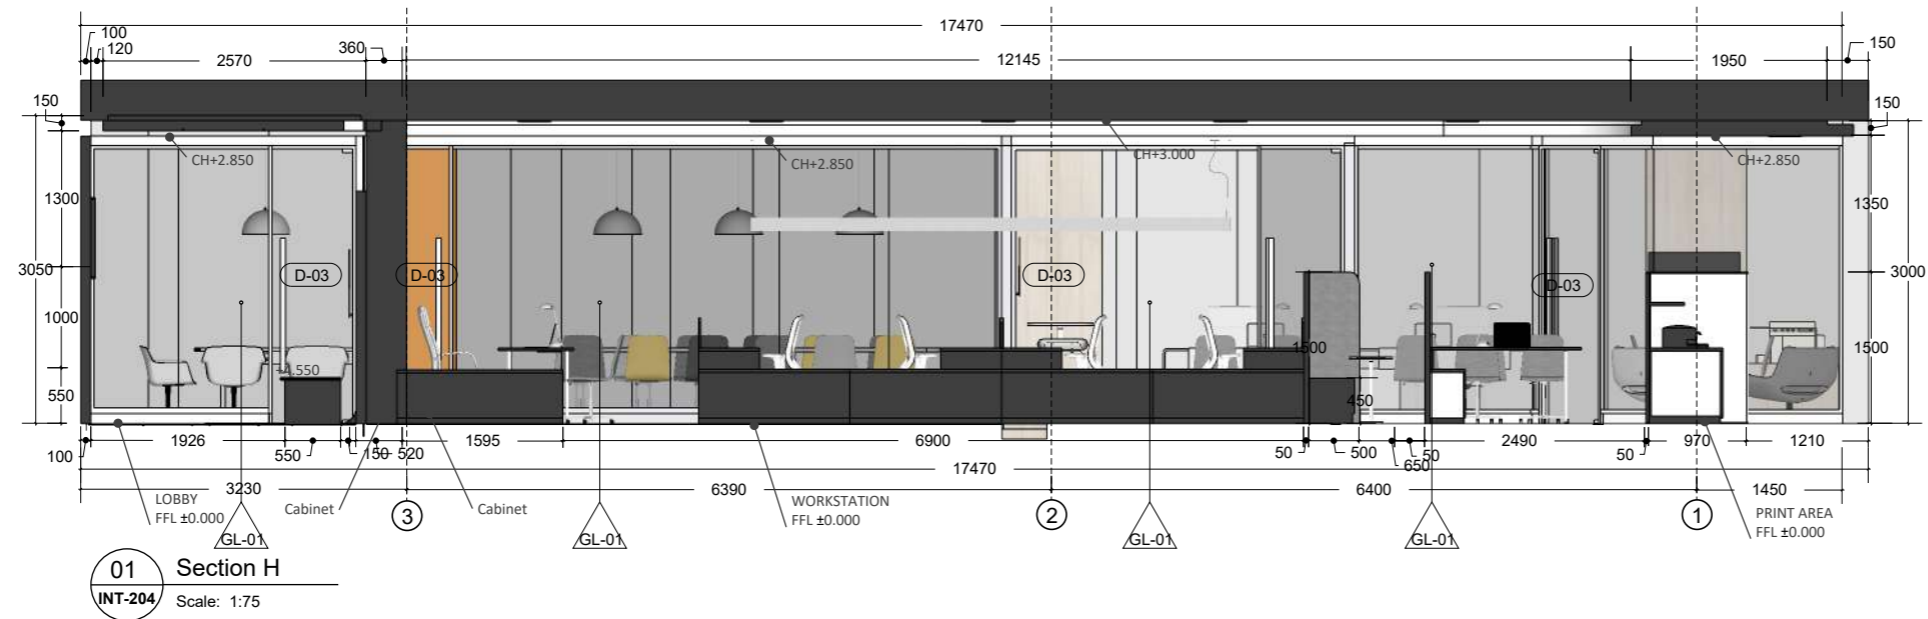






NOTE :

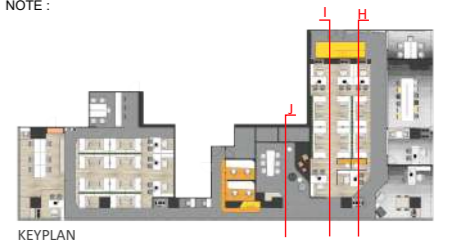

- : EXISTING MATERIAL
 - : WALLPAPER WHITE COLOR
ex. DULUX TYPE COTTON FANTASY
 - : WALLPAPER ORANGE COLOR
ex. DULUX TYPE MARIGOLD BLOSSOM
 - : WALLPAPER LIGHT ORANGE
ex. DULUX TYPE TOPAZ SPARKLE
 - : HPL WOOD PATTERN
ex. TACO TH 849 TM ASH AFROMOSIA TIMBER
 - : HPL WHITE COLOR
ex. TACO CHALK TH 040 AA
 - : HPL ORANGE COLOR
ex. TACO CLASSIC ORANGE
 - : 12MM CLEAR TEMPERED GLASS
 - : 12MM CLEAR TEMPERED GLASS ORANGE COLOR
 - : 12MM WHITE GLASS STONE
 - : PADED WALL WITH GREY FABRIC FINISH
 - : PADED WALL WITH ORANGE FABRIC FINISH
- ALL WOOD MATERIAL COVER FIRE PROOF & TERMITE TREATMENT

DEZAN STUDIO
Bintaro Business Centre Building
Jl. RC Veteran No. 1-1 Bintaro
Phone: +62 21 7357679
Fax: +62 21 7433946
www.dezanstudio.com
admin@dezanstudio.com

CLIENT	
UNFPA	
PROJECT	
UNFPA OFFICE	
DRAWING TITLE	
SECTION H SECTION I	
DRAWING No.	REVISION
INT-204	REV A
SCALE 1:75 @A3	CHECKED AN
DATE 05 Februari, 2020	DRAWN TR

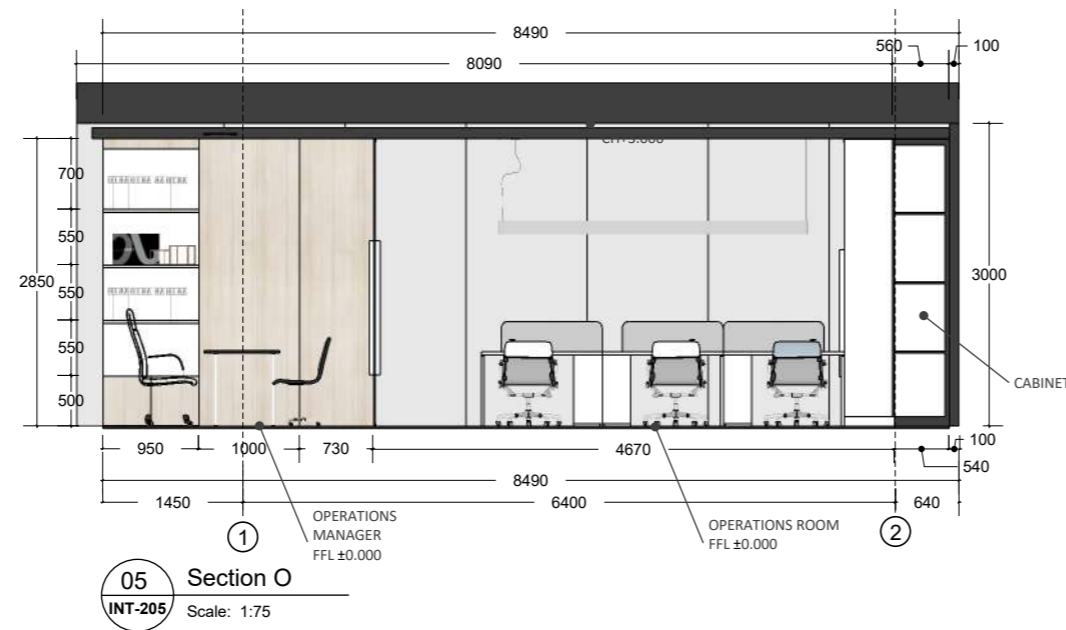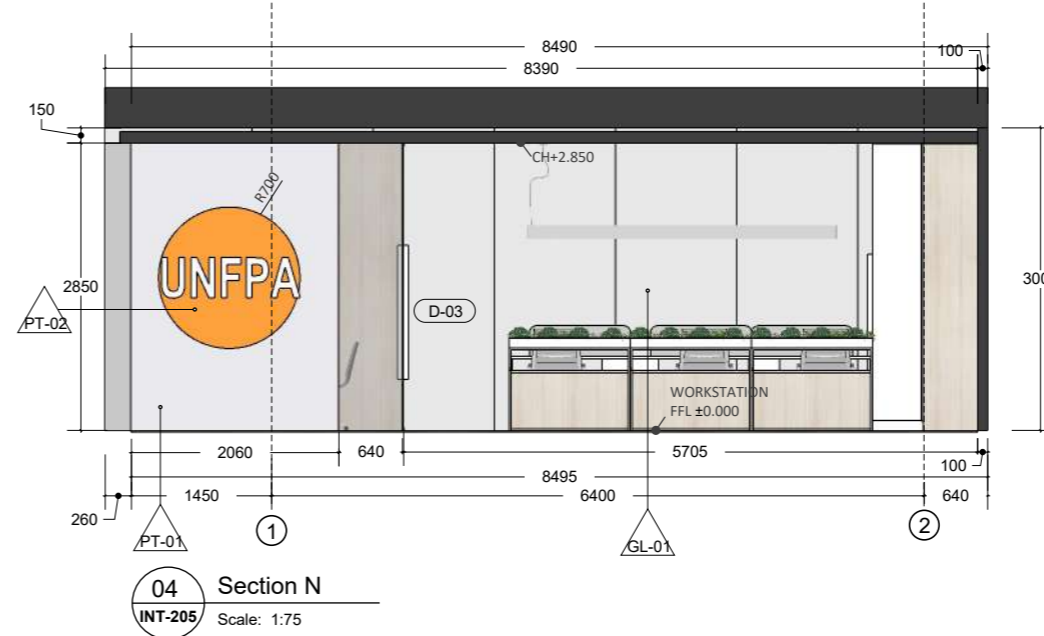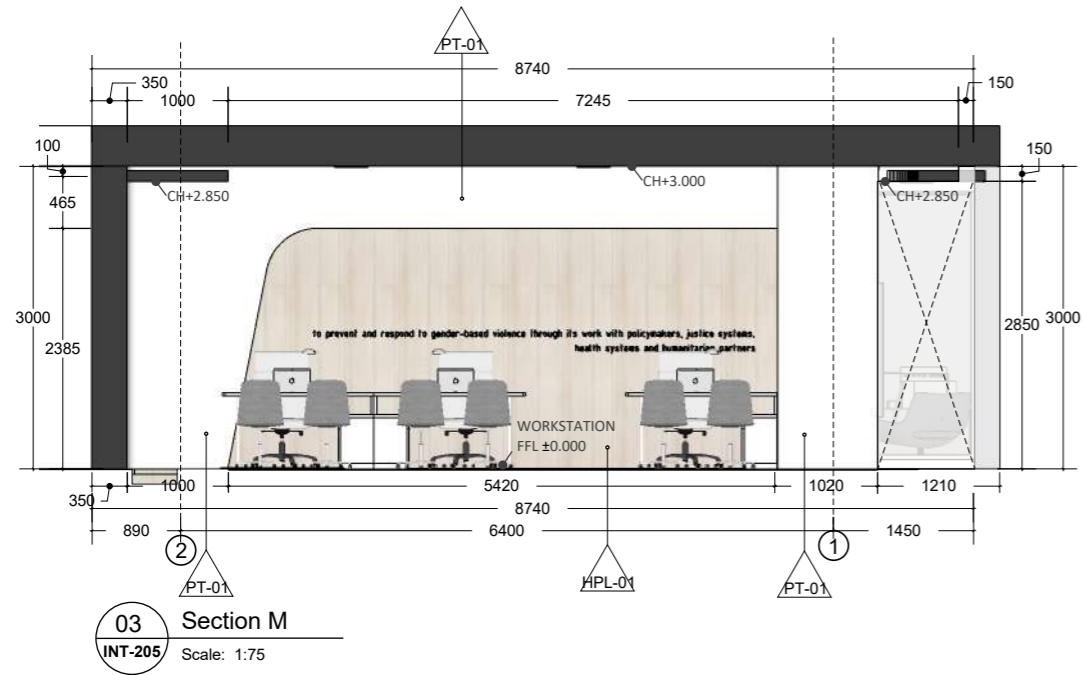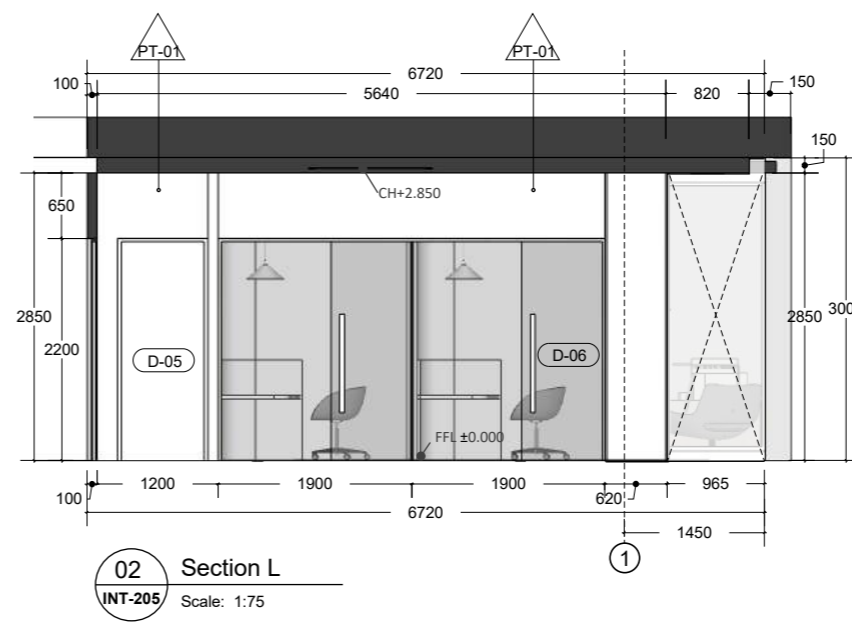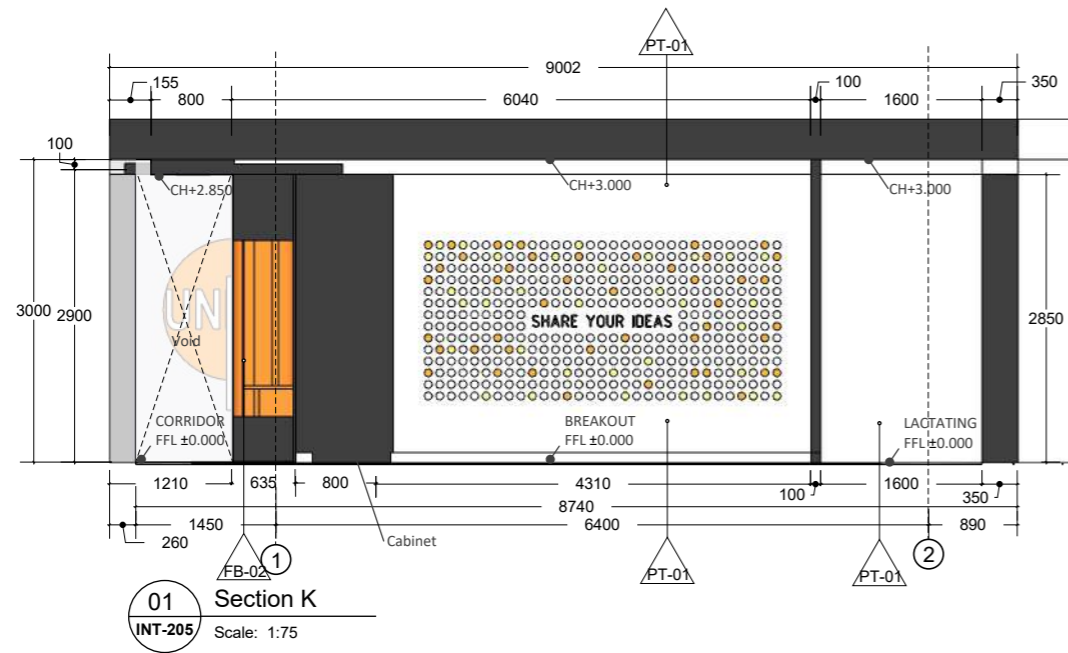

- NOTE :
-
- KEYPLAN
- △ WFX : EXISTING MATERIAL
 - △ PT-01 : WALLPAIN WHITE COLOR
ex. DULUX TYPE COTTON FANTASY
 - △ PT-02 : WALLPAIN ORANGE COLOR
ex. DULUX TYPE MARIGOLD BLOSSOM
 - △ PT-03 : WALLPAIN LIGHT ORANGE
ex. DULUX TYPE TOPAZ SPARKLE
 - △ HPL-01 : HPL WOOD PATTERN
ex. TACO TH 849 TM ASH AFROMOSIA TIMBER
 - △ HPL-02 : HPL WHITE COLOR
ex. TACO CHALK TH 040 AA
 - △ HPL-03 : HPL ORANGE COLOR
ex. TACO CLASSIC ORANGE
 - △ GL-01 : 12MM CLEAR TEMPERED GLASS
 - △ GL-02 : 12MM CLEAR TEMPERED GLASS ORANGE COLOR
 - △ GS-01 : 12MM WHITE GLASS STONE
 - △ FB-01 : PADED WALL WITH GREY FABRIC FINISH
 - △ FB-02 : PADED WALL WITH ORANGE FABRIC FINISH
- ALL WOOD MATERIAL COVER FIRE PROOF & TERMITE TREATMENT

Bintaro Business Centre Building
Jl. RC Veteran No. 1-1 Bintaro
Phone: +62 21 7357679
Fax: +62 21 7433946
www.dezanstudio.com
admin@dezanstudio.com

CLIENT	
UNFPA	
PROJECT	
UNFPA OFFICE	
DRAWING TITLE	
SECTION K SECTION L	
DRAWING No.	REVISION
INT-205	REV A
SCALE 1:75 @A3	CHECKED AN
DATE 05 Februari, 2020	DRAWN TR

NOTE :



01 PERSPECTIVE 1
INT-206



02 PERSPECTIVE 2
INT-206



03 PERSPECTIVE 3
INT-206

Bintaro Business Centre Building
Jl. RC Veteran No. 1-1 Bintaro
Phone: +62 21 7357679
Fax: +62 21 7433946
www.dezanstudio.com
admin@dezanstudio.com



CLIENT

UNFPA





PROJECT

UNFPA OFFICE

DRAWING TITLE

THE PERSPECTIVE








DRAWING No.	REVISION
INT-206	REV A
SCALE 1:75 @A3	CHECKED AN
DATE 05 Februari, 2020	DRAWN TR

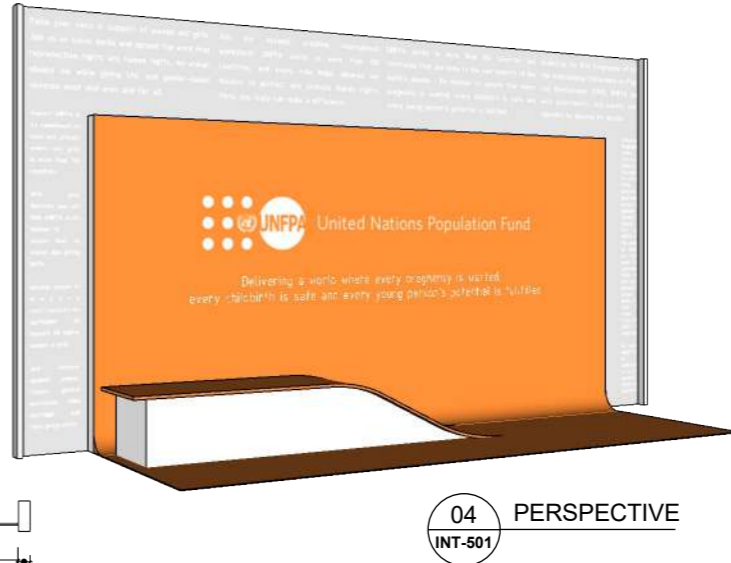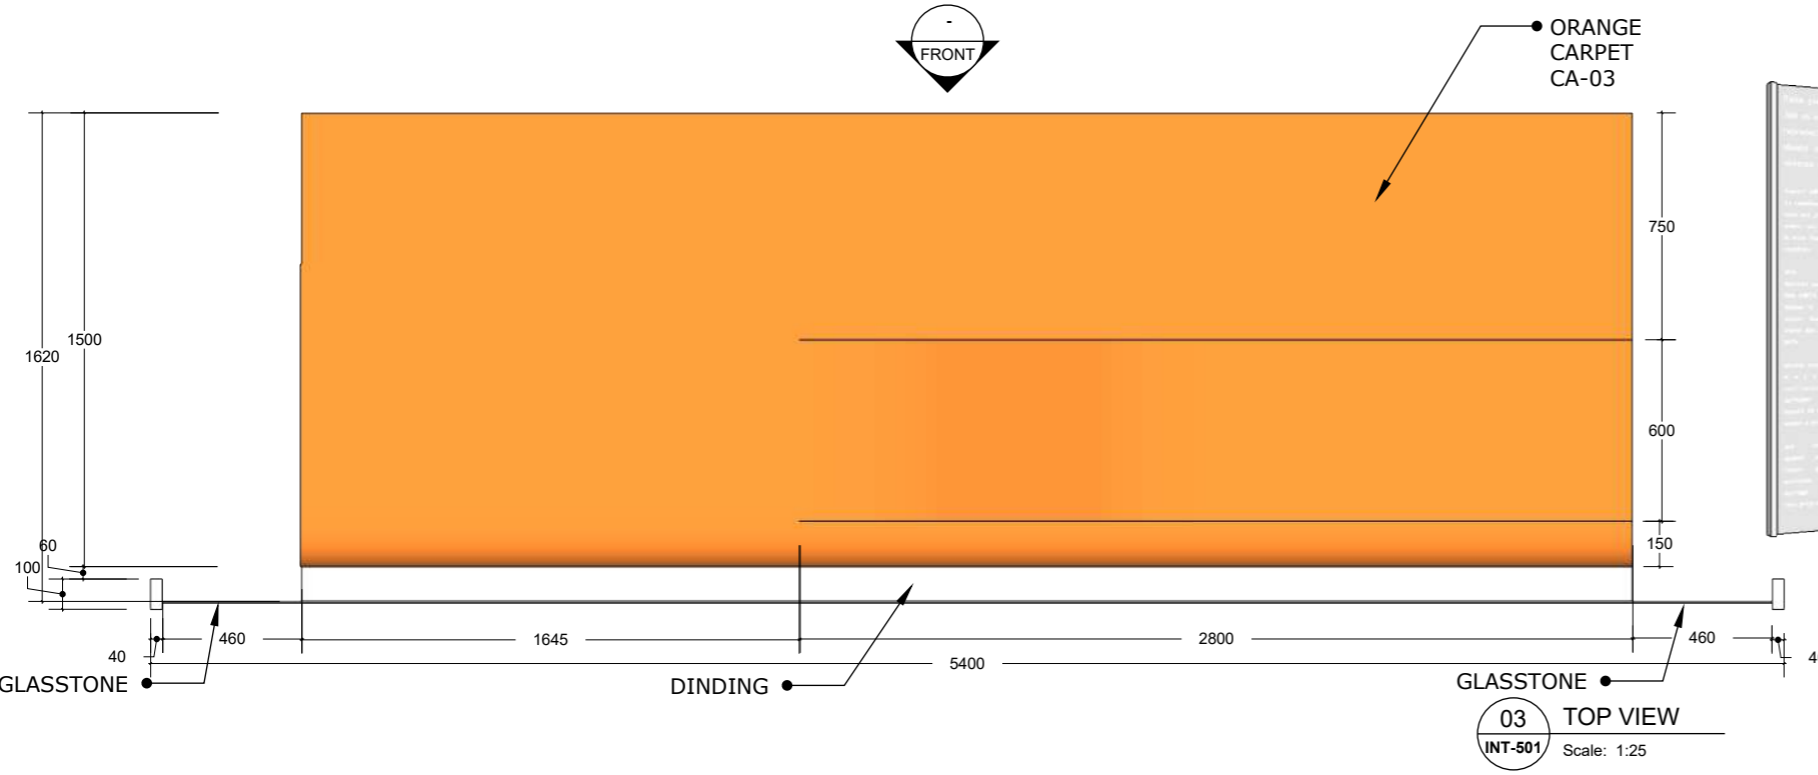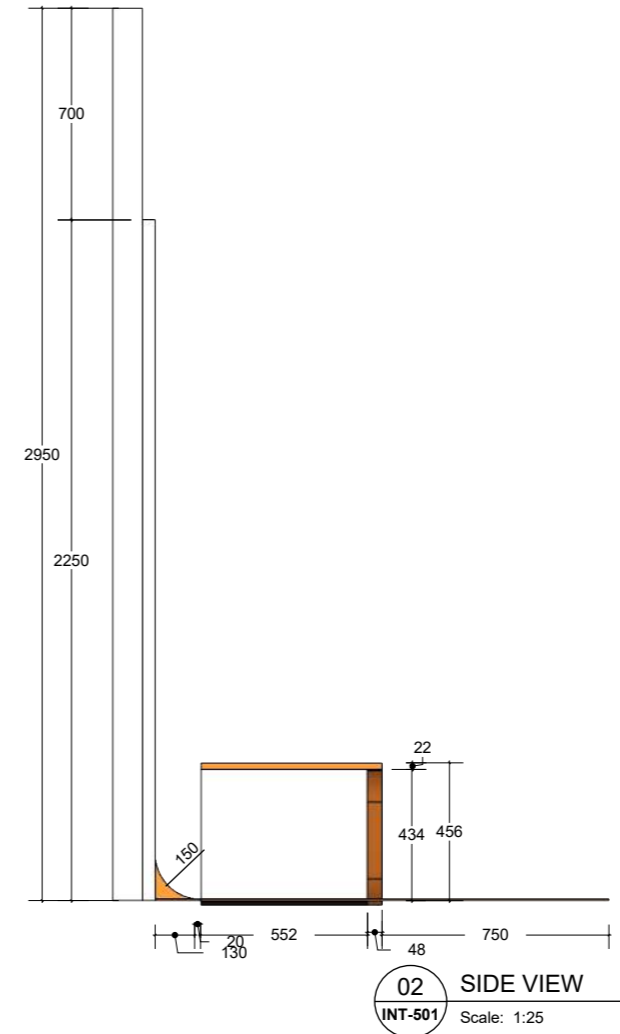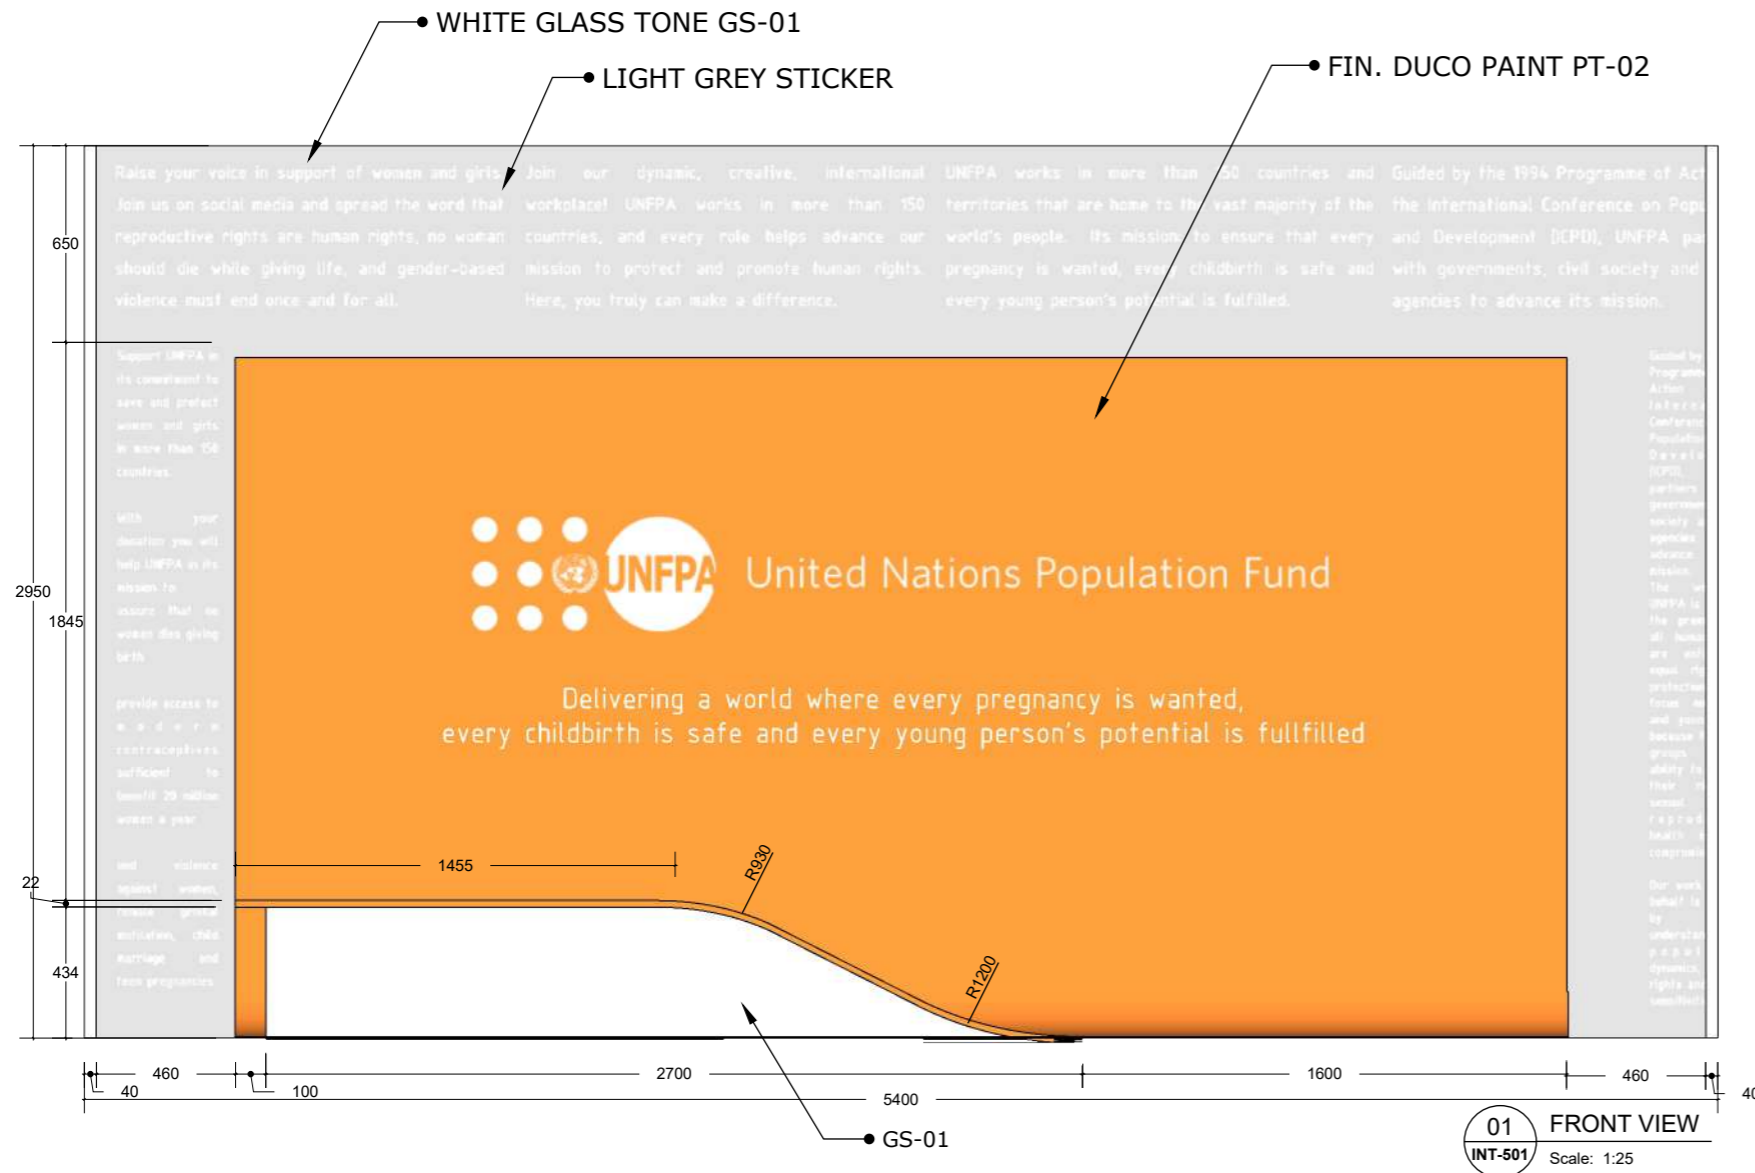

- NOTE :
- : EXISTING MATERIAL
 - : WALLPAINT WHITE COLOR
ex. DULUX TYPE COTTON FANTASY
 - : WALLPAINT ORANGE COLOR
ex. DULUX TYPE MARIGOLD BLOSSOM
 - : WALLPAINT LIGHT ORANGE
ex. DULUX TYPE TOPAZ SPARKLE
 - : HPL WOOD PATTERN
ex. TACO TH 849 TM ASH AFROMOSIA TIMBER
 - : HPL WHITE COLOR
ex. TACO CHALK TH 040 AA
 - : HPL ORANGE COLOR
ex. TACO CLASSIC ORANGE
 - : 12MM CLEAR TEMPERED GLASS
 - : 12MM CLEAR TEMPERED GLASS ORANGE COLOR
 - : 12MM WHITE GLASS STONE
 - : PADED WALL WITH GREY FABRIC FINISH
 - : PADED WALL WITH ORANGE FABRIC FINISH
- ALL WOOD MATERIAL COVER FIRE PROOF & TERMITE TREATMENT

DEZAN STUDIO
 Bintaro Business Centre Building
 Jl. RC Veteran No. 1-1 Bintaro
 Phone: +62 21 7357679
 Fax: +62 21 7433946
 www.dezanstudio.com
 admin@dezanstudio.com






CLIENT	
UNFPA	
PROJECT	
UNFPA OFFICE	
DRAWING TITLE	
DETAIL CF-01 (ENTRANCE WALL)	
DRAWING No.	REVISION
INT-501	REV A
SCALE 1:25 @A3	CHECKED AN
DATE 05 Februari, 2020	DRAWN TR

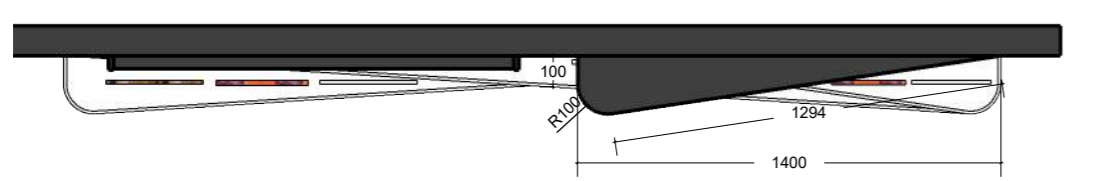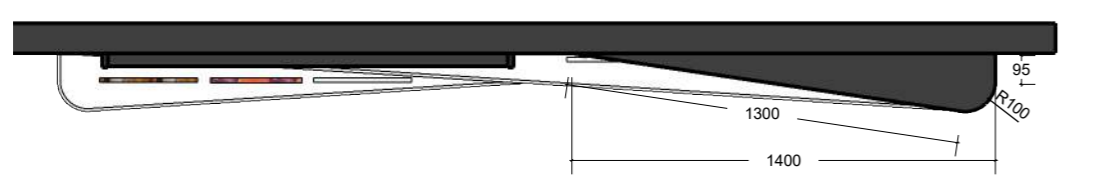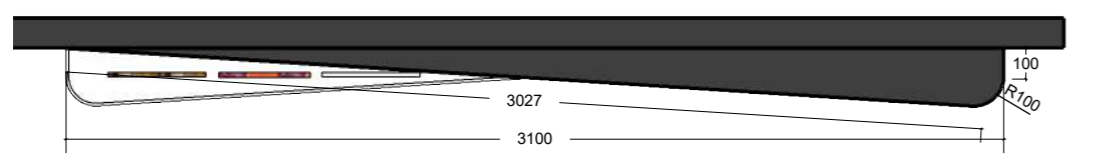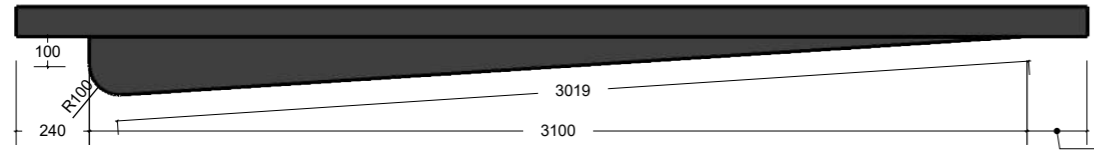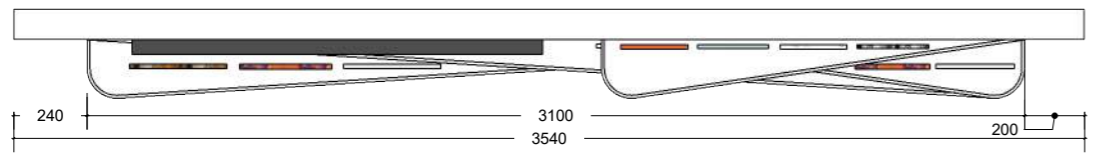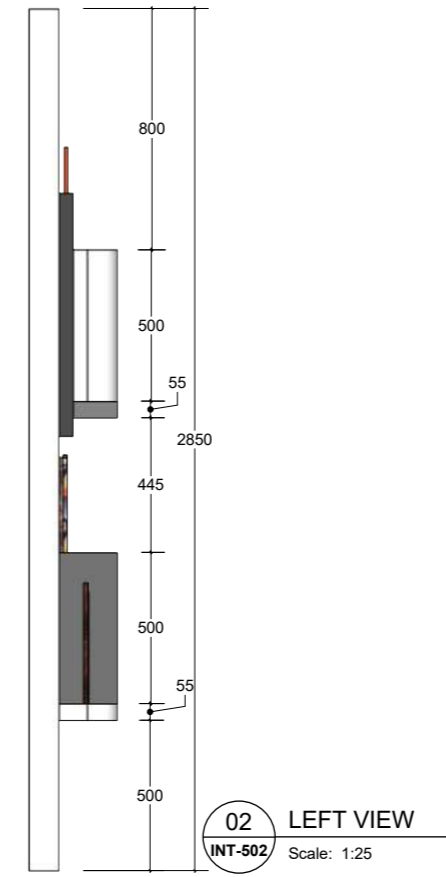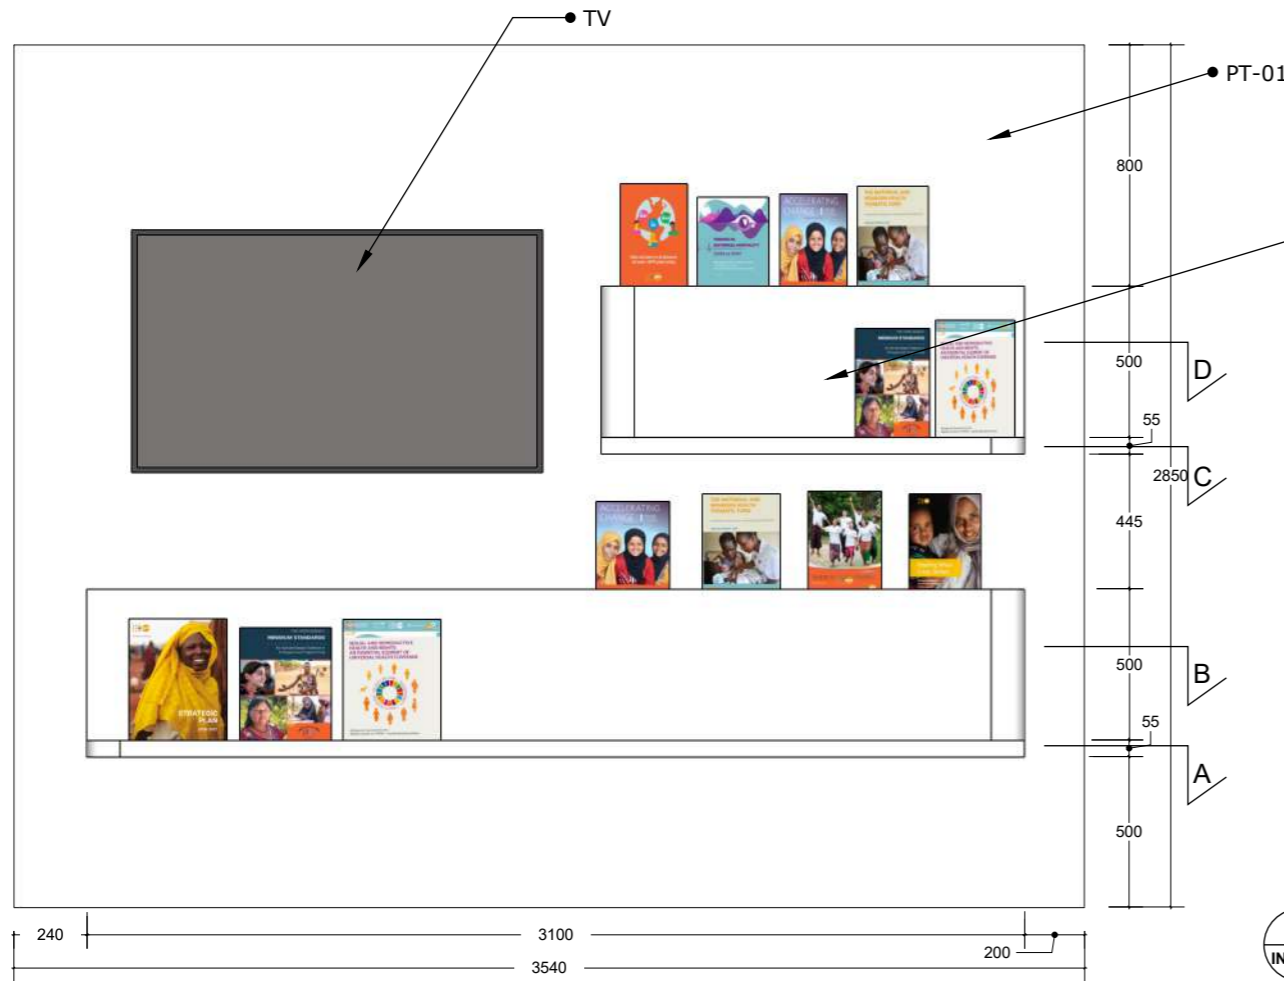

- NOTE :
-
- KEYPLAN
- △WEX : EXISTING MATERIAL
 - △PT-01 : WALLPAPER WHITE COLOR
ex. DULUX TYPE COTTON FANTASY
 - △PT-02 : WALLPAPER ORANGE COLOR
ex. DULUX TYPE MARIGOLD BLOSSOM
 - △PT-03 : WALLPAPER LIGHT ORANGE
ex. DULUX TYPE TOPAZ SPARKLE
 - △HPL-01 : HPL WOOD PATTERN
ex. TACO TH 849 TM ASH AFROMOSIA TIMBER
 - △HPL-02 : HPL WHITE COLOR
ex. TACO CHALK TH 040 AA
 - △HPL-03 : HPL ORANGE COLOR
ex. TACO CLASSIC ORANGE
 - △GL-01 : 12MM CLEAR TEMPERED GLASS
 - △GL-02 : 12MM CLEAR TEMPERED GLASS ORANGE COLOR
 - △GS-01 : 12MM WHITE GLASS STONE
 - △FB-01 : PADED WALL WITH GREY FABRIC FINISH
 - △FB-02 : PADED WALL WITH ORANGE FABRIC FINISH
- ALL WOOD MATERIAL COVER FIRE PROOF & TERMITE TREATMENT

DEZAN STUDIO
 Bintaro Business Centre Building
 Jl. RC Veteran No. 1-1 Bintaro
 Phone: +62 21 7357679
 Fax: +62 21 7433946
 www.dezanstudio.com
 admin@dezanstudio.com





CLIENT	
UNFPA	
PROJECT	
UNFPA OFFICE	
DRAWING TITLE	
DETAIL CF-02 (SHOWCASE PRODUCTS)	
DRAWING No.	REVISION
INT-502	REV A
SCALE 1:25 @A3	CHECKED AN
DATE 05 Februari, 2020	DRAWN TR

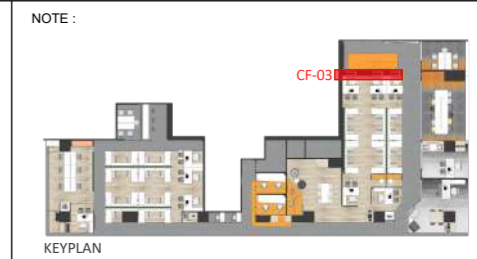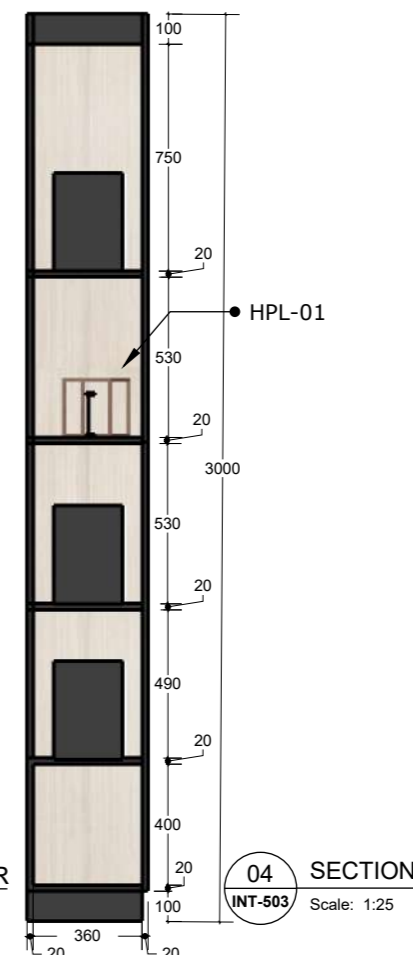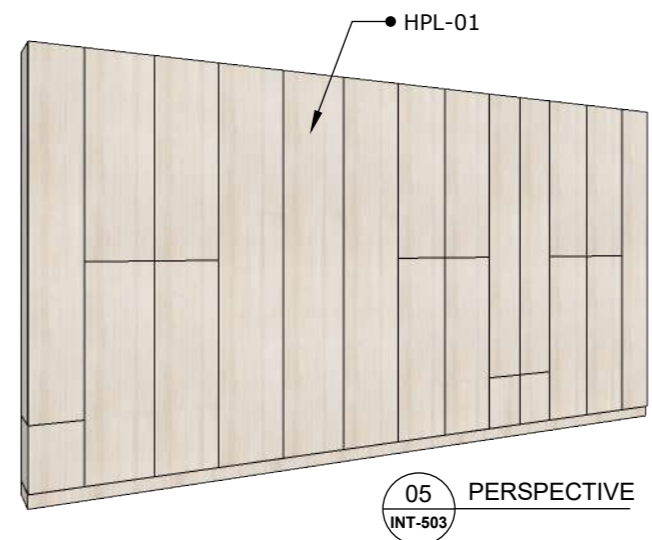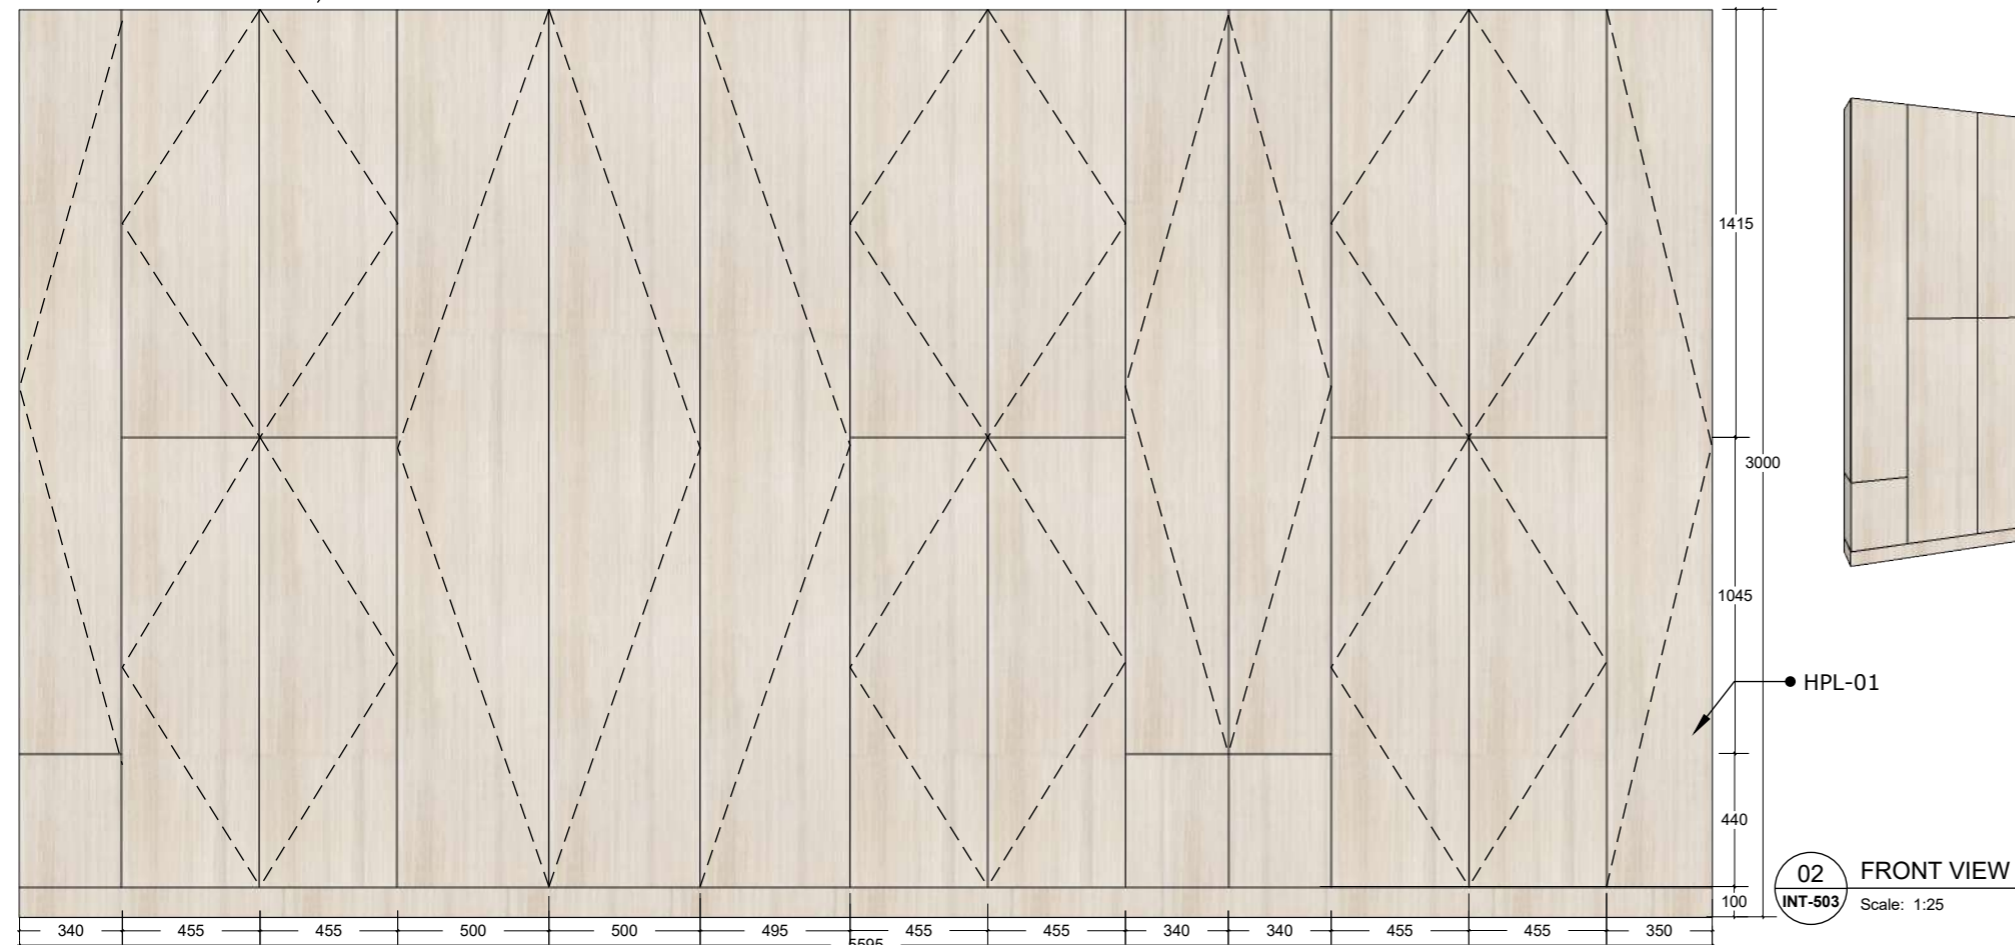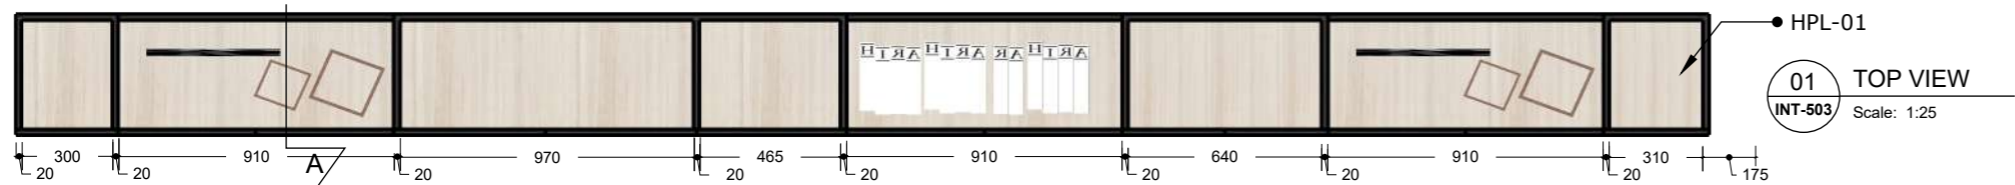

- NOTE :
- : EXISTING MATERIAL
 - : WALLPAPER WHITE COLOR
ex. DULUX TYPE COTTON FANTASY
 - : WALLPAPER ORANGE COLOR
ex. DULUX TYPE MARIGOLD BLOSSOM
 - : WALLPAPER LIGHT ORANGE
ex. DULUX TYPE TOPAZ SPARKLE
 - : HPL WOOD PATTERN
ex. TACO TH 849 TM ASH AFROMOSIA TIMBER
 - : HPL WHITE COLOR
ex. TACO CHALK TH 040 AA
 - : HPL ORANGE COLOR
ex. TACO CLASSIC ORANGE
 - : 12MM CLEAR TEMPERED GLASS
 - : 12MM CLEAR TEMPERED GLASS ORANGE COLOR
 - : 12MM WHITE GLASS STONE
 - : PADED WALL WITH GREY FABRIC FINISH
 - : PADED WALL WITH ORANGE FABRIC FINISH
- ALL WOOD MATERIAL COVER FIRE PROOF & TERMITE TREATMENT

DEZAN STUDIO
 Bintaro Business Centre Building
 Jl. RC Veteran No. 1-1 Bintaro
 Phone: +62 21 7357679
 Fax: +62 21 7433946
 www.dezanstudio.com
 admin@dezanstudio.com





CLIENT	
UNFPA	
PROJECT	
UNFPA OFFICE	
DRAWING TITLE	
DETAIL CF-03 (WORKSPACE CABINET)	
DRAWING No.	REVISION
INT-503	REV A
SCALE 1:25 @A3	CHECKED AN
DATE 05 Februari, 2020	DRAWN TR

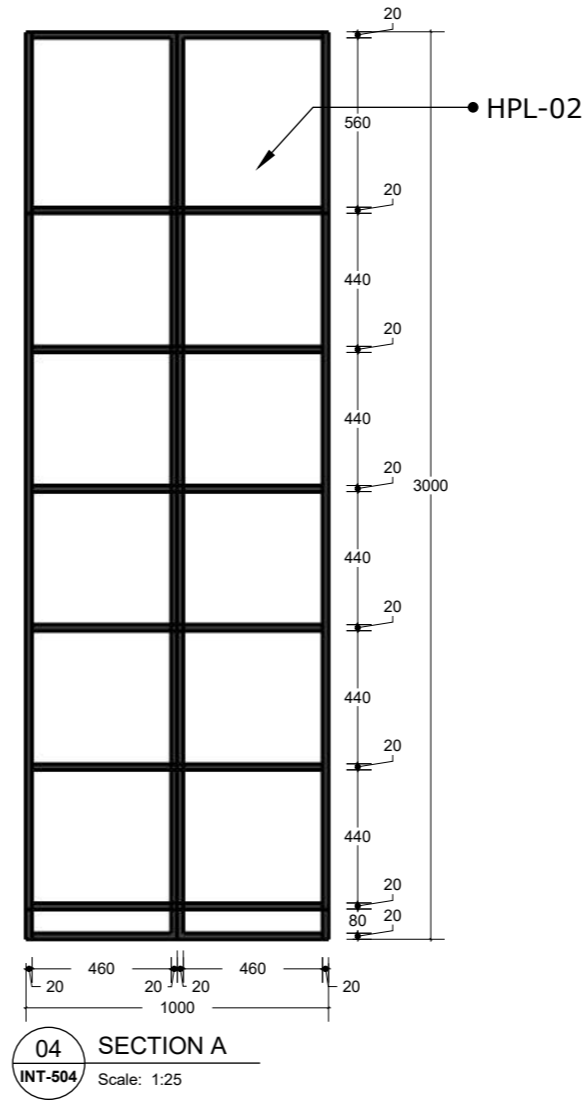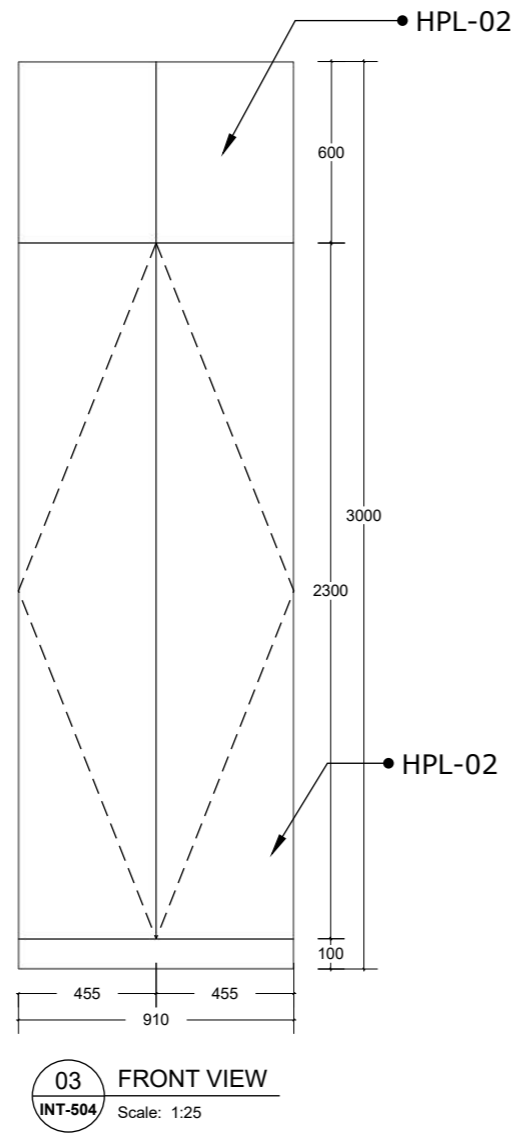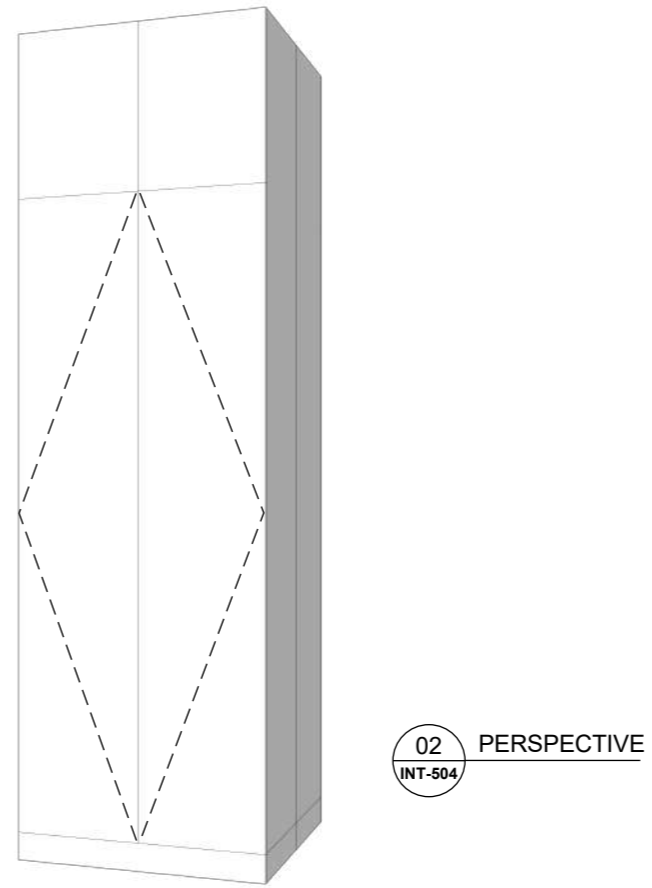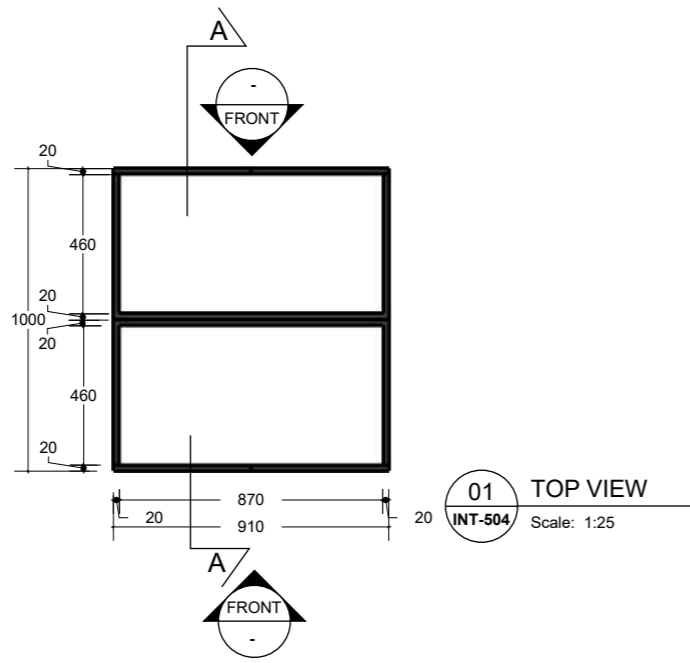

- NOTE :
- : EXISTING MATERIAL
 - : WALLPAPER WHITE COLOR
ex. DULUX TYPE COTTON FANTASY
 - : WALLPAPER ORANGE COLOR
ex. DULUX, TYPE MARIGOLD BLOSSOM
 - : WALLPAPER LIGHT ORANGE
ex. DULUX, TYPE TOPAZ SPARKLE
 - : HPL WOOD PATTERN
ex. TACO TH 849 TM ASH AFROMOSIA TIMBER
 - : HPL WHITE COLOR
ex. TACO CHALK TH 040 AA
 - : HPL ORANGE COLOR
ex. TACO CLASSIC ORANGE
 - : 12MM CLEAR TEMPERED GLASS
 - : 12MM CLEAR TEMPERED GLASS ORANGE COLOR
 - : 12MM WHITE GLASS STONE
 - : PADED WALL WITH GREY FABRIC FINISH
 - : PADED WALL WITH ORANGE FABRIC FINISH
- ALL WOOD MATERIAL, COVER FIRE PROOF & TERMITE TREATMENT

Bintaro Business Centre Building
 Jl. RC Veteran No. 1-1 Bintaro
 Phone: +62 21 7357679
 Fax: +62 21 7433946
 www.dezanstudio.com
 admin@dezanstudio.com

CLIENT	
UNFPA	
PROJECT	
UNFPA OFFICE	
DRAWING TITLE	
DETAIL CF-04 (CABINET MEETING ROOM)	
DRAWING No.	REVISION
INT-504	REV A
SCALE 1:25 @A3	CHECKED AN
DATE 05 Februari, 2020	DRAWN TR

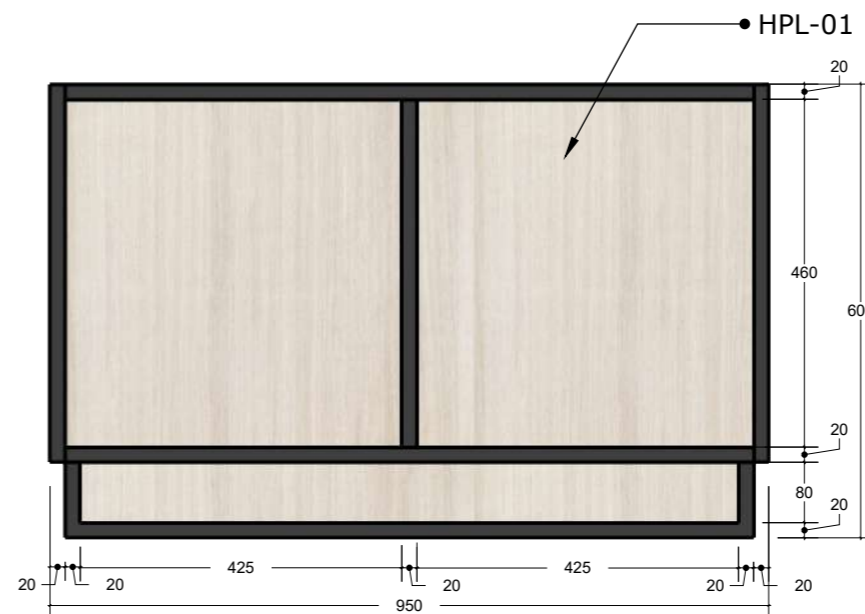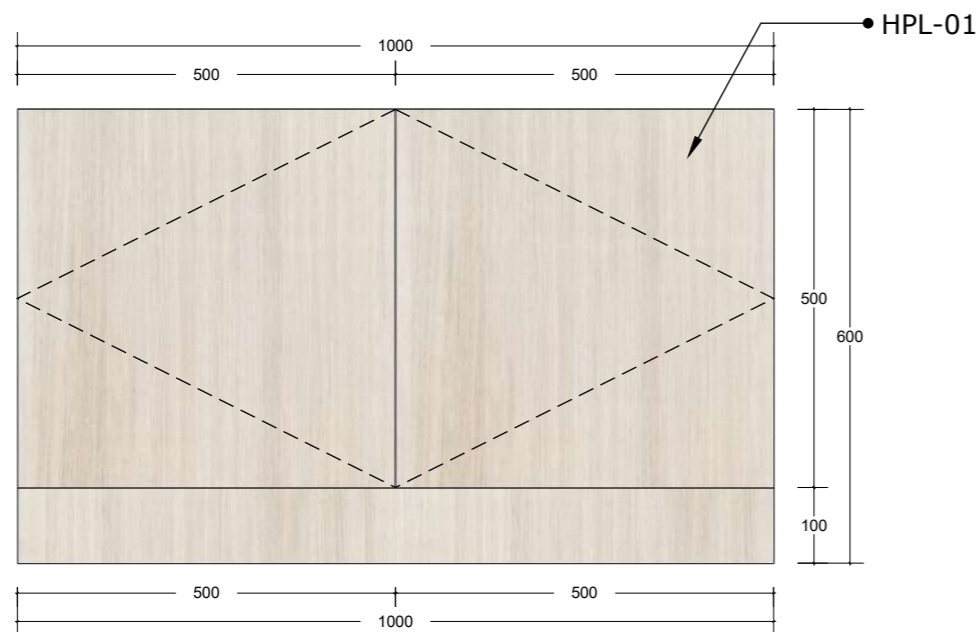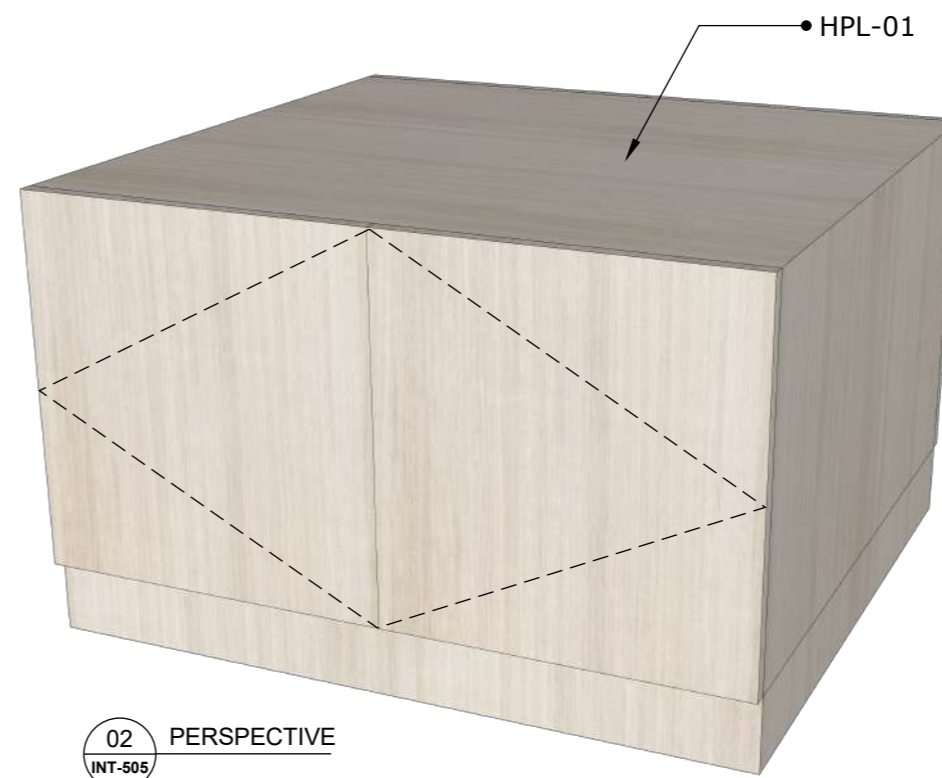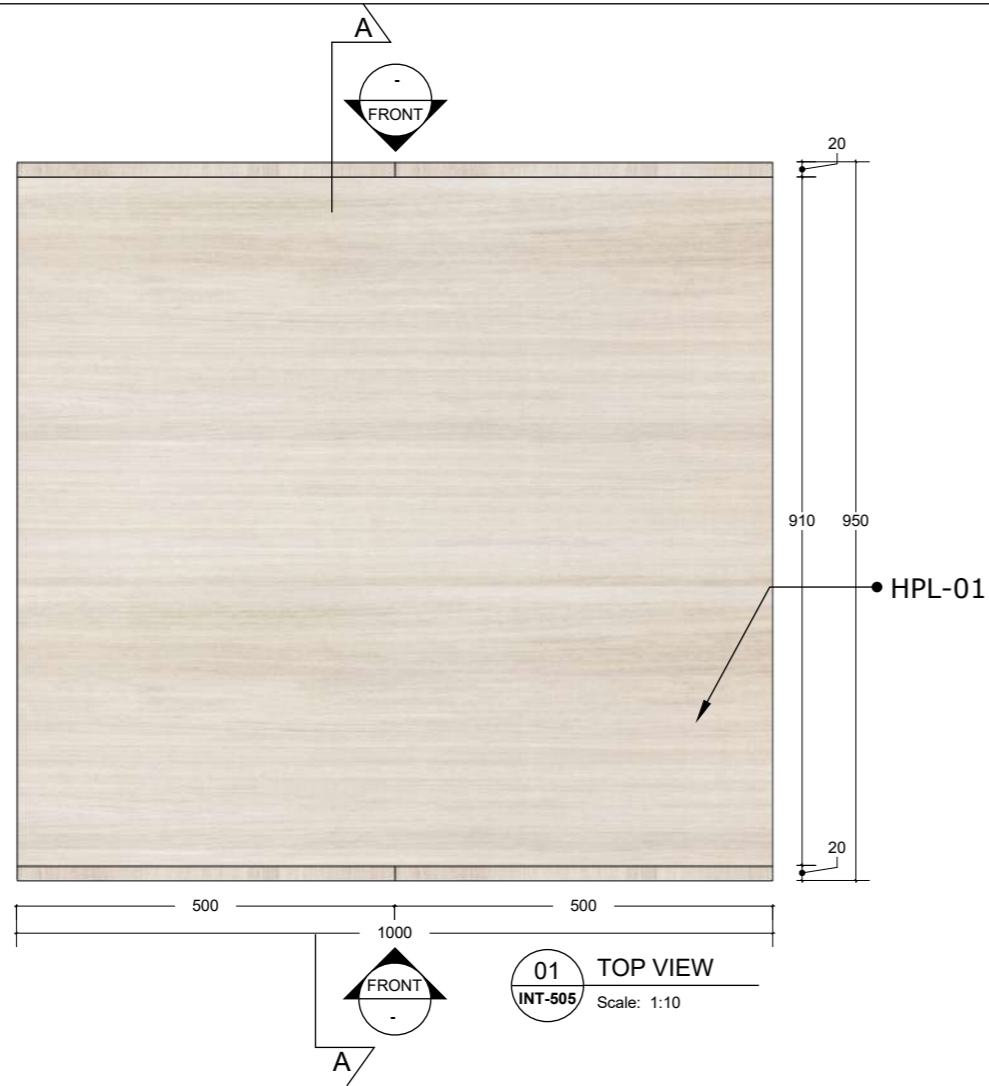

NOTE :







- : EXISTING MATERIAL
 - : WALLPAINT WHITE COLOR
ex. DULUX TYPE COTTON FANTASY
 - : WALLPAINT ORANGE COLOR
ex. DULUX, TYPE MARIGOLD BLOSSOM
 - : WALLPAINT LIGHT ORANGE
ex. DULUX, TYPE TOPAZ SPARKLE
 - : HPL WOOD PATTERN
ex. TACO TH 849 TM ASH AFROMOSIA TIMBER
 - : HPL WHITE COLOR
ex. TACO CHALK TH 040 AA
 - : HPL ORANGE COLOR
ex. TACO CLASSIC ORANGE
 - : 12MM CLEAR TEMPERED GLASS
 - : 12MM CLEAR TEMPERED GLASS ORANGE COLOR
 - : 12MM WHITE GLASS STONE
 - : PADED WALL WITH GREY FABRIC FINISH
 - : PADED WALL WITH ORANGE FABRIC FINISH
- ALL WOOD MATERIAL, COVER FIRE PROOF & TERMITE TREATMENT

DEZAN
STUDIO

Bintaro Business Centre Building
Jl. RC Veteran No. 1-1 Bintaro
Phone: +62 21 7357679
Fax: +62 21 7433946
www.dezanstudio.com
admin@dezanstudio.com

CLIENT	
UNFPA	
PROJECT	
UNFPA OFFICE	
DRAWING TITLE	
DETAIL CF-05 (CREDENZA)	
DRAWING No.	REVISION
INT-505	REV A
SCALE	1:10 @A3
DATE	05 Februari, 2020
CHECKED	AN
DRAWN	TR

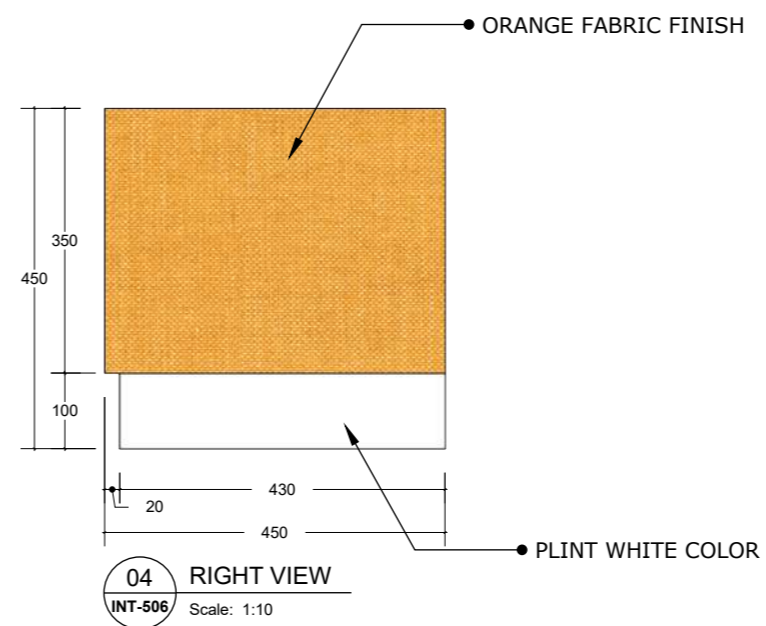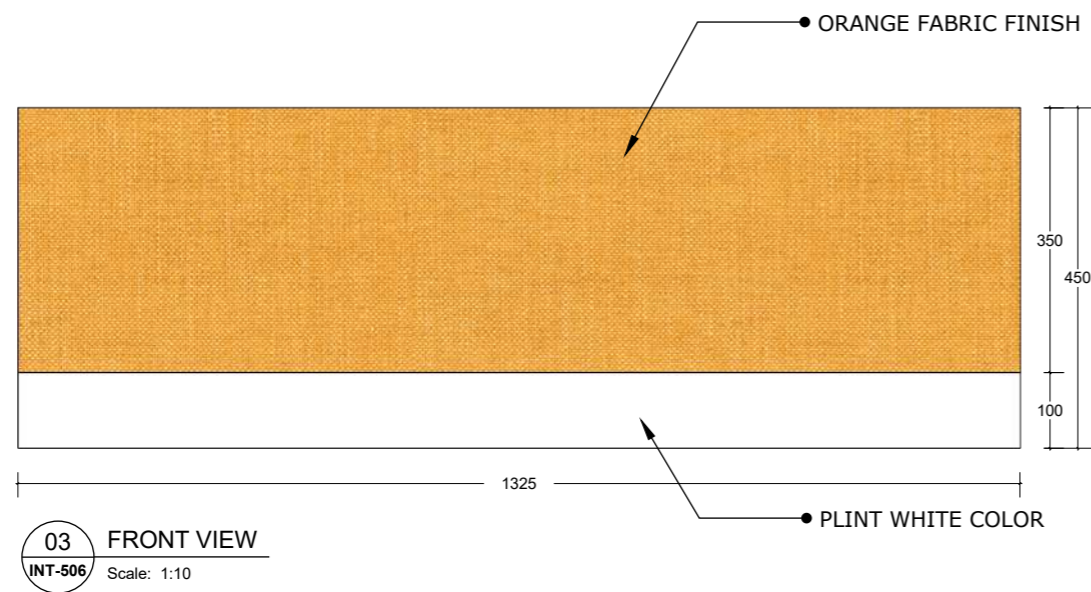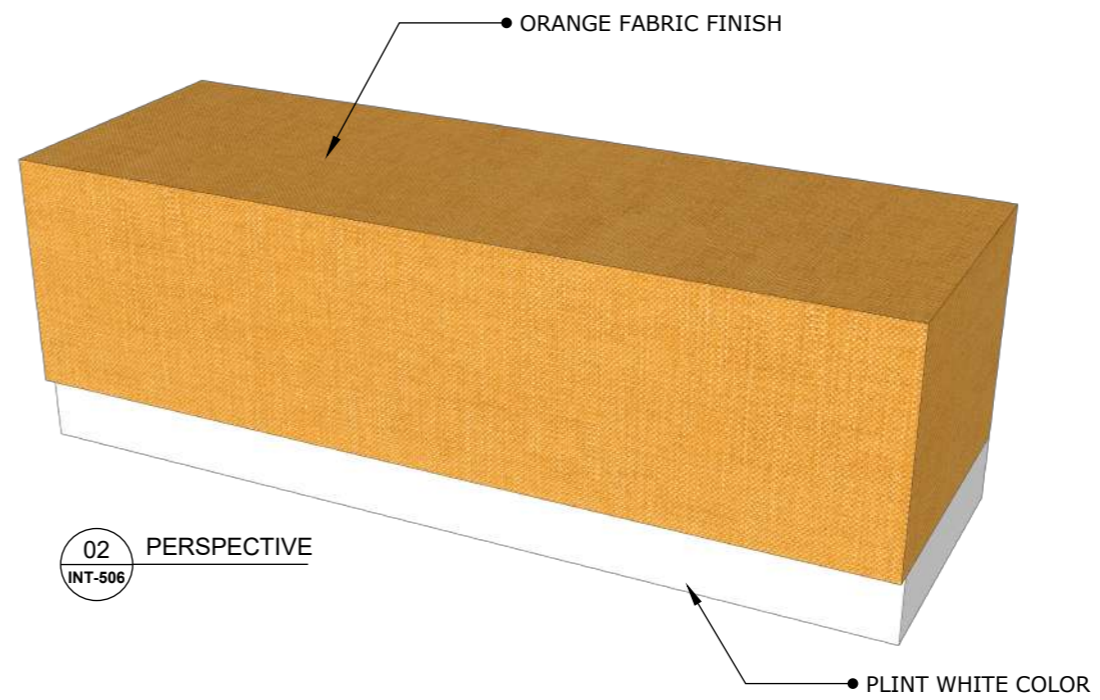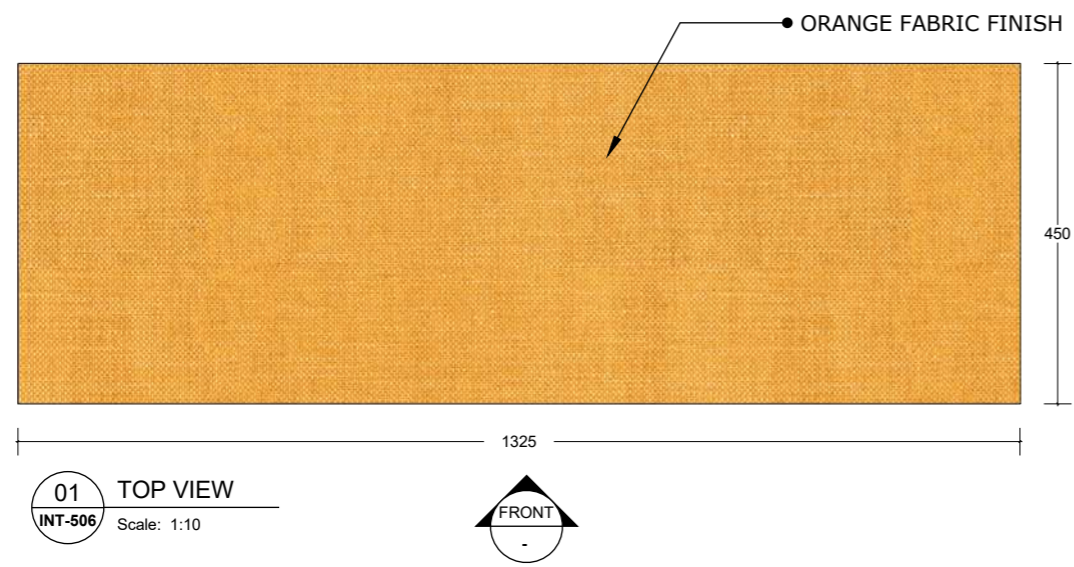

NOTE :



- : EXISTING MATERIAL
 - : WALLPAIN WHITE COLOR
ex. DULUX TYPE COTTON FANTASY
 - : WALLPAIN ORANGE COLOR
ex. DULUX, TYPE MARIGOLD BLOSSOM
 - : WALLPAIN LIGHT ORANGE
ex. DULUX, TYPE TOPAZ SPARKLE
 - : HPL WOOD PATTERN
ex. TACO TH 849 TM ASH AFROMOSIA TIMBER
 - : HPL WHITE COLOR
ex. TACO CHALK TH 040 AA
 - : HPL ORANGE COLOR
ex. TACO CLASSIC ORANGE
 - : 12MM CLEAR TEMPERED GLASS
 - : 12MM CLEAR TEMPERED GLASS ORANGE COLOR
 - : 12MM WHITE GLASS STONE
 - : PADED WALL WITH GREY FABRIC FINISH
 - : PADED WALL WITH ORANGE FABRIC FINISH
- ALL WOOD MATERIAL COVER FIRE PROOF & TERMITE TREATMENT

DEZAN
STUDIO

Bintaro Business Centre Building
Jl. RC Veteran No. 1-1 Bintaro
Phone: +62 21 7357679
Fax: +62 21 7433946
www.dezanstudio.com
admin@dezanstudio.com

CLIENT

UNFPA





PROJECT

UNFPA OFFICE

DRAWING TITLE

DETAIL CF-06
(QUIET ROOM)


DRAWING No.	REVISION
INT-506	REV A
SCALE 1:25 @A3	CHECKED AN
DATE 05 Februari, 2020	DRAWN TR

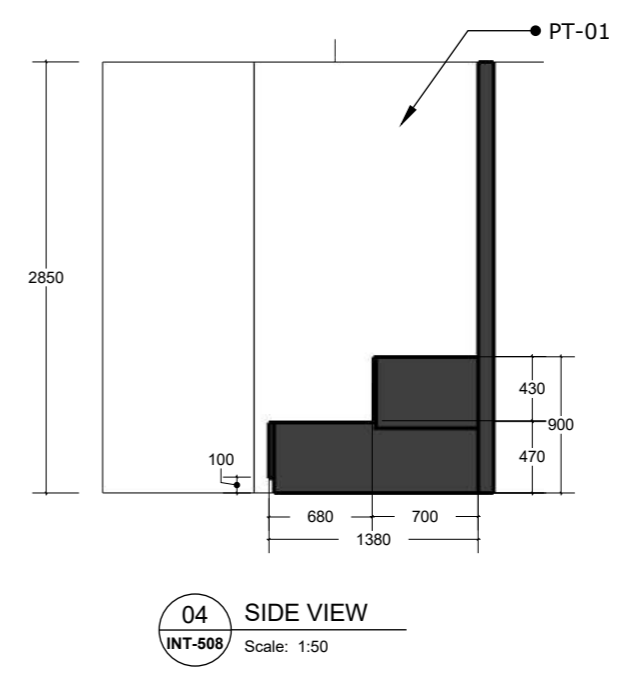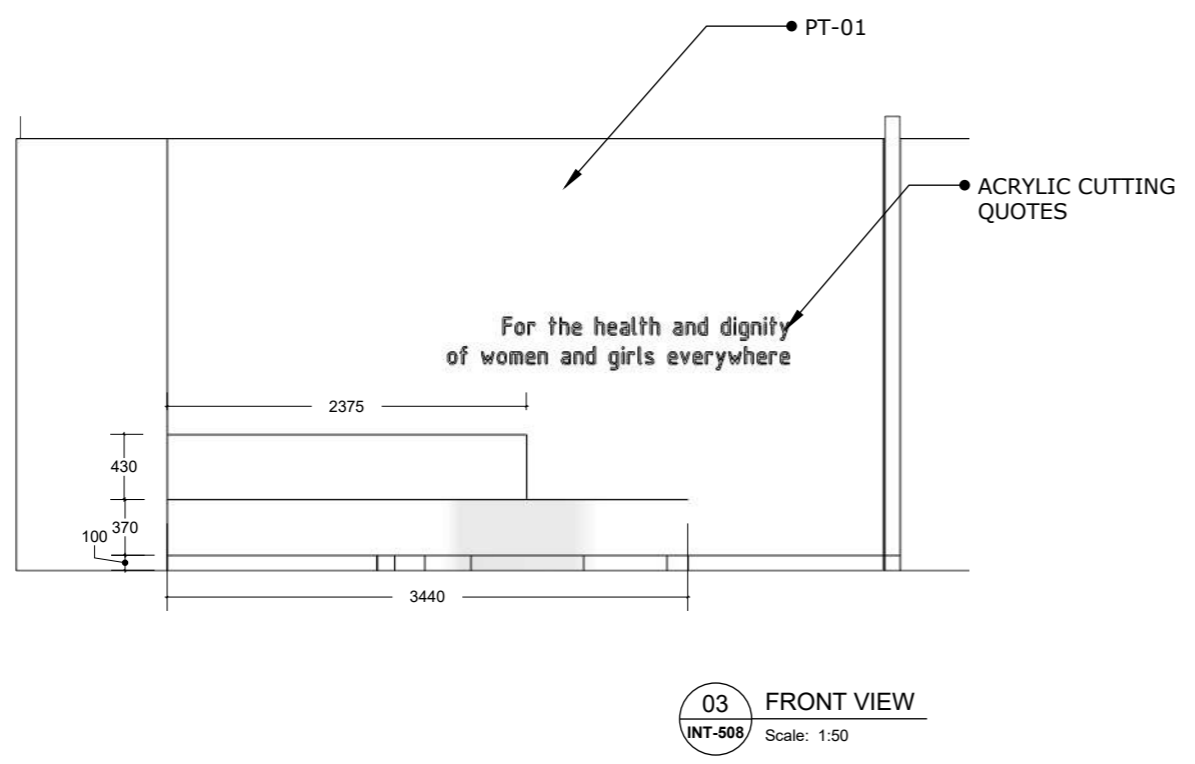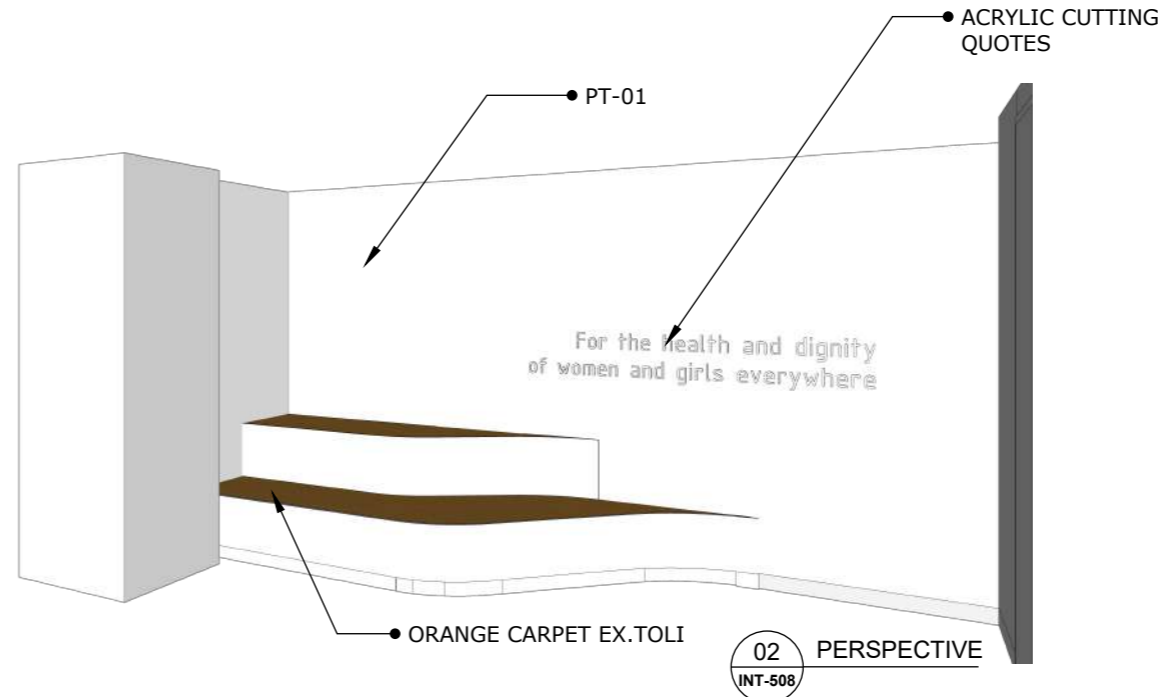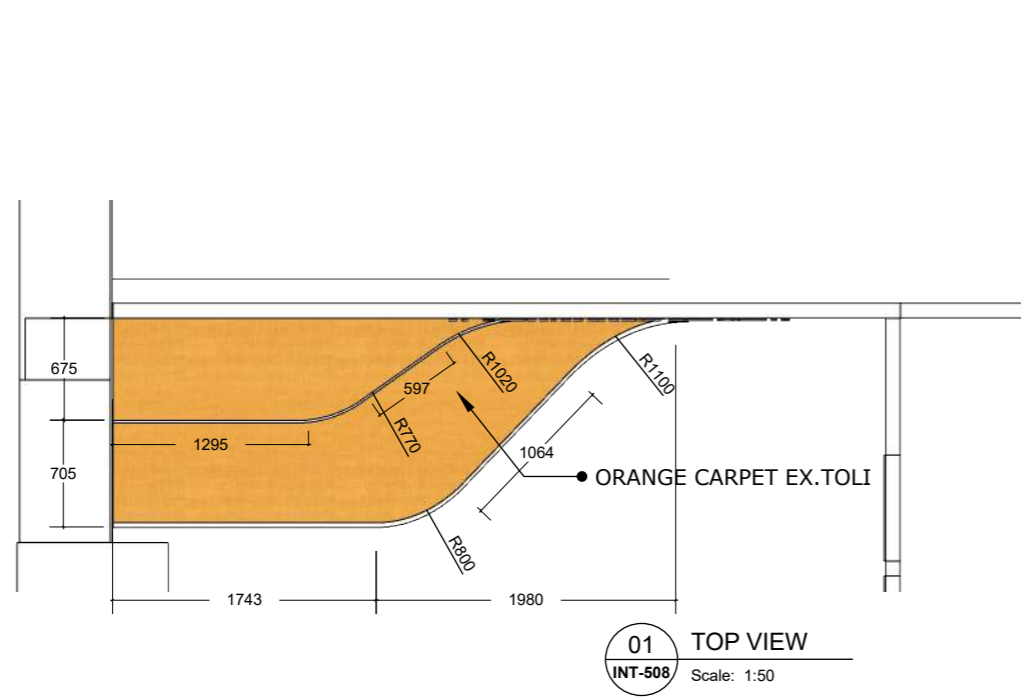


- △WEX : EXISTING MATERIAL
 - △PT.01 : WALLPAIN WHITE COLOR
ex. DULUX TYPE COTTON FANTASY
 - △PT.02 : WALLPAIN ORANGE COLOR
ex. DULUX, TYPE MARI GOLD BLOSSOM
 - △PT.03 : WALLPAIN LIGHT ORANGE
ex. DULUX, TYPE TOPAZ SPARKLE
 - △HPL.01 : HPL WOOD PATTERN
ex. TACO TH 849 TM ASH AFROMOSIA TIMBER
 - △HPL.02 : HPL WHITE COLOR
ex. TACO CHALK TH 040 AA
 - △HPL.03 : HPL ORANGE COLOR
ex. TACO CLASSIC ORANGE
 - △GL.01 : 12MM CLEAR TEMPERED GLASS
 - △GL.02 : 12MM CLEAR TEMPERED GLASS ORANGE COLOR
 - △GS.01 : 12MM WHITE GLASS STONE
 - △FB.01 : PADED WALL WITH GREY FABRIC FINISH
 - △FB.02 : PADED WALL WITH ORANGE FABRIC FINISH
- ALL WOOD MATERIAL COVER FIRE PROOF & TERMITE TREATMENT

DEZAN STUDIO
 Bintaro Business Centre Building
 Jl. RC Veteran No. 1-1 Bintaro
 Phone: +62 21 7357679
 Fax: +62 21 7433946
 www.dezanstudio.com
 admin@dezanstudio.com


CLIENT	
UNFPA	
PROJECT	
UNFPA OFFICE	
DRAWING TITLE	
DETAIL CF-08 (AMPHITRE AT PANTRY)	
DRAWING No.	REVISION
INT-508	REV A
SCALE 1:50 @A3	CHECKED AN
DATE 05 Februari, 2020	DRAWN TR

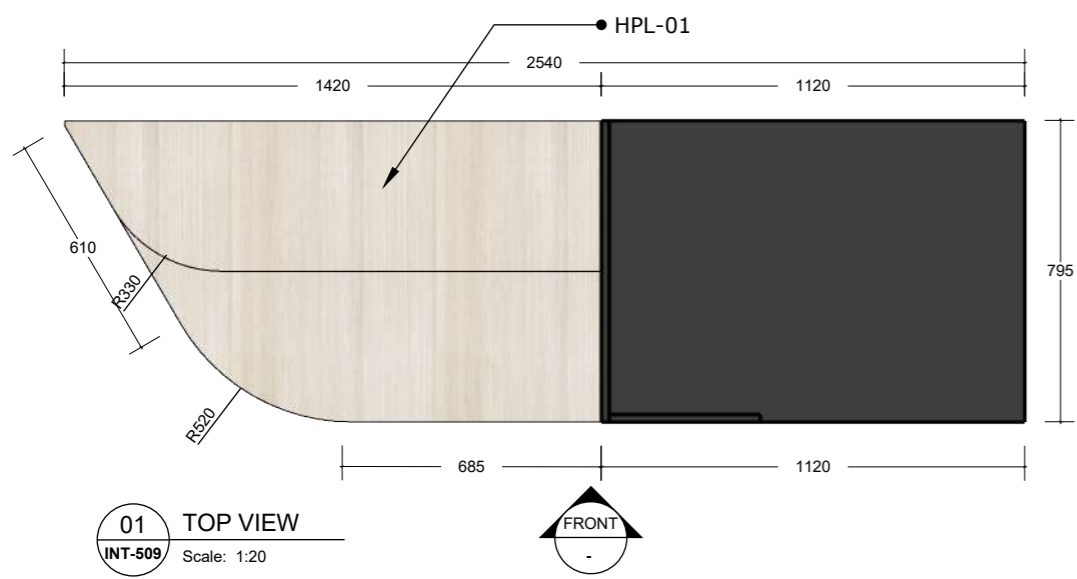


01 TOP VIEW
INT-509 Scale: 1:20

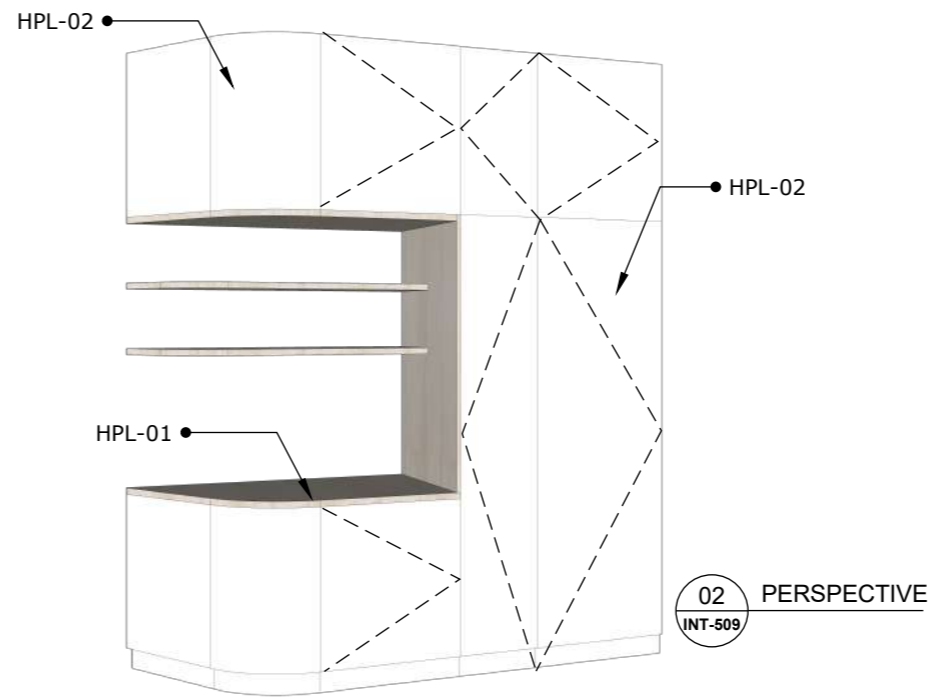


02 PERSPECTIVE
INT-509

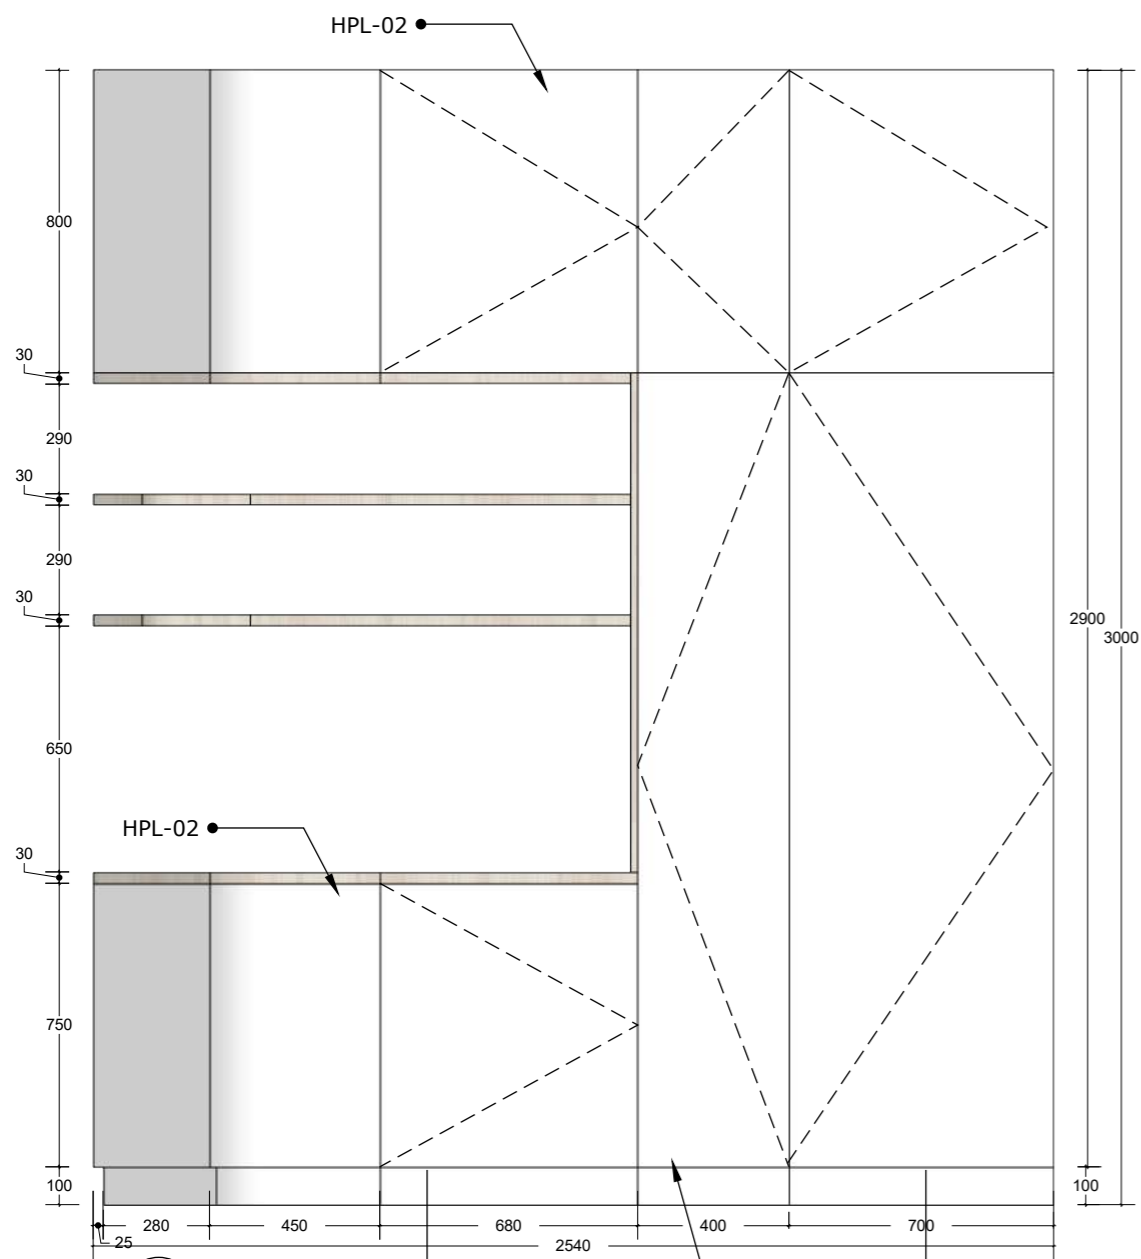

03 FRONT VIEW
INT-509 Scale: 1:20

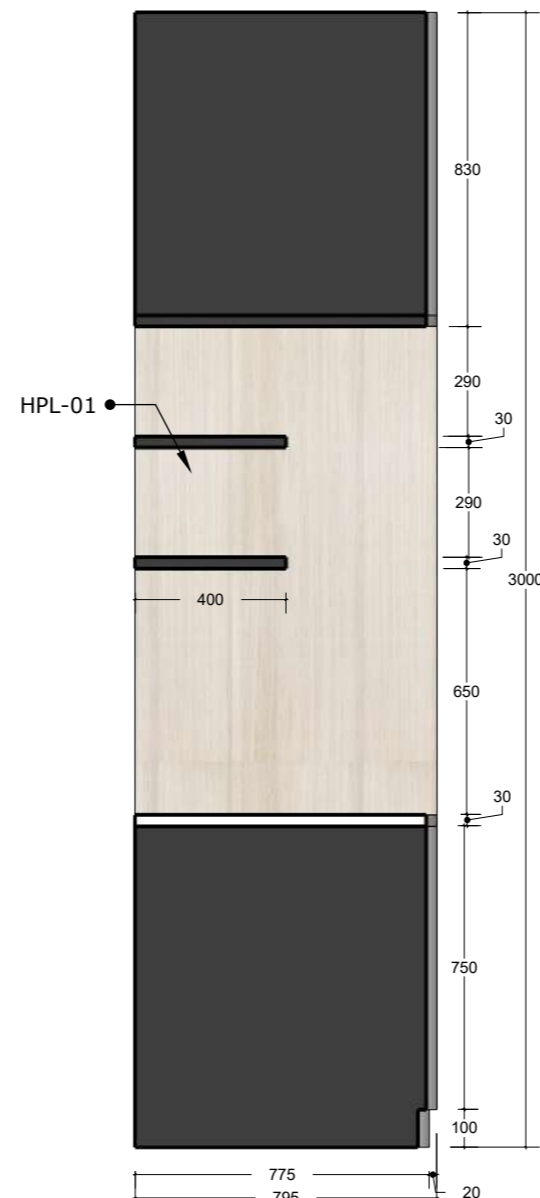

04 SECTION A
INT-509 Scale: 1:20

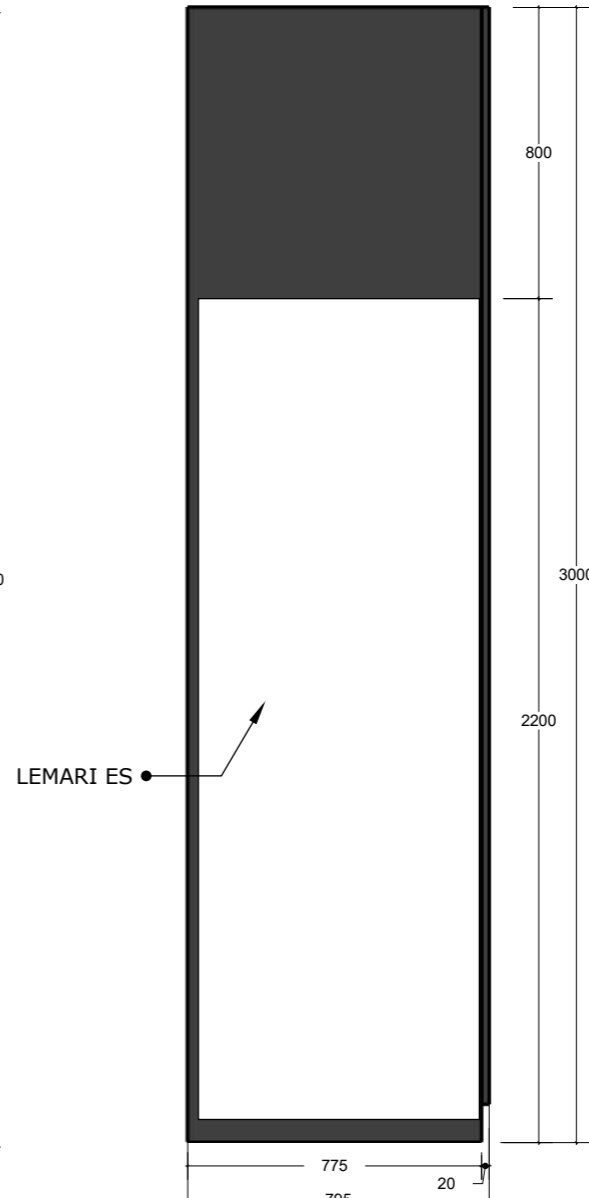

05 SECTION B
INT-509 Scale: 1:20

NOTE :


KEYPLAN

- : EXISTING MATERIAL
- : WALLPAPER WHITE COLOR
ex. DULUX TYPE COTTON FANTASY
- : WALLPAPER ORANGE COLOR
ex. DULUX TYPE MARI GOLD BLOSSOM
- : WALLPAPER LIGHT ORANGE
ex. DULUX TYPE TOPAZ SPARKLE
- : HPL WOOD PATTERN
ex. TACO TH 849 TM ASH AFROMOSIA TIMBER
- : HPL WHITE COLOR
ex. TACO CHALK TH 040 AA
- : HPL ORANGE COLOR
ex. TACO CLASSIC ORANGE
- : 12MM CLEAR TEMPERED GLASS
- : 12MM CLEAR TEMPERED GLASS ORANGE COLOR
- : 12MM WHITE GLASS STONE
- : PADED WALL WITH GREY FABRIC FINISH
- : PADED WALL WITH ORANGE FABRIC FINISH


ALL WOOD MATERIAL COVER FIRE PROOF & TERMITE TREATMENT

DEZAN STUDIO
Bintaro Business Centre Building
Jl. RC Veteran No. 1-1 Bintaro
Phone: +62 21 7357679
Fax: +62 21 7433946
www.dezanstudio.com
admin@dezanstudio.com


CLIENT	
UNFPA	
PROJECT	
UNFPA OFFICE	
DRAWING TITLE	
DETAIL CF-09 (PANTRY)	
DRAWING No.	REVISION
INT-509	REV A
SCALE 1:20 @A3	CHECKED AN
DATE 05 Februari, 2020	DRAWN TR

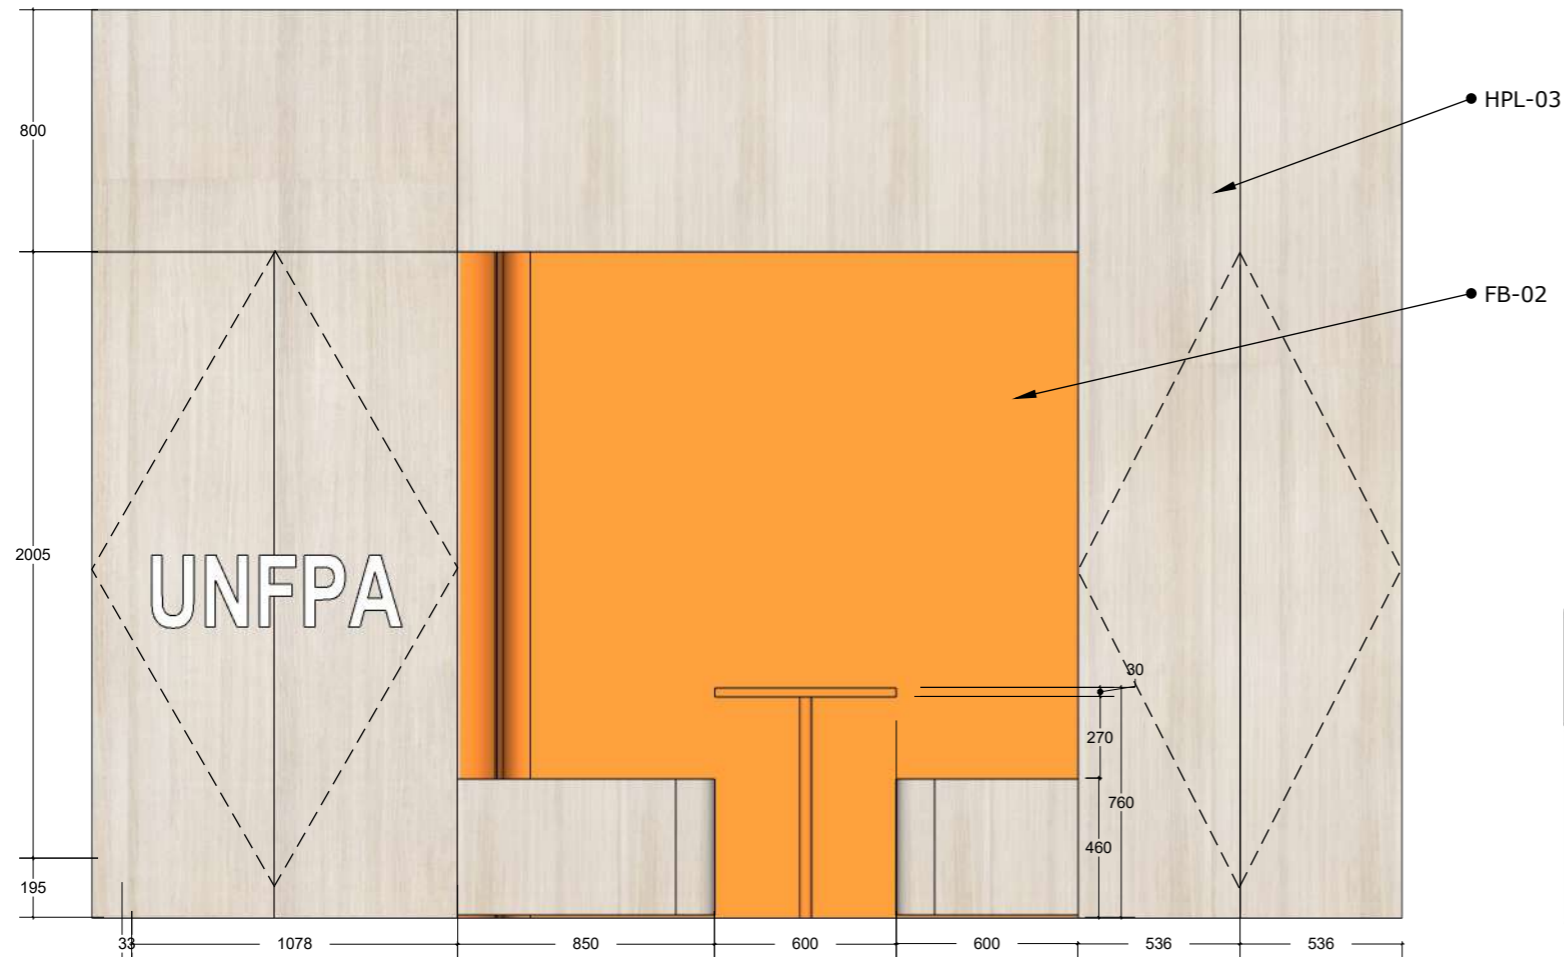

01 FRONT VIEW
INT-510 Scale: 1:50

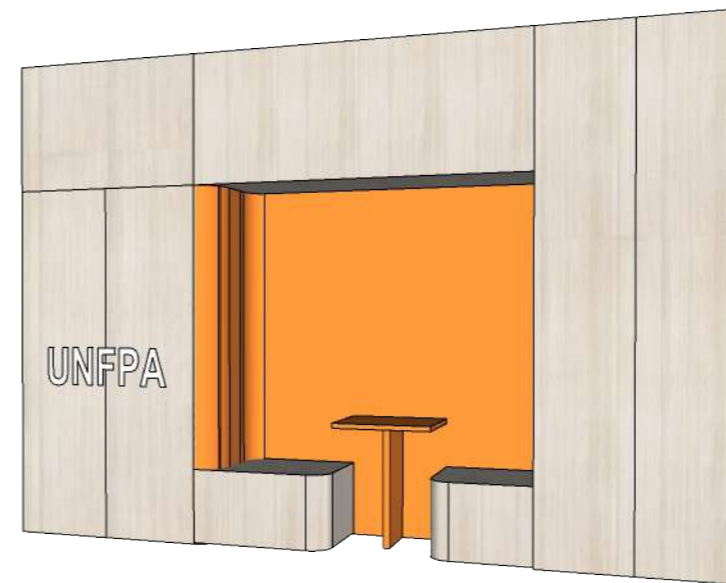

02 PERSPECTIVE
INT-510

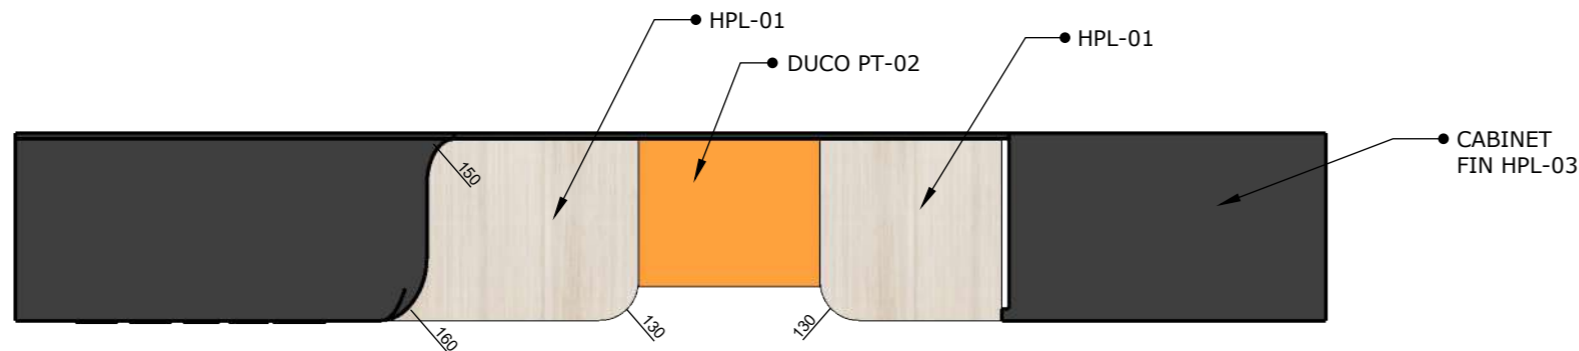

03 TOP VIEW
INT-510 Scale: 1:50


NOTE :




- : EXISTING MATERIAL
 - : WALLPAINT WHITE COLOR
ex. DULUX TYPE COTTON FANTASY
 - : WALLPAINT ORANGE COLOR
ex. DULUX, TYPE MARIGOLD BLOSSOM
 - : WALLPAINT LIGHT ORANGE
ex. DULUX, TYPE TOPAZ SPARKLE
 - : HPL WOOD PATTERN
ex. TACO TH 849 TM ASH AFROMOSIA TIMBER
 - : HPL WHITE COLOR
ex. TACO CHALK TH 040 AA
 - : HPL ORANGE COLOR
ex. TACO CLASSIC ORANGE
 - : 12MM CLEAR TEMPERED GLASS
 - : 12MM CLEAR TEMPERED GLASS ORANGE COLOR
 - : 12MM WHITE GLASS STONE
 - : PADED WALL WITH GREY FABRIC FINISH
 - : PADED WALL WITH ORANGE FABRIC FINISH
- ALL WOOD MATERIAL COVER FIRE PROOF & TERMITE TREATMENT

DEZAN STUDIO
Bintaro Business Centre Building
Jl. RC Veteran No. 1-1 Bintaro
Phone: +62 21 7357679
Fax: +62 21 7433946
www.dezanstudio.com
admin@dezanstudio.com


CLIENT	
UNFPA	
PROJECT	
UNFPA OFFICE	
DRAWING TITLE	
DETAIL CF-10 (CABINET & DISCUSS SPACE)	
DRAWING No.	REVISION
INT-510	REV A
SCALE 1:50 @A3	CHECKED AN
DATE 05 Februari, 2020	DRAWN TR

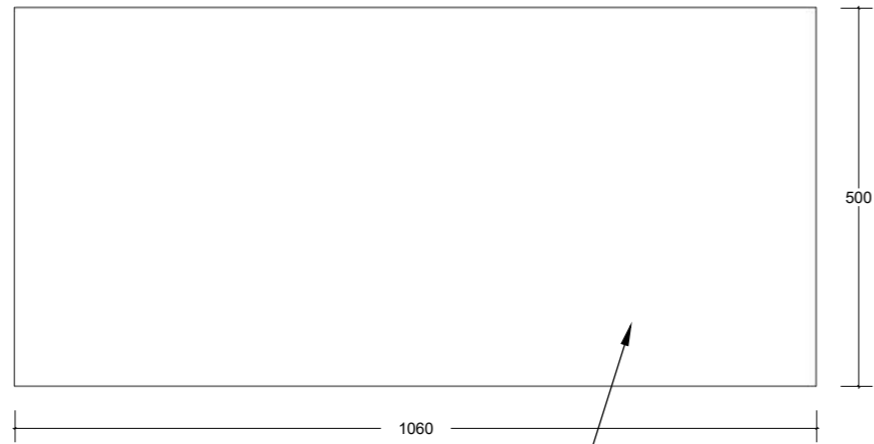


01 TOP VIEW
INT-512 Scale: 1:10

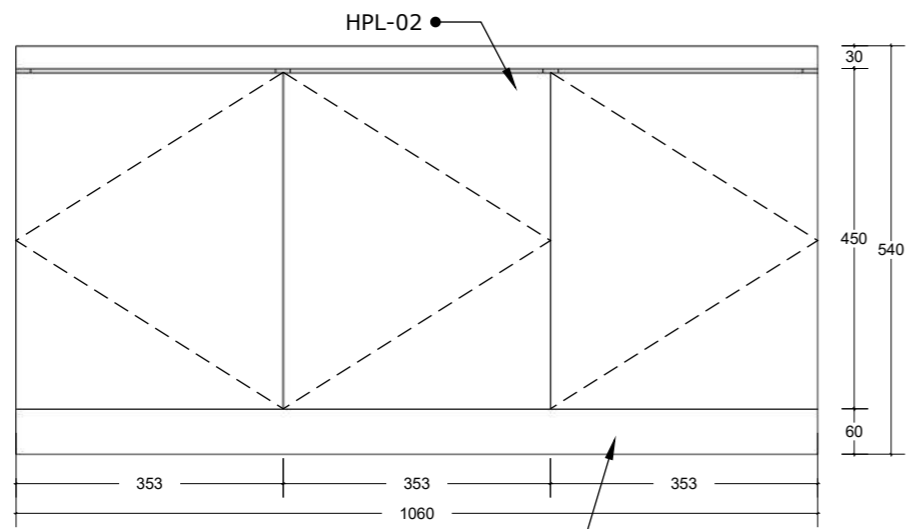


03 FRONT VIEW
INT-512 Scale: 1:10

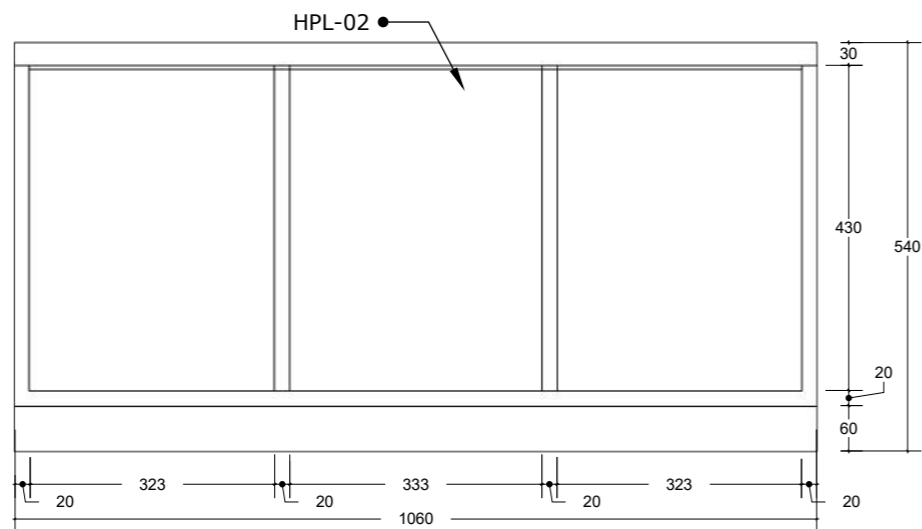

04 FRONT VIEW WITHOUT DOOR
INT-512 Scale: 1:10

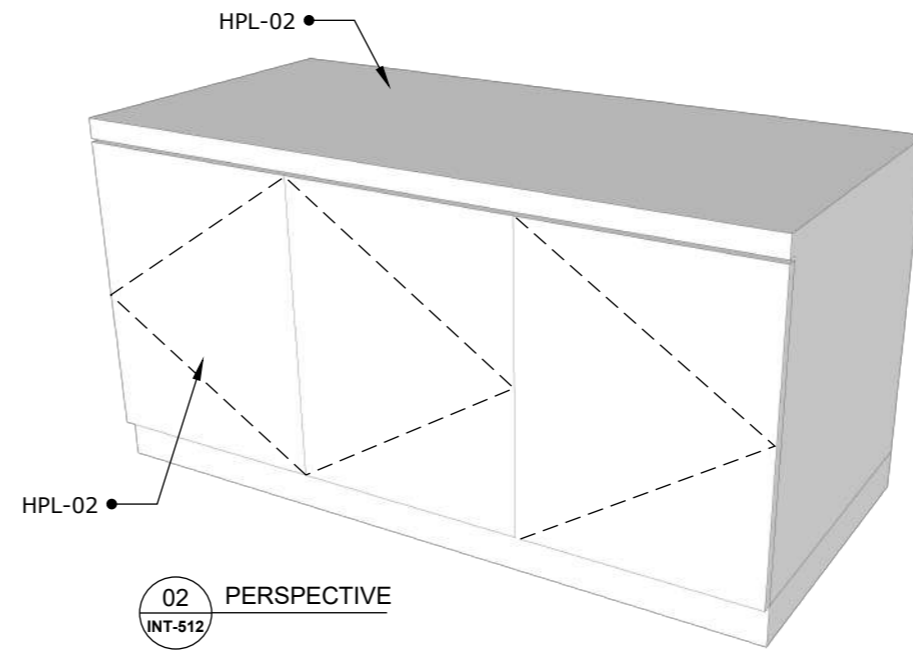

02 PERSPECTIVE
INT-512

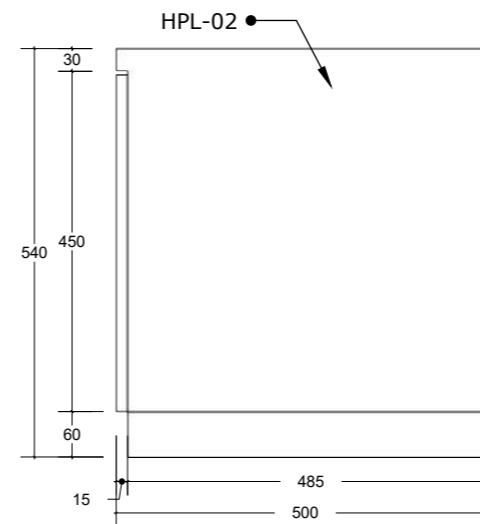

05 RIGHT VIEW
INT-512 Scale: 1:10

NOTE :



- : EXISTING MATERIAL
 - : WALLPAINT WHITE COLOR
ex. DULUX TYPE COTTON FANTASY
 - : WALLPAINT ORANGE COLOR
ex. DULUX, TYPE MARIGOLD BLOSSOM
 - : WALLPAINT LIGHT ORANGE
ex. DULUX, TYPE TOPAZ SPARKLE
 - : HPL WOOD PATTERN
ex. TACO TH 849 TM ASH AFROMOSIA TIMBER
 - : HPL WHITE COLOR
ex. TACO CHALK TH 040 AA
 - : HPL ORANGE COLOR
ex. TACO CLASSIC ORANGE
 - : 12MM CLEAR TEMPERED GLASS
 - : 12MM CLEAR TEMPERED GLASS ORANGE COLOR
 - : 12MM WHITE GLASS STONE
 - : PADED WALL WITH GREY FABRIC FINISH
 - : PADED WALL WITH ORANGE FABRIC FINISH
- ALL WOOD MATERIAL, COVER FIRE PROOF & TERMITE TREATMENT

DEZAN STUDIO
 Bintaro Business Centre Building
 Jl. RC Veteran No. 1-1 Bintaro
 Phone: +62 21 7357679
 Fax: +62 21 7433946
 www.dezanstudio.com
 admin@dezanstudio.com

CLIENT

UNFPA


PROJECT

UNFPA OFFICE

DRAWING TITLE

DETAIL CF-12
(CABINET WORKSTATION)


DRAWING No.	REVISION
INT-512	REV A
SCALE 1:20 @A3	CHECKED AN
DATE 05 Februari, 2020	DRAWN TR

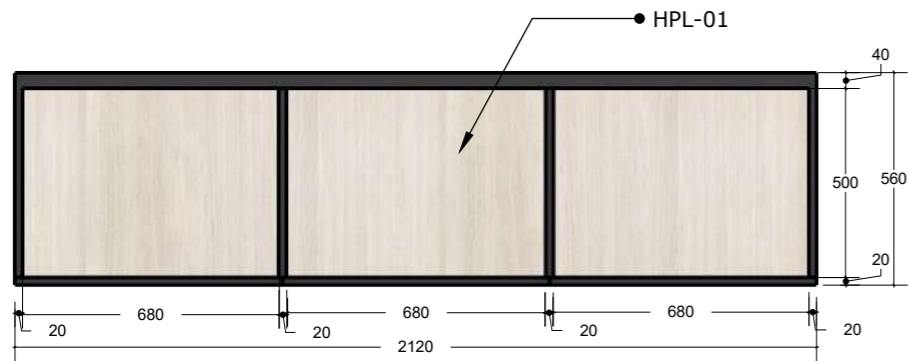


01 SECTION X
INT-513 Scale: 1:20




02 PERSPECTIVE
INT-513

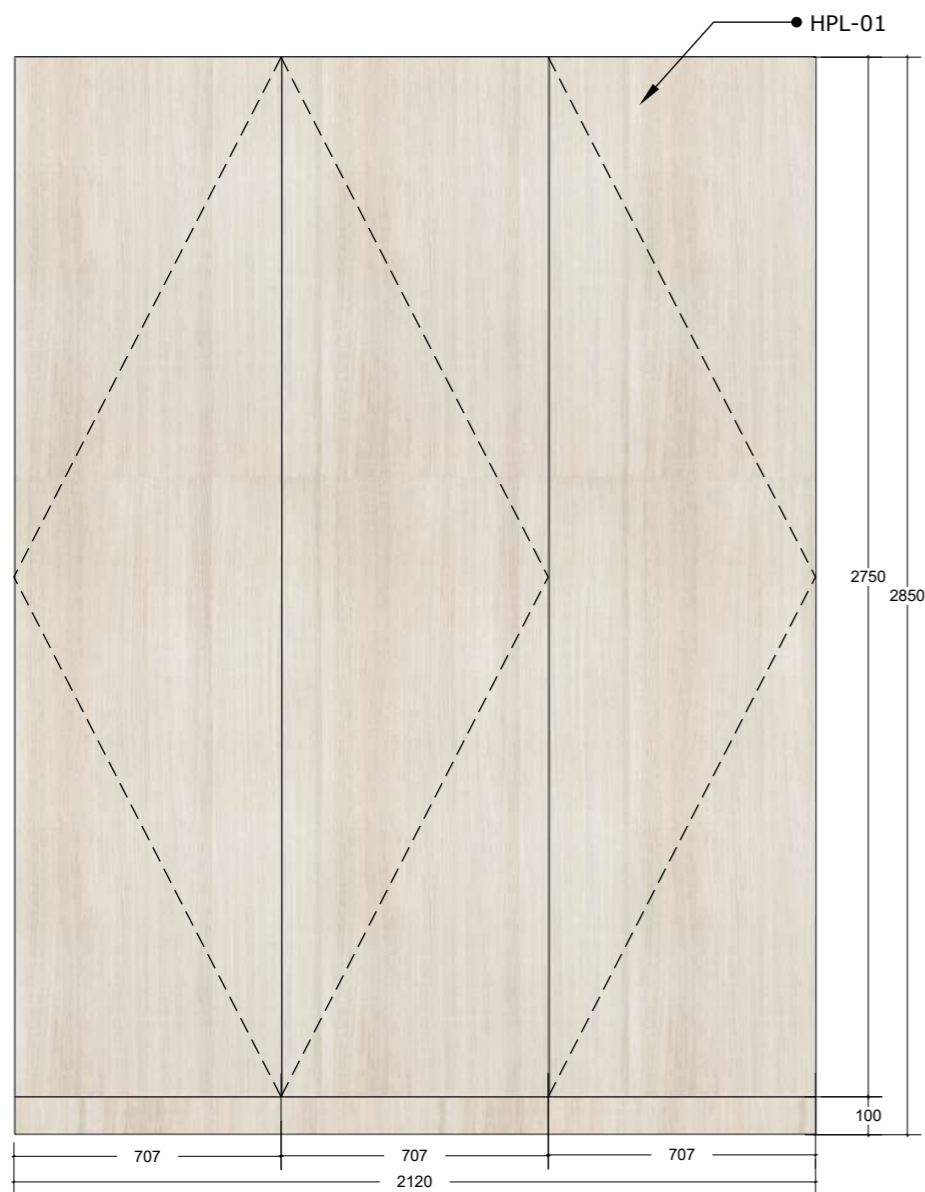

03 FRONT VIEW
INT-513 Scale: 1:20

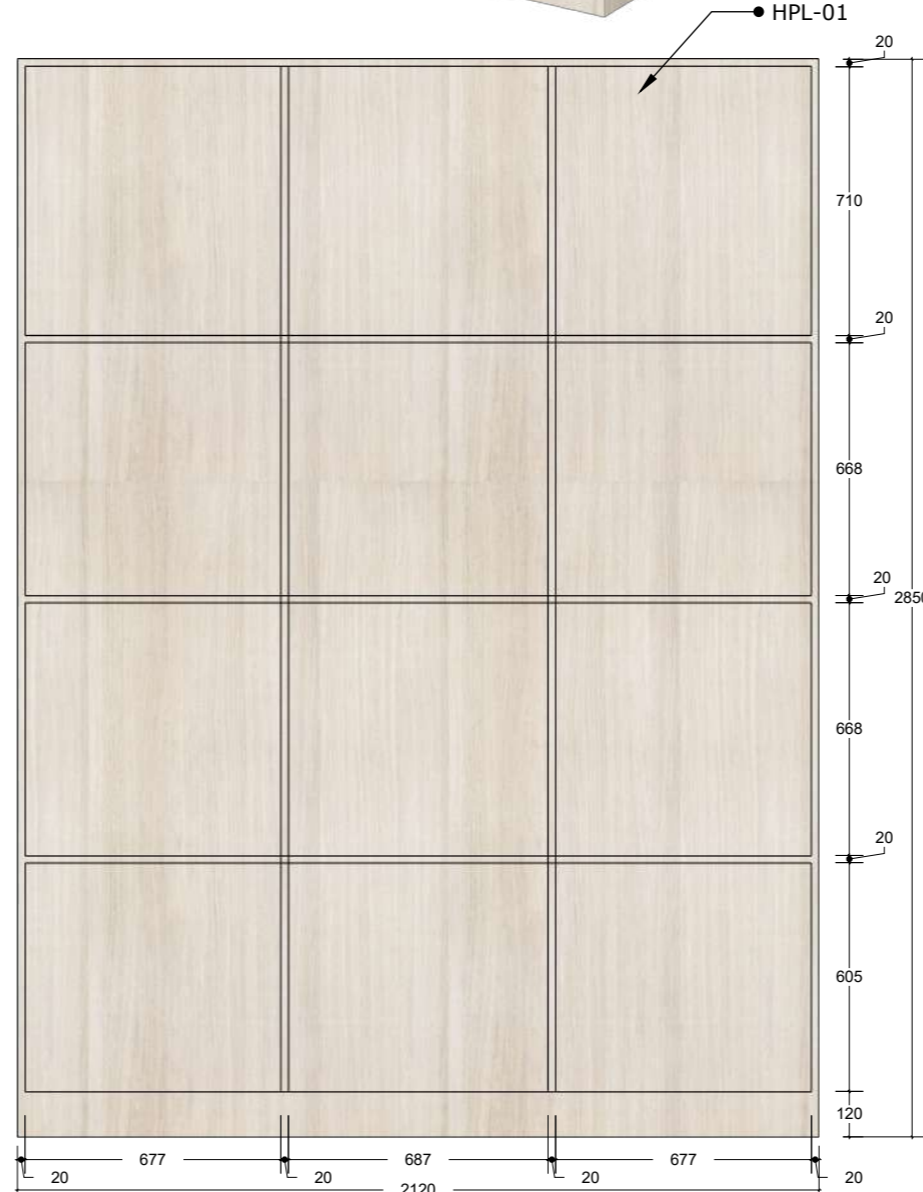


04 FRONT VIEW WITHOUT DOOR
INT-513 Scale: 1:20

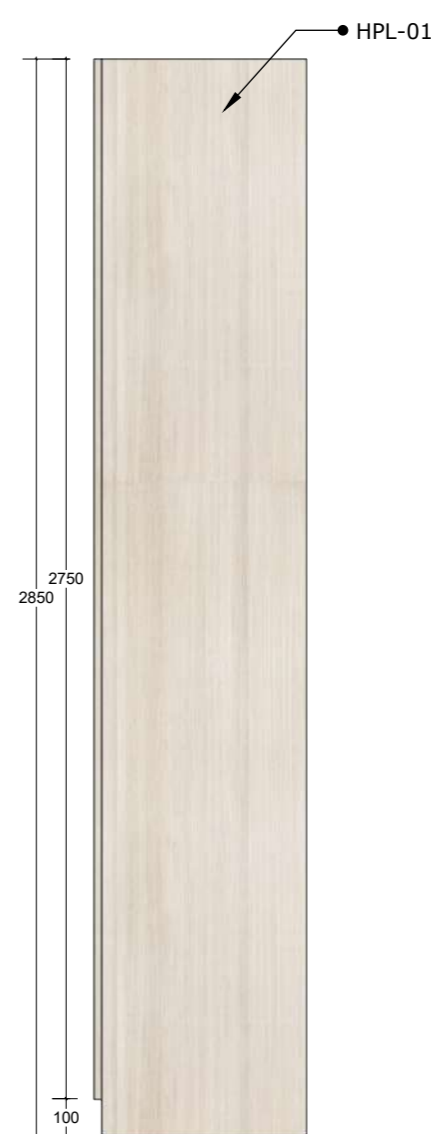

05 RIGHT VIEW
INT-513 Scale: 1:20

NOTE :

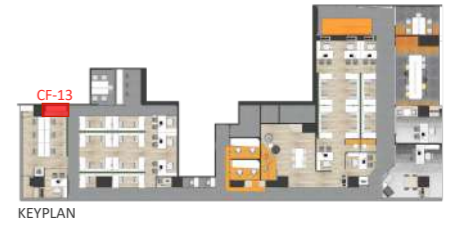

- : EXISTING MATERIAL
 - : WALLPAINT WHITE COLOR
ex. DULUX TYPE COTTON FANTASY
 - : WALLPAINT ORANGE COLOR
ex. DULUX, TYPE MARIGOLD BLOSSOM
 - : WALLPAINT LIGHT ORANGE
ex. DULUX, TYPE TOPAZ SPARKLE
 - : HPL WOOD PATTERN
ex. TACO TH 849 TM ASH AFROMOSIA TIMBER
 - : HPL WHITE COLOR
ex. TACO CHALK TH 040 AA
 - : HPL ORANGE COLOR
ex. TACO CLASSIC ORANGE
 - : 12MM CLEAR TEMPERED GLASS
 - : 12MM CLEAR TEMPERED GLASS ORANGE COLOR
 - : 12MM WHITE GLASS STONE
 - : PADED WALL WITH GREY FABRIC FINISH
 - : PADED WALL WITH ORANGE FABRIC FINISH
- ALL WOOD MATERIAL, COVER FIRE PROOF & TERMITE TREATMENT

DEZAN STUDIO
Bintaro Business Centre Building
Jl. RC Veteran No. 1-1 Bintaro
Phone: +62 21 7357679
Fax: +62 21 7433946
www.dezanstudio.com
admin@dezanstudio.com

CLIENT

UNFPA


PROJECT

UNFPA OFFICE



DRAWING TITLE

DETAIL CF-13
(OPERATIONS ROOM)


DRAWING No.	REVISION
INT-513	REV A
SCALE 1:20 @A3	CHECKED AN
DATE 05 Februari, 2020	DRAWN TR

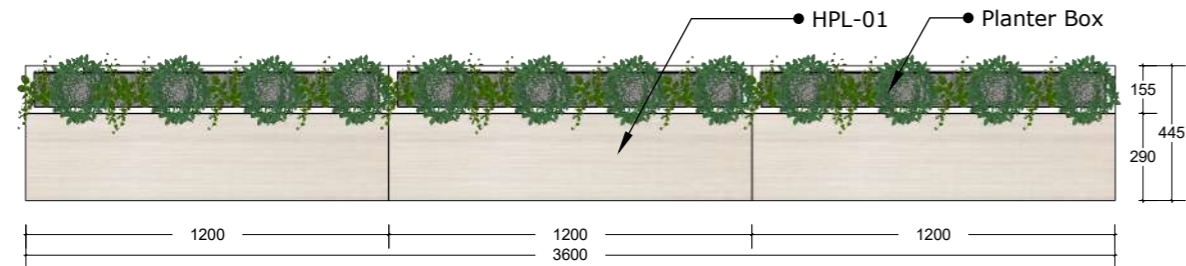


01 TOP VIEW
INT-514 Scale: 1:25

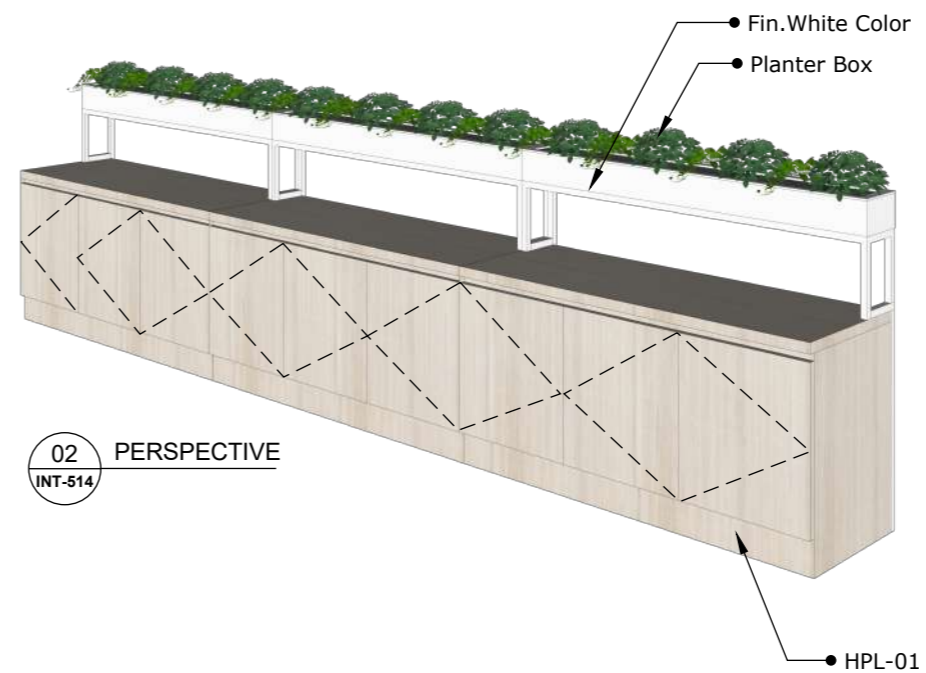 


02 PERSPECTIVE
INT-514

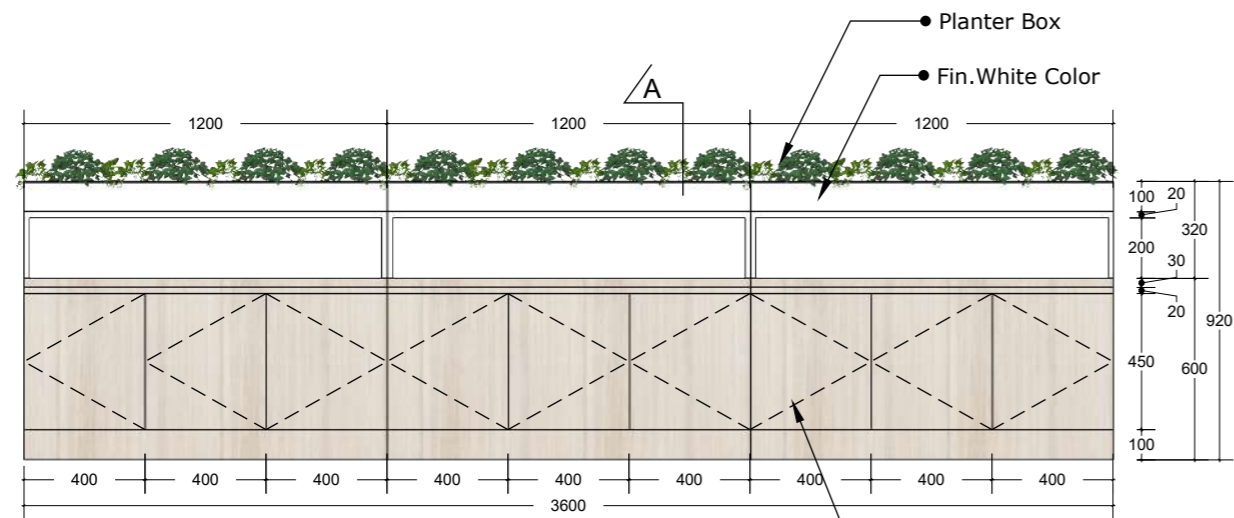

03 FRONT VIEW
INT-514 Scale: 1:25

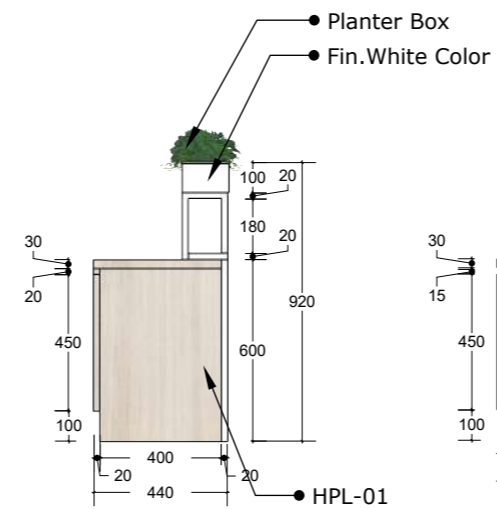

04 RIGHT VIEW
INT-514 Scale: 1:25

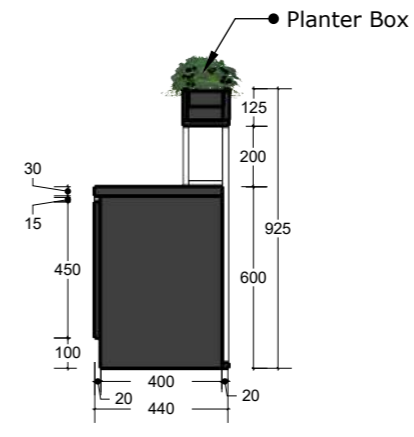

05 SECTION A
INT-514 Scale: 1:25

NOTE :



- : EXISTING MATERIAL
 - : WALLPAPER WHITE COLOR
ex. DULUX TYPE COTTON FANTASY
 - : WALLPAPER ORANGE COLOR
ex. DULUX TYPE MARIGOLD BLOSSOM
 - : WALLPAPER LIGHT ORANGE
ex. DULUX TYPE TOPAZ SPARKLE
 - : HPL WOOD PATTERN
ex. TACO TH 849 TM ASH AFROMOSIA TIMBER
 - : HPL WHITE COLOR
ex. TACO CHALK TH 040 AA
 - : HPL ORANGE COLOR
ex. TACO CLASSIC ORANGE
 - : 12MM CLEAR TEMPERED GLASS
 - : 12MM CLEAR TEMPERED GLASS ORANGE COLOR
 - : 12MM WHITE GLASS STONE
 - : PADED WALL WITH GREY FABRIC FINISH
 - : PADED WALL WITH ORANGE FABRIC FINISH
- ALL WOOD MATERIAL COVER FIRE PROOF & TERMITE TREATMENT

DEZAN STUDIO
Bintaro Business Centre Building
Jl. RC Veteran No. 1-1 Bintaro
Phone: +62 21 7357679
Fax: +62 21 7433946
www.dezanstudio.com
admin@dezanstudio.com

CLIENT

UNFPA







PROJECT

UNFPA OFFICE

DRAWING TITLE

DETAIL CF-14
(OPERATIONS ROOM)


DRAWING No.	REVISION
INT-514	REV A
SCALE 1:25 @A3	CHECKED AN
DATE 05 Februari, 2020	DRAWN TR

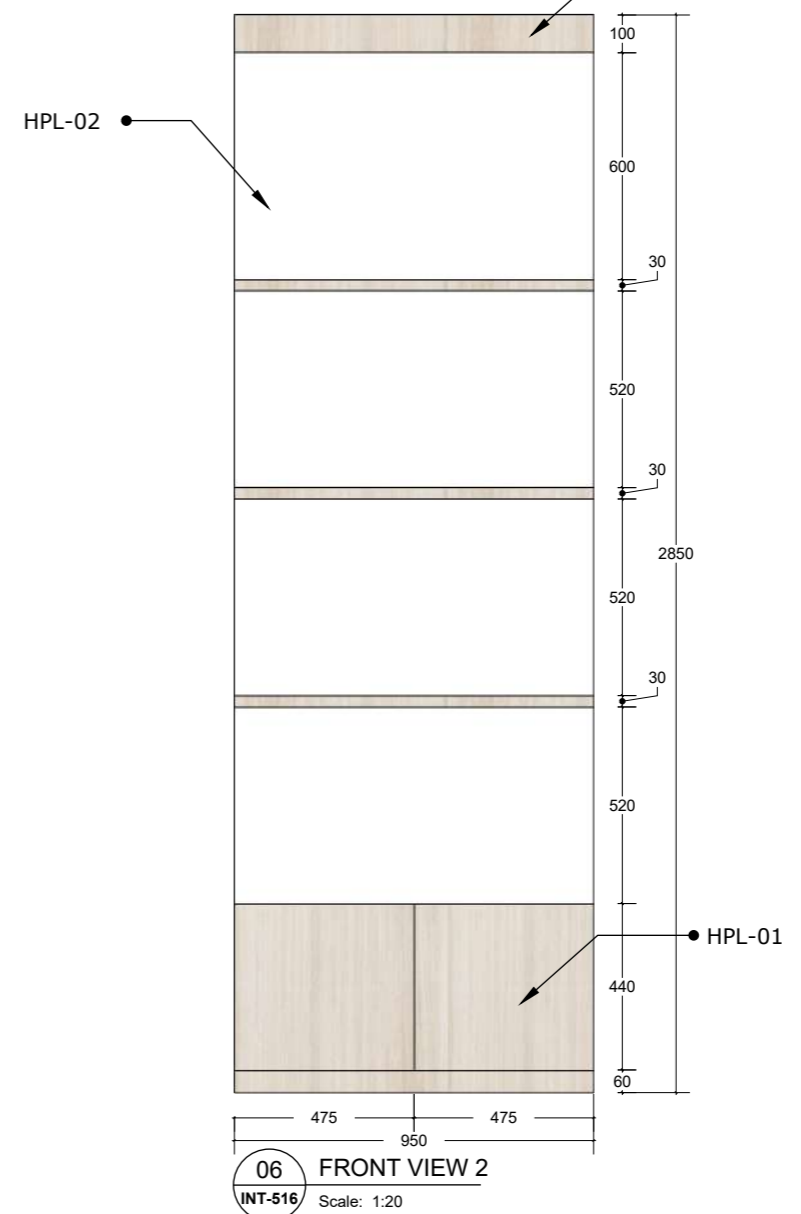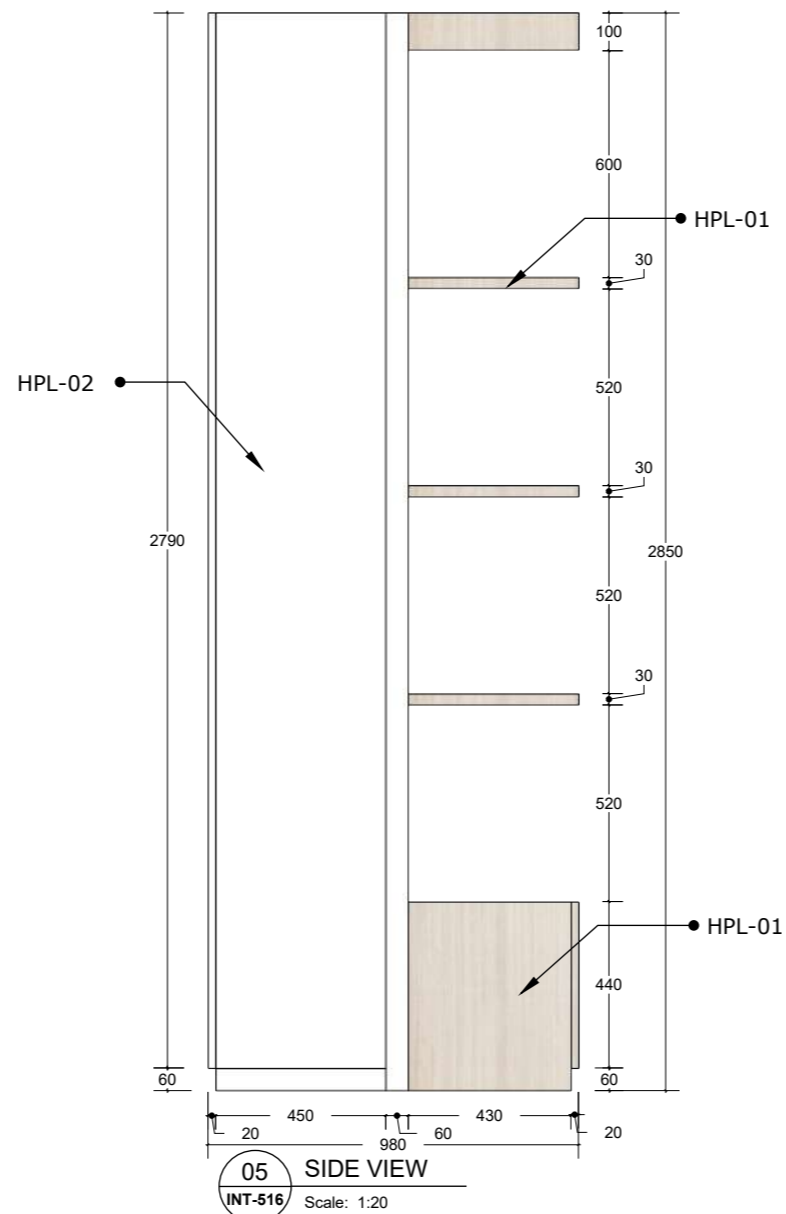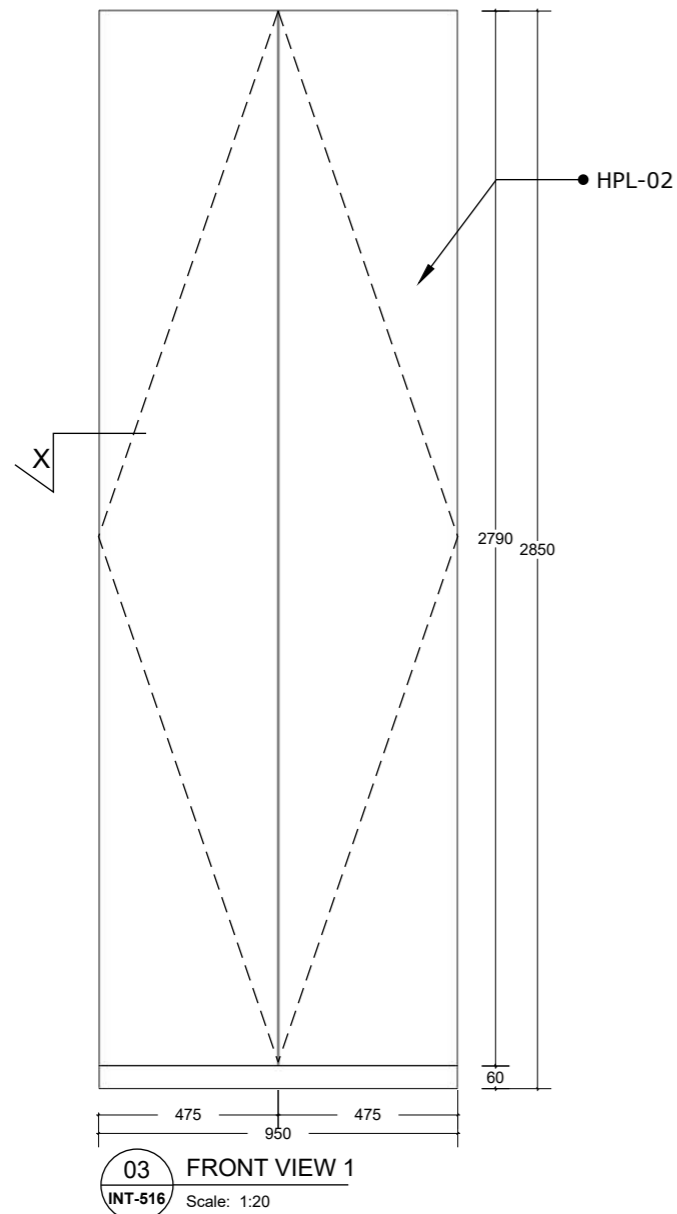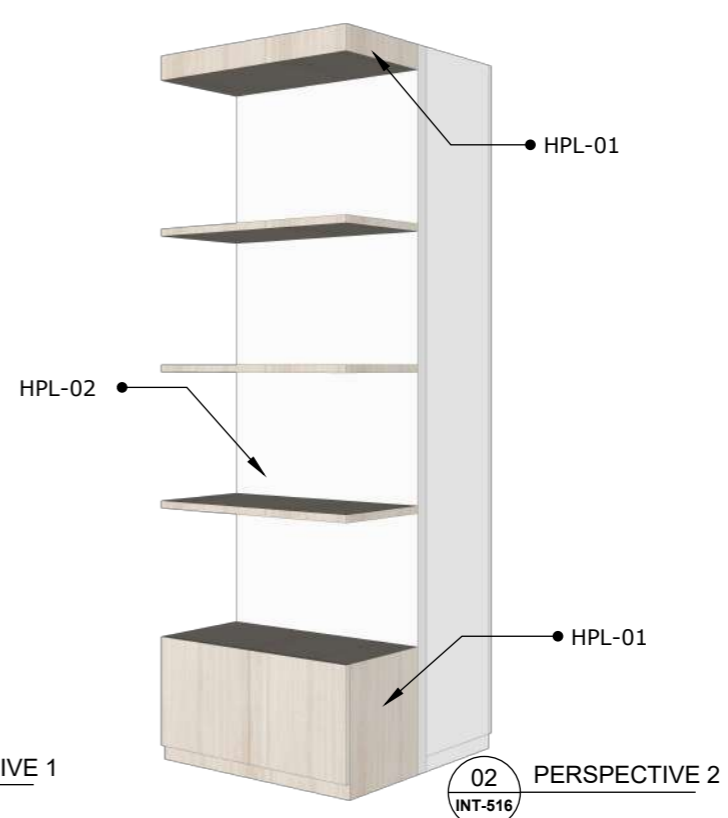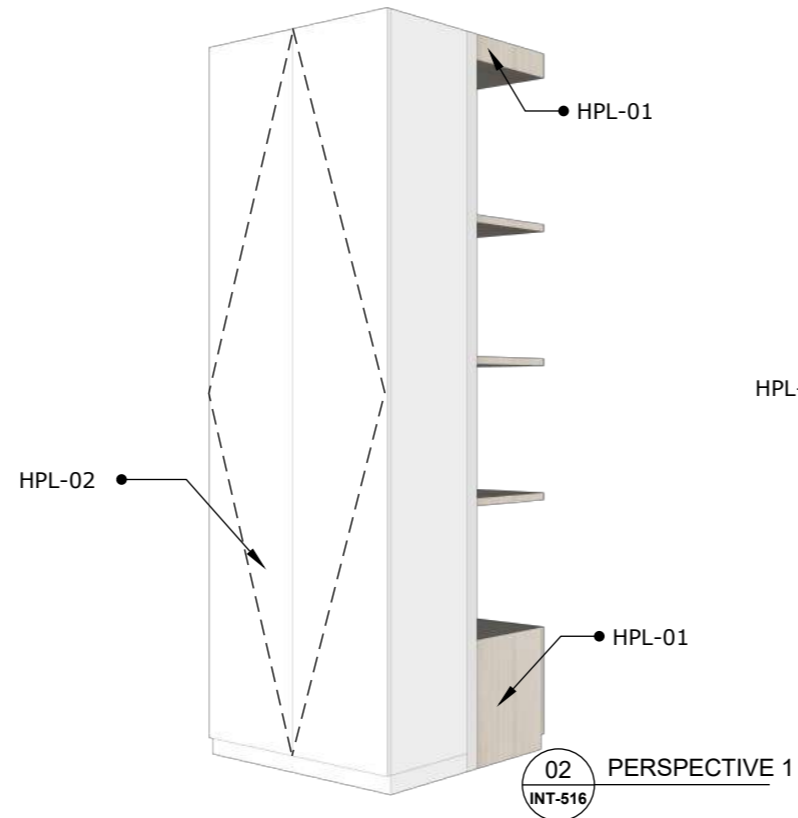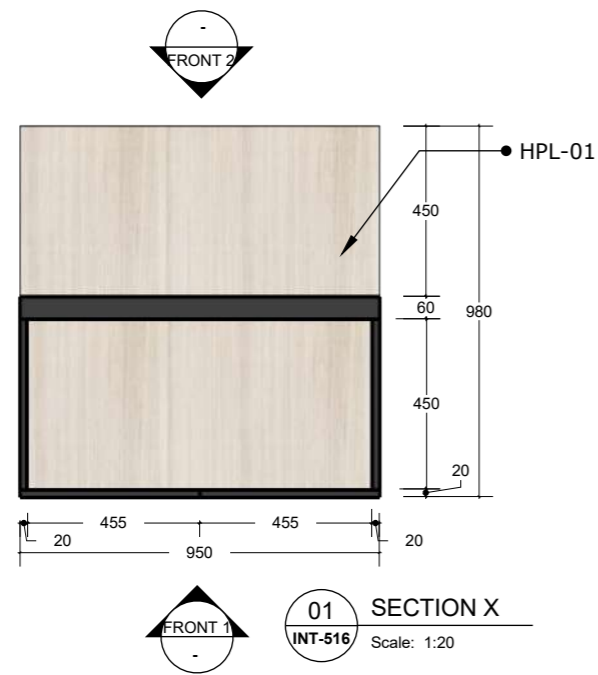


- △EX: EXISTING MATERIAL
 - △PT.01: WALLPAINT WHITE COLOR
ex. DULUX TYPE COTTON FANTASY
 - △PT.02: WALLPAINT ORANGE COLOR
ex. DULUX TYPE MARIGOLD BLOSSOM
 - △PT.03: WALLPAINT LIGHT ORANGE
ex. DULUX TYPE TOPAZ SPARKLE
 - △HPL.01: HPL WOOD PATTERN
ex. TACO TH 849 TM ASH AFROMOSIA TIMBER
 - △HPL.02: HPL WHITE COLOR
ex. TACO CHALK TH 040 AA
 - △HPL.03: HPL ORANGE COLOR
ex. TACO CLASSIC ORANGE
 - △GL-01: 12MM CLEAR TEMPERED GLASS
 - △GL-02: 12MM CLEAR TEMPERED GLASS ORANGE COLOR
 - △GS-01: 12MM WHITE GLASS STONE
 - △FB-01: PADED WALL WITH GREY FABRIC FINISH
 - △FB-02: PADED WALL WITH ORANGE FABRIC FINISH
- ALL WOOD MATERIAL COVER FIRE PROOF & TERMITE TREATMENT

DEZAN
 STUDIO
 Bintaro Business Centre Building
 Jl. RC Veteran No. 1-1 Bintaro
 Phone: +62 21 7357679
 Fax: +62 21 7433946
 www.dezanstudio.com
 admin@dezanstudio.com


CLIENT	
UNFPA	
PROJECT	
UNFPA OFFICE	
DRAWING TITLE	
DETAIL CF-16 (OPERATIONS ROOM)	
DRAWING No.	REVISION
INT-516	REV A
SCALE 1:20 @A3	CHECKED AN
DATE 05 Februari, 2020	DRAWN TR

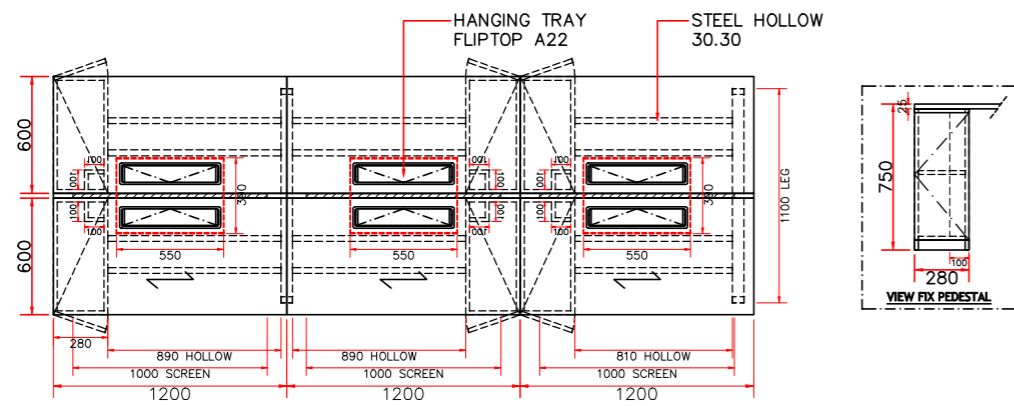


TOP VIEW
INT-517

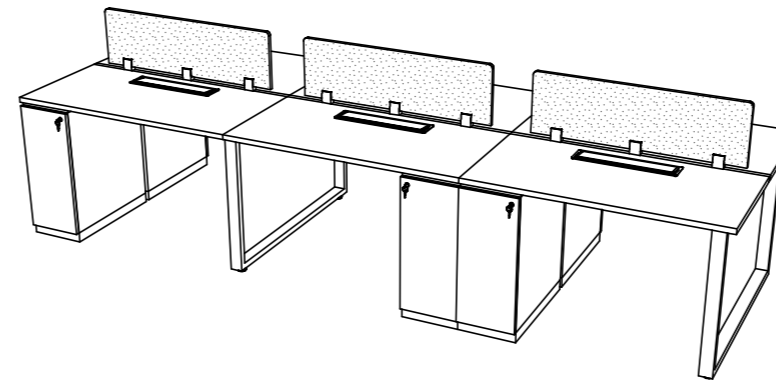



PERSPECTIVE
INT-517

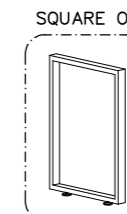


* PB HPL TACO

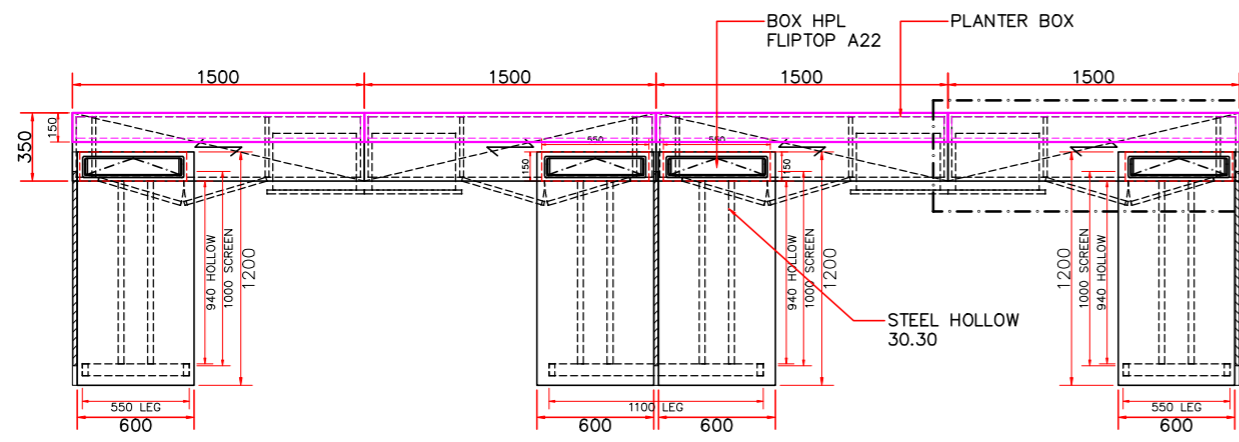

FRONT VIEW
INT-517

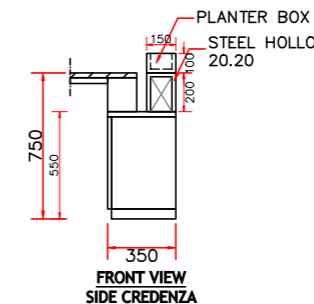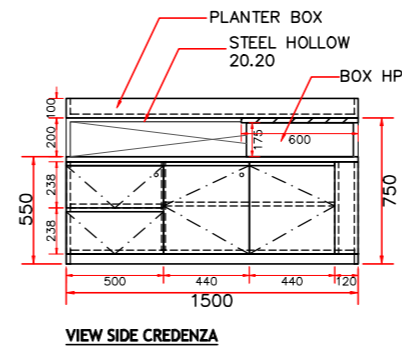

SIDE VIEW
INT-517

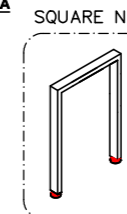

* PB HPL TACO

NOTE :



KEYPLAN

- △WEX : EXISTING MATERIAL
 - △PT.01 : WALLPAINT WHITE COLOR
ex. DULUX TYPE COTTON FANTASY
 - △PT.02 : WALLPAINT ORANGE COLOR
ex. DULUX TYPE MARIGOLD BLOSSOM
 - △PT.03 : WALLPAINT LIGHT ORANGE
ex. DULUX TYPE TOPAZ SPARKLE
 - △HPL.01 : HPL WOOD PATTERN
ex. TACO TH 849 TM ASH AFROMOSIA TIMBER
 - △HPL.02 : HPL WHITE COLOR
ex. TACO CHALK TH 040 AA
 - △HPL.03 : HPL ORANGE COLOR
ex. TACO CLASSIC ORANGE
 - △GL-01 : 12MM CLEAR TEMPERED GLASS
 - △GL-02 : 12MM CLEAR TEMPERED GLASS ORANGE COLOR
 - △GS-01 : 12MM WHITE GLASS STONE
 - △FB-01 : PADED WALL WITH GREY FABRIC FINISH
 - △FB-02 : PADED WALL WITH ORANGE FABRIC FINISH
- ALL WOOD MATERIAL COVER FIRE PROOF & TERMITE TREATMENT

DEZAN STUDIO
Bintaro Business Centre Building
Jl. RC Veteran No. 1-1 Bintaro
Phone: +62 21 7357679
Fax: +62 21 7433946
www.dezanstudio.com
admin@dezanstudio.com

CLIENT

UNFPA


PROJECT

UNFPA OFFICE


DRAWING TITLE

DETAIL TB-17
(OPERATIONS ROOM)

DRAWING No.	REVISION
INT-517	REV A
SCALE 1:20 @A3	CHECKED AN
DATE 05 Februari, 2020	DRAWN TR

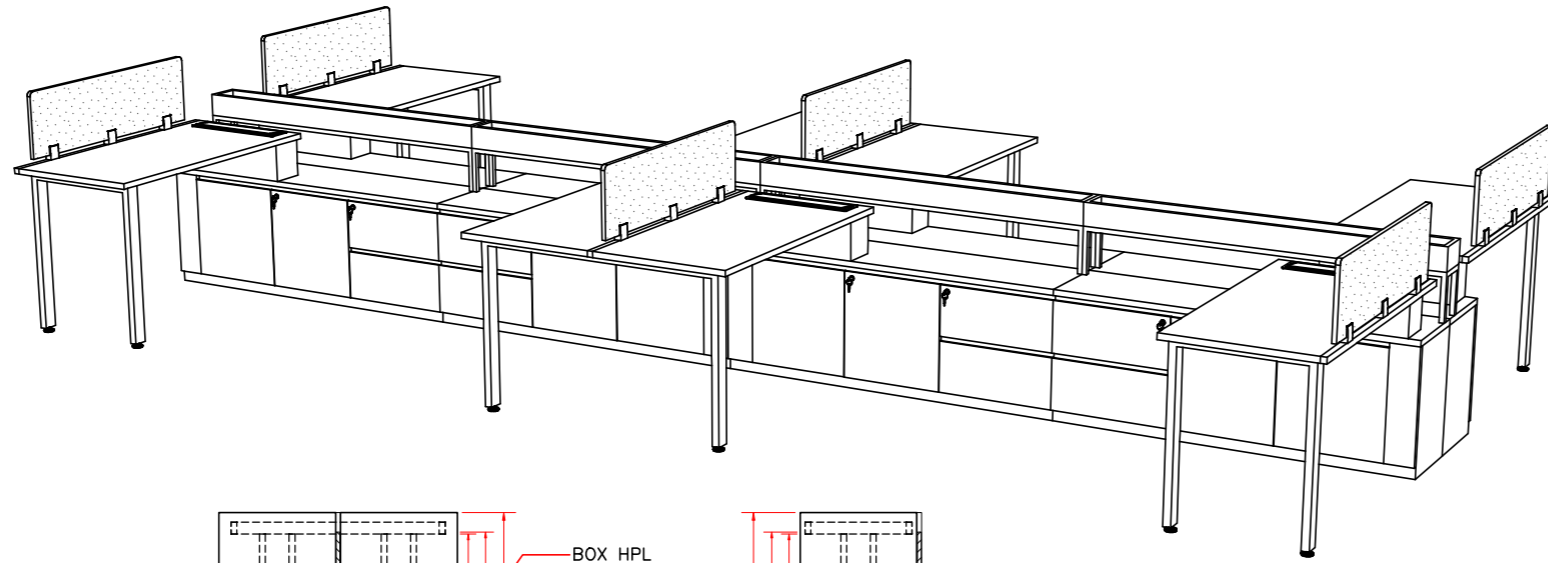


PERSPECTIVE
INT-518

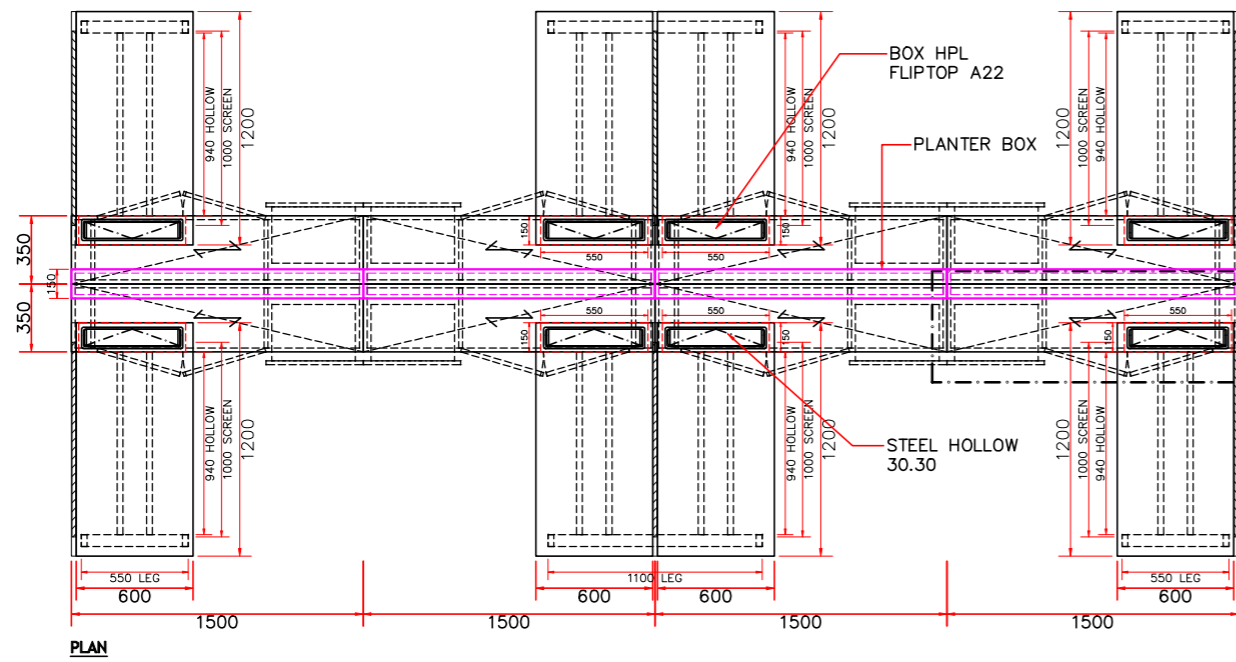


* PB HPL TACO

TOP VIEW
INT-518

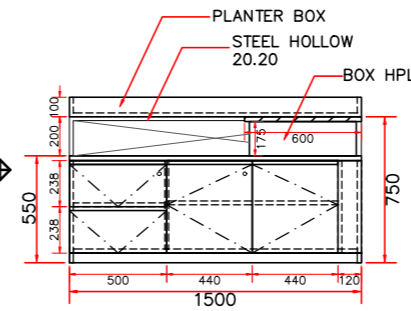


VIEW SIDE CREDENZA

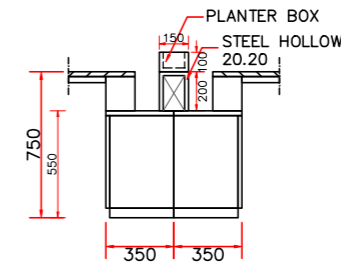

FRONT VIEW
SIDE CREDENZA

SQUARE N

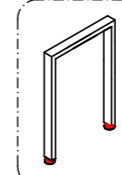

SIDE VIEW
INT-518

NOTE :



KEYPLAN

- : EXISTING MATERIAL
 - : WALLPAINT WHITE COLOR
ex. DULUX TYPE COTTON FANTASY
 - : WALLPAINT ORANGE COLOR
ex. DULUX, TYPE MARIGOLD BLOSSOM
 - : WALLPAINT LIGHT ORANGE
ex. DULUX, TYPE TOPAZ SPARKLE
 - : HPL WOOD PATTERN
ex. TACO TH 849 TM ASH AFROMOSIA TIMBER
 - : HPL WHITE COLOR
ex. TACO CHALK TH 040 AA
 - : HPL ORANGE COLOR
ex. TACO CLASSIC ORANGE
 - : 12MM CLEAR TEMPERED GLASS
 - : 12MM CLEAR TEMPERED GLASS ORANGE COLOR
 - : 12MM WHITE GLASS STONE
 - : PADED WALL WITH GREY FABRIC FINISH
 - : PADED WALL WITH ORANGE FABRIC FINISH
- ALL WOOD MATERIAL COVER FIRE PROOF & TERMITE TREATMENT

DEZAN STUDIO
 Bintaro Business Centre Building
 Jl. RC Veteran No. 1-1 Bintaro
 Phone: +62 21 7357679
 Fax: +62 21 7433946
 www.dezanstudio.com
 admin@dezanstudio.com

CLIENT

UNFPA

PROJECT

UNFPA OFFICE

DRAWING TITLE

DETAIL TB-8
(OPERATIONS ROOM)



DRAWING No.	REVISION
INT-518	REV A
SCALE 1:20 @A3	CHECKED AN
DATE 05 Februari, 2020	DRAWN TR

NOTE :



KEYPLAN




-  : EXISTING MATERIAL
 -  : WALLPAINT WHITE COLOR
ex. DULUX TYPE COTTON FANTASY
 -  : WALLPAINT ORANGE COLOR
ex. DULUX TYPE MARIGOLD BLOSSOM
 -  : WALLPAINT LIGHT ORANGE
ex. DULUX TYPE TOPAZ SPARKLE
 -  : HPL WOOD PATTERN
ex. TACO TH 849 TM ASH AFROMOSIA TIMBER
 -  : HPL WHITE COLOR
ex. TACO CHALK TH 040 AA
 -  : HPL ORANGE COLOR
ex. TACO CLASSIC ORANGE
 -  : 12MM CLEAR TEMPERED GLASS
 -  : 12MM CLEAR TEMPERED GLASS ORANGE COLOR
 -  : 12MM WHITE GLASS STONE
 -  : PADED WALL WITH GREY FABRIC FINISH
 -  : PADED WALL WITH ORANGE FABRIC FINISH
- ALL WOOD MATERIAL COVER FIRE PROOF & TERMITE TREATMENT

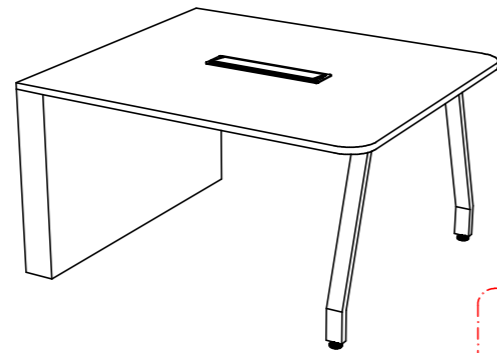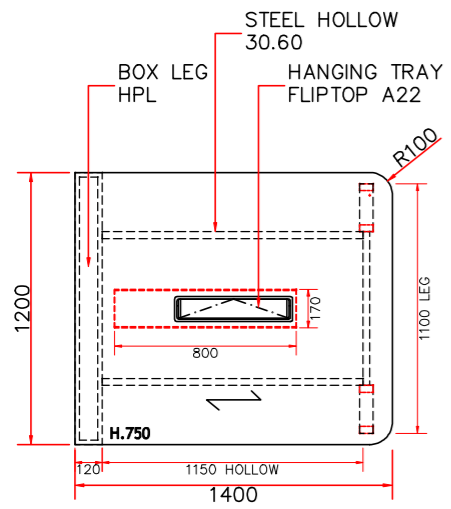

* PB HPL TACO

TB-01



1 UNIT

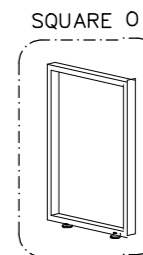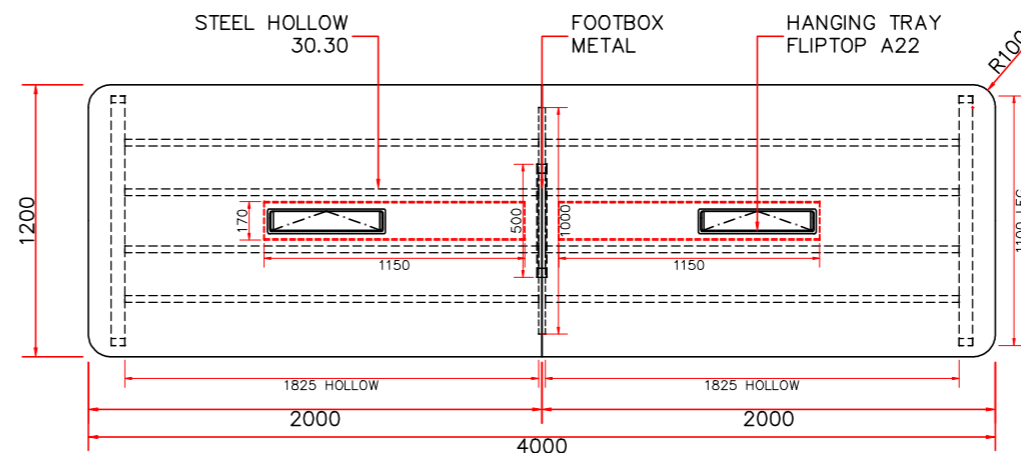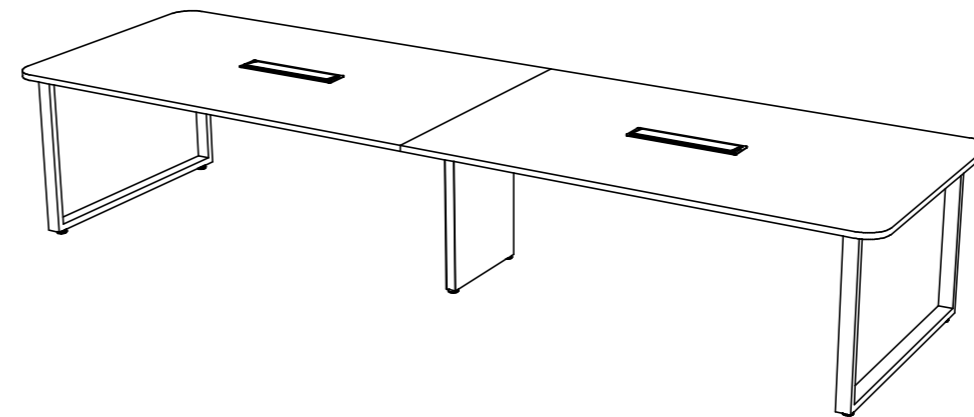

* PB HPL TACO

TP-02

1 UNIT

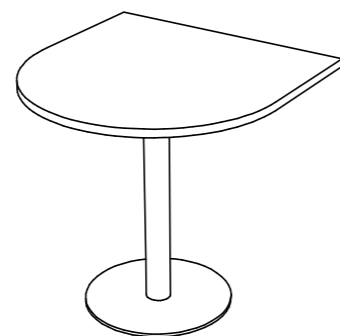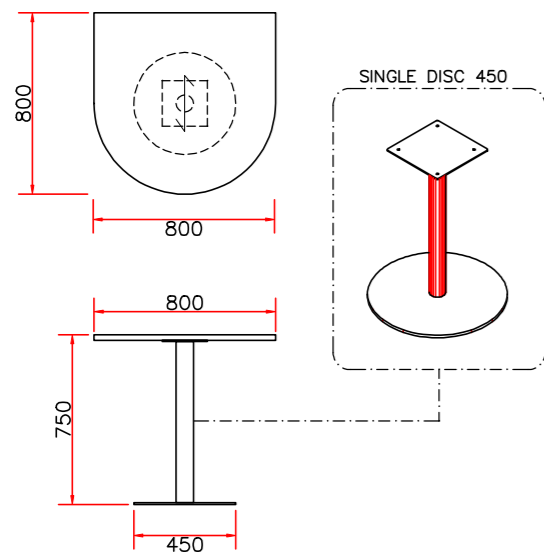

* PB HPL TACO

TP-03

1 UNIT

Bintaro Business Centre Building
Jl. RC Veteran No. 1-1 Bintaro
Phone: +62 21 7357679
Fax: +62 21 7433946
www.dezanstudio.com
admin@dezanstudio.com



CLIENT

UNFPA




PROJECT

UNFPA OFFICE

DRAWING TITLE

DETAIL TB-01, TB-02, TB-03




DRAWING No.	REVISION
INT-519	REV A
SCALE 1:20 @A3	CHECKED AN
DATE 05 Februari, 2020	DRAWN TR

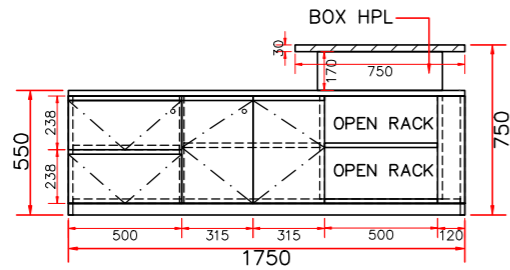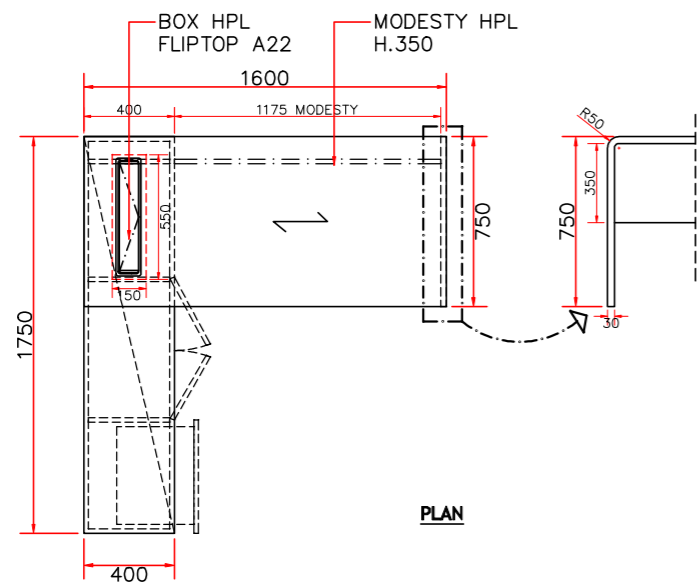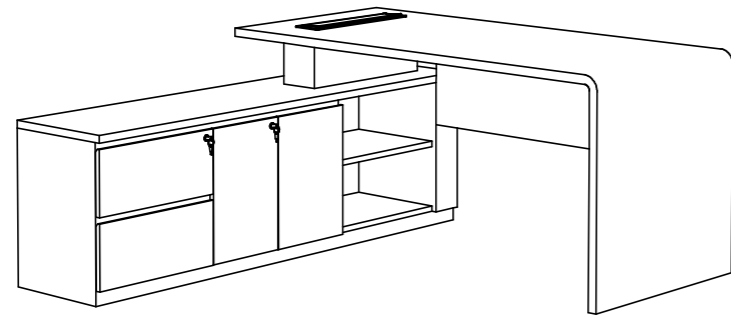

VIEW SIDE CREDENZA

* PLYWOOD HPL TACO

TB-04

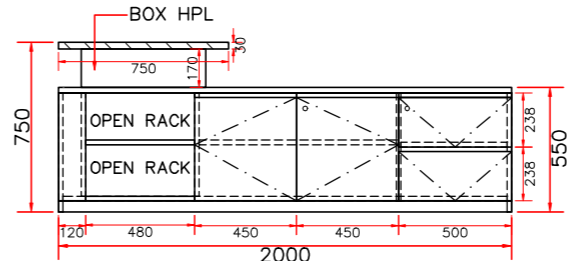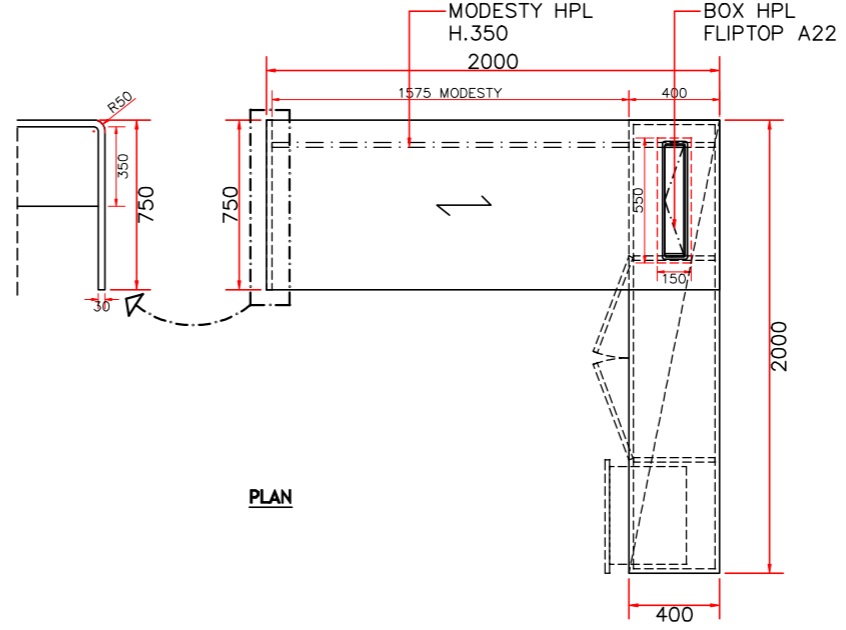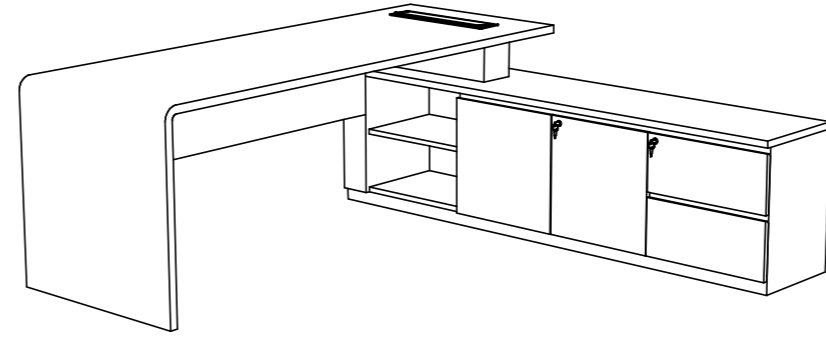

VIEW SIDE CREDENZA

* PLYWOOD HPL TACO

TB 05

NOTE :



KEYPLAN

- △WEX : EXISTING MATERIAL
 - △PT.01 : WALLPAINT WHITE COLOR
ex. DULUX TYPE COTTON FANTASY
 - △PT.02 : WALLPAINT ORANGE COLOR
ex. DULUX, TYPE MARIGOLD BLOSSOM
 - △PT.03 : WALLPAINT LIGHT ORANGE
ex. DULUX, TYPE TOPAZ SPARKLE
 - △HPL.01 : HPL WOOD PATTERN
ex. TACO TH 849 TM ASH AFROMOSIA TIMBER
 - △HPL.02 : HPL WHITE COLOR
ex. TACO CHALK TH 040 AA
 - △HPL.03 : HPL ORANGE COLOR
ex. TACO CLASSIC ORANGE
 - △GL-01 : 12MM CLEAR TEMPERED GLASS
 - △GL-02 : 12MM CLEAR TEMPERED GLASS ORANGE COLOR
 - △GS-01 : 12MM WHITE GLASS STONE
 - △FB-01 : PADED WALL WITH GREY FABRIC FINISH
 - △FB-02 : PADED WALL WITH ORANGE FABRIC FINISH
- ALL WOOD MATERIAL COVER FIRE PROOF & TERMITE TREATMENT

DEZAN STUDIO
 Bintaro Business Centre Building
 Jl. RC Veteran No. 1-1 Bintaro
 Phone: +62 21 7357679
 Fax: +62 21 7433946
 www.dezanstudio.com
 admin@dezanstudio.com

CLIENT

UNFPA

PROJECT

UNFPA OFFICE

DRAWING TITLE

DETAIL TB-04, TB-05


DRAWING No.	REVISION
INT-520	REV A
SCALE 1:20 @A3	CHECKED AN
DATE 05 Februari, 2020	DRAWN TR

NOTE :



KEYPLAN


- : EXISTING MATERIAL
 - : WALLPAPER WHITE COLOR
ex. DULUX TYPE COTTON FANTASY
 - : WALLPAPER ORANGE COLOR
ex. DULUX TYPE MARIGOLD BLOSSOM
 - : WALLPAPER LIGHT ORANGE
ex. DULUX TYPE TOPAZ SPARKLE
 - : HPL WOOD PATTERN
ex. TACO TH 849 TM ASH AFROMOSIA TIMBER
 - : HPL WHITE COLOR
ex. TACO CHALK TH 040 AA
 - : HPL ORANGE COLOR
ex. TACO CLASSIC ORANGE
 - : 12MM CLEAR TEMPERED GLASS
 - : 12MM CLEAR TEMPERED GLASS ORANGE COLOR
 - : 12MM WHITE GLASS STONE
 - : PADED WALL WITH GREY FABRIC FINISH
 - : PADED WALL WITH ORANGE FABRIC FINISH
- ALL WOOD MATERIAL COVER FIRE PROOF & TERMITE TREATMENT

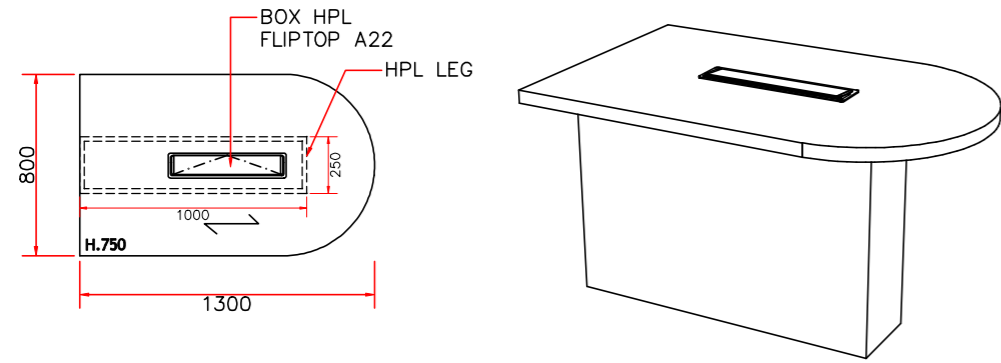

* TOP TABLE 40mm
* PB HPL TACO

TB-06


1 UNIT

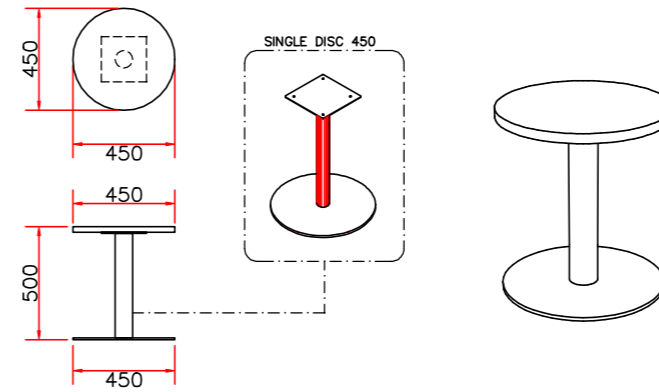

* PB HPL TACO

TB.09


3 UNIT

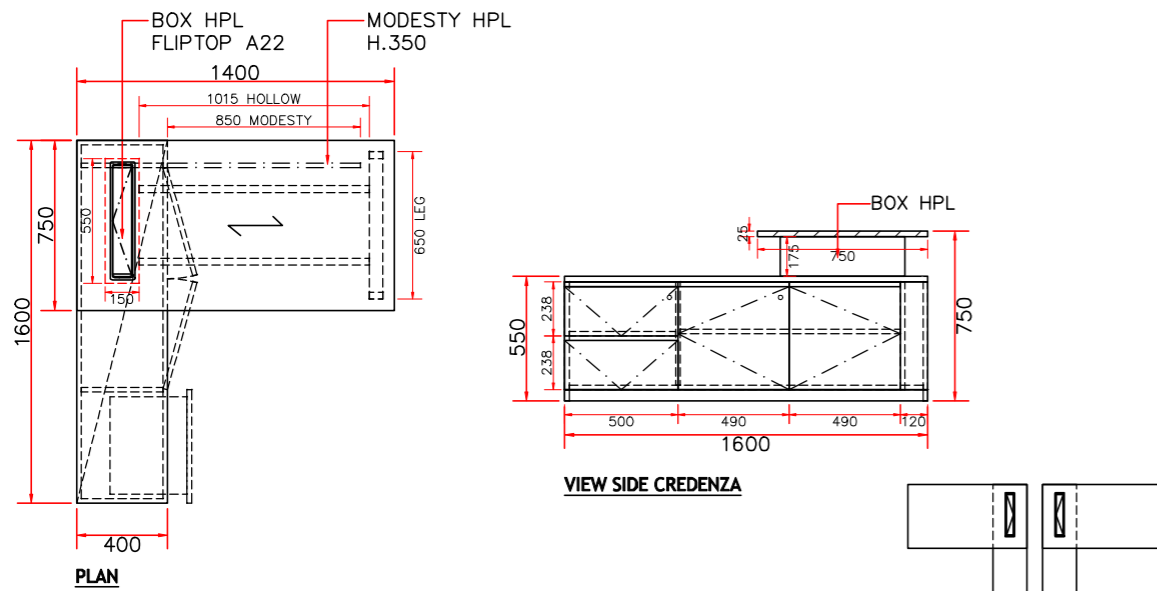

* PB HPL TACO

TP 07

9 UNIT

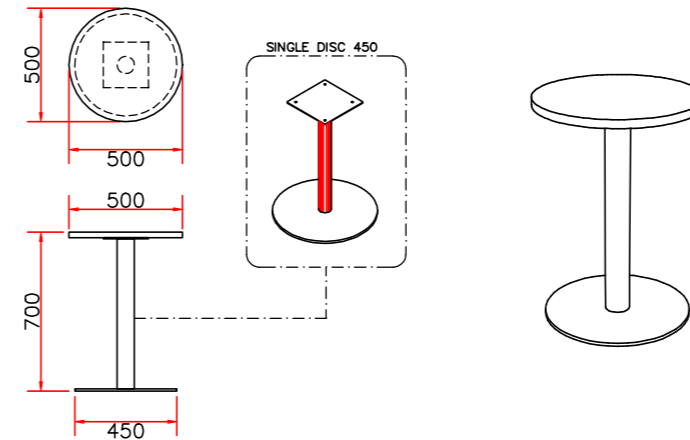

* PB HPL TACO

TP 10

1 UNIT

Bintaro Business Centre Building
Jl. RC Veteran No. 1-1 Bintaro
Phone: +62 21 7357679
Fax: +62 21 7433946
www.dezanstudio.com
admin@dezanstudio.com

CLIENT

UNFPA

PROJECT

UNFPA OFFICE

DRAWING TITLE

DETAIL TB-06, TB-07, TB-09, TB-10

DRAWING No.

INT-521

SCALE 1:20 @A3

DATE 05 Februari, 2020

REVISION

REV A

CHECKED AN




DRAWN TR

NOTE :




KEYPLAN


-  : EXISTING MATERIAL
 -  : WALLPAINT WHITE COLOR
ex. DULUX TYPE COTTON FANTASY
 -  : WALLPAINT ORANGE COLOR
ex. DULUX, TYPE MARIGOLD BLOSSOM
 -  : WALLPAINT LIGHT ORANGE
ex. DULUX, TYPE TOPAZ SPARKLE
 -  : HPL WOOD PATTERN
ex. TACO TH 849 TM ASH AFROMOSIA TIMBER
 -  : HPL WHITE COLOR
ex. TACO CHALK TH 040 AA
 -  : HPL ORANGE COLOR
ex. TACO CLASSIC ORANGE
 -  : 12MM CLEAR TEMPERED GLASS
 -  : 12MM CLEAR TEMPERED GLASS ORANGE COLOR
 -  : 12MM WHITE GLASS STONE
 -  : PADED WALL WITH GREY FABRIC FINISH
 -  : PADED WALL WITH ORANGE FABRIC FINISH
- ALL WOOD MATERIAL COVER FIRE PROOF & TERMITE TREATMENT

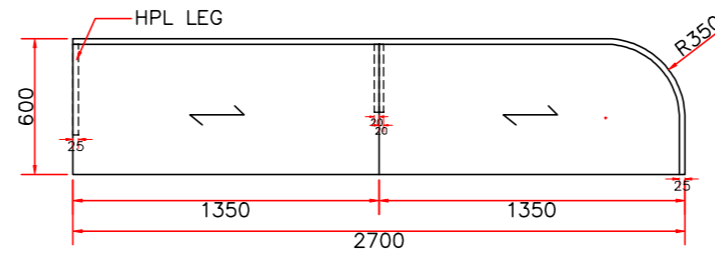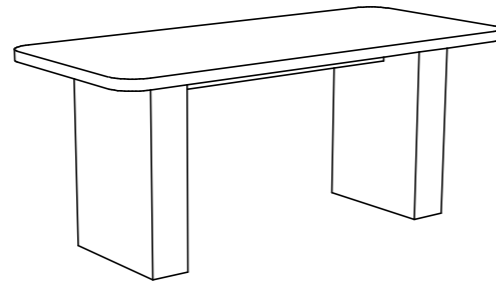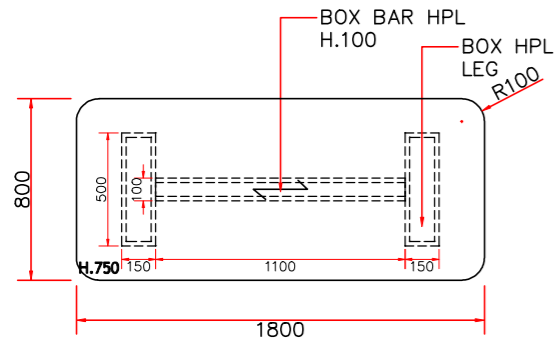

PLAN

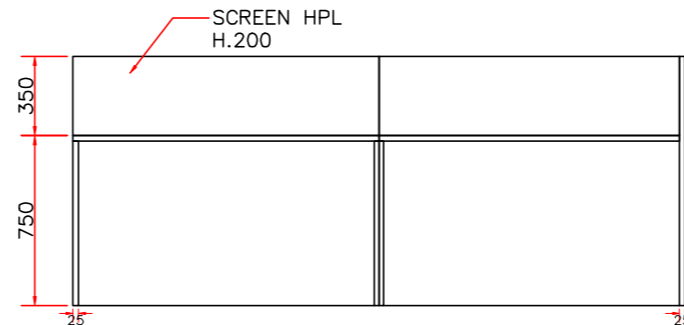

FRONT VIEW

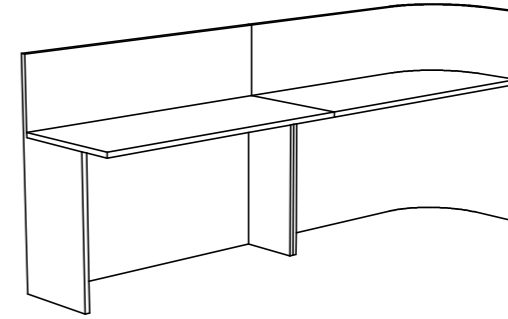

* TOP TABLE 40mm
* PLYWOOD HPL TACO





* PLYWOOD HPL TACO

TB-11

1 UNIT

TB-12

2 UNIT

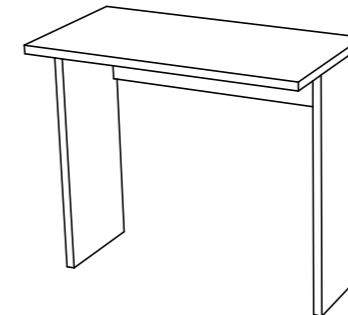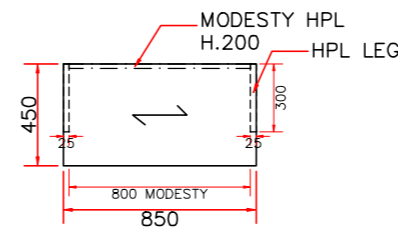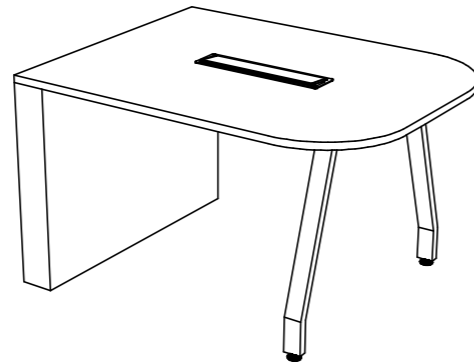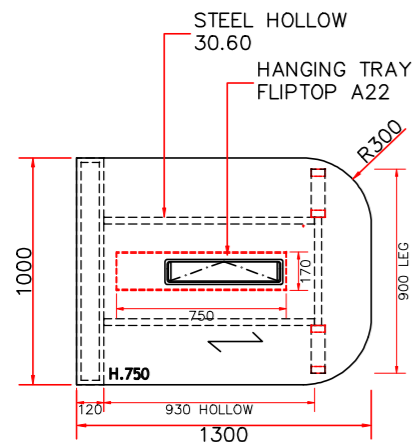

* PB HPL TACO

* PB HPL TACO

TB.15

1 UNIT

TB-13

2 UNIT

 Bintaro Business Centre Building
Jl. RC Veteran No. 1-1 Bintaro
Phone: +62 21 7357679
Fax: +62 21 7433946
www.dezanstudio.com
admin@dezanstudio.com

CLIENT

UNFPA

PROJECT

UNFPA OFFICE

DRAWING TITLE


DETAIL TB-11, TB-12, TB-13, TB-15

DRAWING No. REVISION

INT-522 REV A

SCALE 1:20 @A3 CHECKED AN


DATE 05 Februari, 2020 DRAWN TR

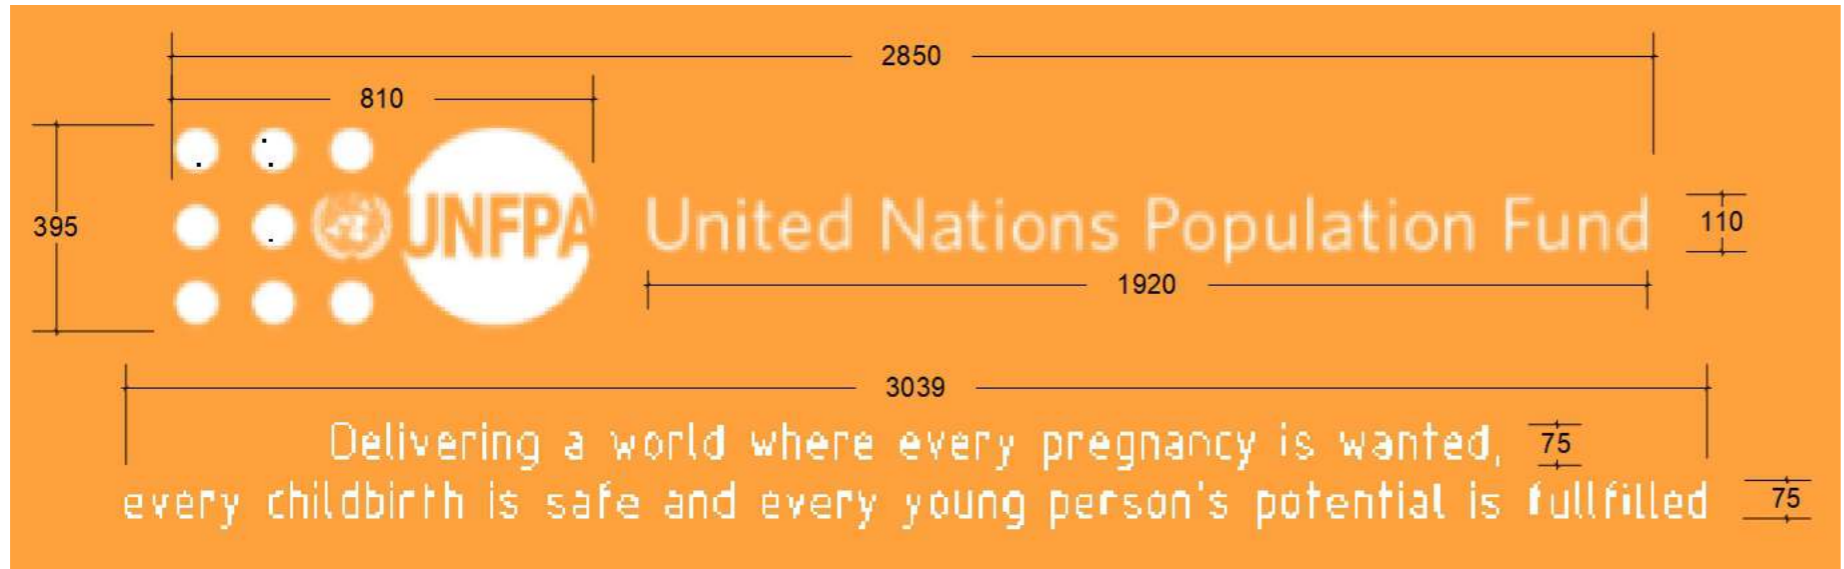


01
INT-600
DETAIL LOGO & QUOTE
(WALL FINISH WORK D6)



02
INT-600
DETAIL LETTERING QUOTE
(WALL FINISH WORK D7)

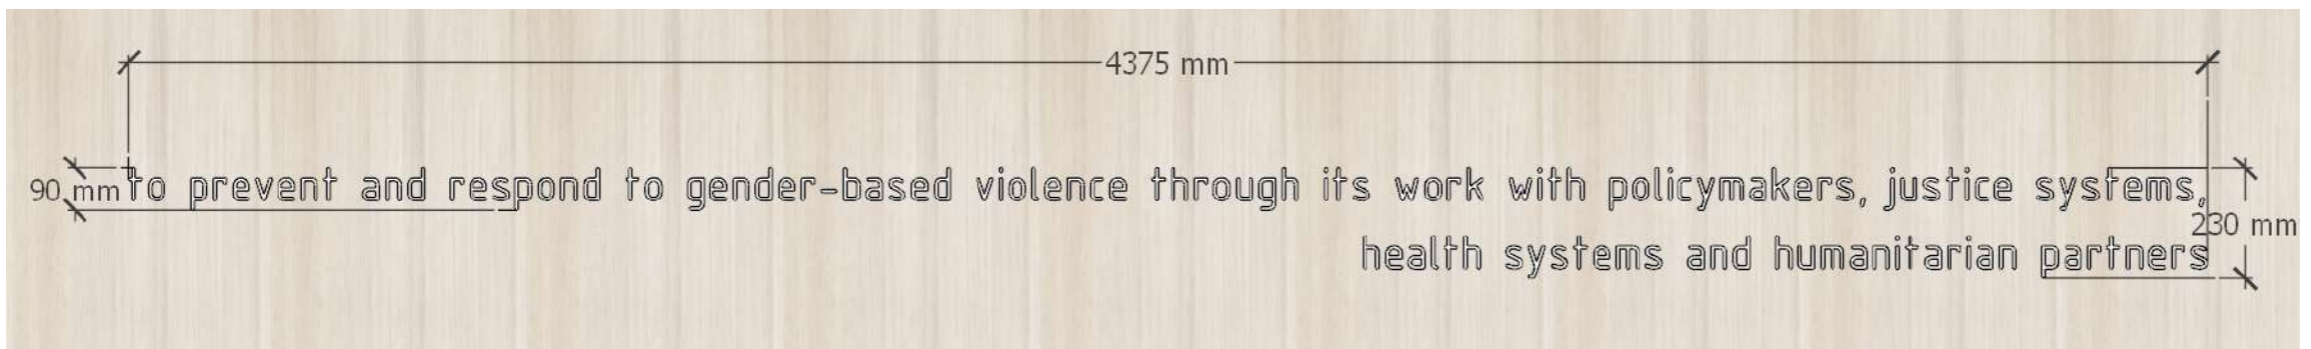

03
INT-600
DETAIL LETTERING QUOTE
(WALL FINISH WORK D9)

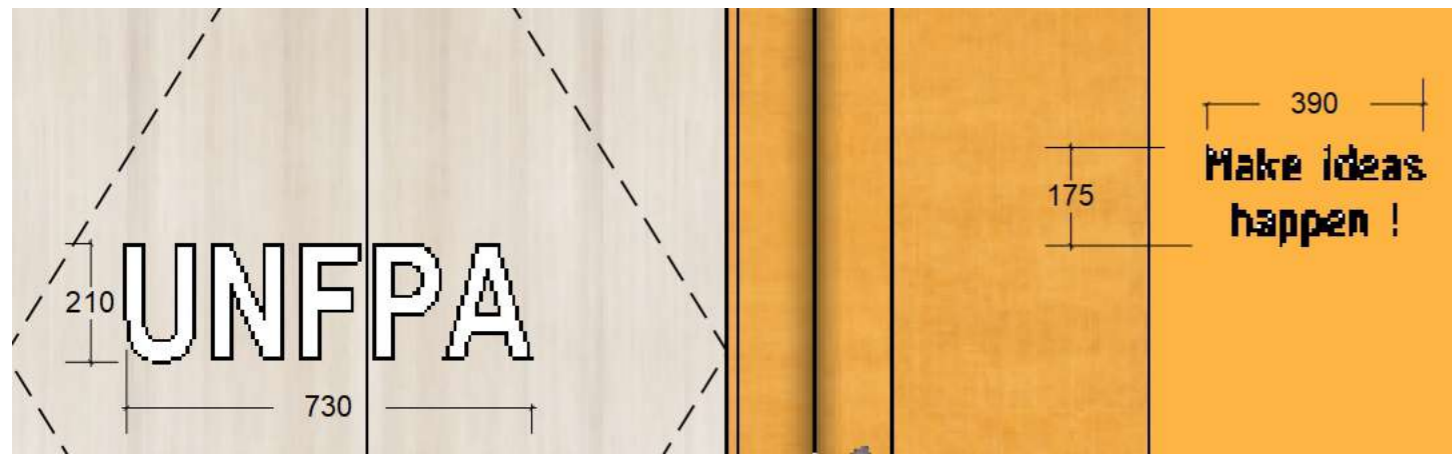

04
INT-600
DETAIL LETTERING QUOTE
(WALL FINISH WORK D8)



- NOTE :
- EX-01 : EXISTING MATERIAL
 - FP-01 : WALLPAINT WHITE COLOR
ex. DULUX TYPE COTTON FANTASY
 - FP-02 : WALLPAINT ORANGE COLOR
ex. DULUX TYPE MARIGOLD BLOSSOM
 - FP-03 : WALLPAINT LIGHT ORANGE
ex. DULUX TYPE TOPAZ SPARKLE
 - FP-04 : WALLPAINT CREAM COLOR
ex. DULUX TYPE TAMMY BIRCH
 - FP-05 : WALLPAINT CHAMPAGNE ORANGE
ex. DULUX TYPE SABLE SANDS
 - HT-01 : HPL WOOD PATTERN
ex. TACO TH B49 TM ASH AFROMOSIA TIMBER
 - HT-02 : HPL WHITE COLOR
ex. TACO CHALK TH 040 AA
 - HT-03 : HPL ORANGE COLOR
ex. TACO CLASSIC ORANGE
 - GL-01 : 12MM CLEAR TEMPERED GLASS
 - GL-02 : 12MM CLEAR TEMPERED GLASS ORANGE COLOR
 - GL-03 : 12MM WHITE GLASS STONE
 - GL-04 : 12MM ORANGE GLASS STONE
 - GL-05 : 12MM CLEAR TEMPERED GLASS WITH ORANGE GRADIENT TRANSPARENT STICKER
 - FB-01 : PADED WALL WITH GREY FABRIC FINISH
 - FB-02 : PADED WALL WITH ORANGE FABRIC FINISH
 - VT-01 : ORANGE VINYL EX. POLYFLOOR CAYENNE HEAT 8633
 - PF-01 : PERFORATED METAL ORANGE COLOR
- ALL WOOD MATERIAL, COVER FIRE PROOF & TERMITE TREATMENT

DEZAN STUDIO
 Bintaro Business Centre Building
 Jl. RC Veteran No. 1-1 Bintaro
 Phone: +62 21 7357679
 Fax: +62 21 7433946
 www.dezanstudio.com
 admin@dezanstudio.com


CLIENT			
UNFPA			
PROJECT			
UNFPA OFFICE			
DRAWING TITLE			
DETAIL LOGO SIZE			
DRAWING No.	REVISION		
INT-601	REV B		
SCALE	1:25 @A3	CHECKED	AN
DATE	16 May, 2023	DRAWN	TR




- NOTE :
- : EXISTING MATERIAL
 - : WALLPAINT WHITE COLOR
ex. DULUX TYPE COTTON FANTASY
 - : WALLPAINT ORANGE COLOR
ex. DULUX TYPE MARIGOLD BLOSSOM
 - : WALLPAINT LIGHT ORANGE
ex. DULUX TYPE TOPAZ SPARKLE
 - : WALLPAINT CREAM COLOR
ex. DULUX TYPE TAMNY BIRCH
 - : WALLPAINT CHAMPAGNE ORANGE
ex. DULUX TYPE SABLE SANDS
 - : HPL WOOD PATTERN
ex. TACO TH B49 TM ASH AFROMOSIA TIMBER
 - : HPL WHITE COLOR
ex. TACO CHALK TH 040 AA
 - : HPL ORANGE COLOR
ex. TACO CLASSIC ORANGE
 - : 12MM CLEAR TEMPERED GLASS
 - : 12MM CLEAR TEMPERED GLASS ORANGE COLOR
 - : 12MM WHITE GLASS STONE
 - : 12MM ORANGE GLASS STONE
 - : 12MM CLEAR TEMPERED GLASS WITH ORANGE GRADIENT TRANSPARENT STICKER
 - : PADED WALL WITH GREY FABRIC FINISH
 - : PADED WALL WITH ORANGE FABRIC FINISH
 - : ORANGE VINYL EX. POLYFLOOR CAYENNE HEAT 8633
 - : PERFORATED METAL ORANGE COLOR
- ALL WOOD MATERIAL, COVER FIRE PROOF & TERMITE TREATMENT

Bintaro Business Centre Building
 Jl. RC Veteran No. 1-1 Bintaro
 Phone: +62 21 7357679
 Fax: +62 21 7433946
 www.dezanstudio.com
 admin@dezanstudio.com


CLIENT			
UNFPA			
PROJECT			
UNFPA OFFICE			
DRAWING TITLE			
DETAIL LOGO SIZE			
DRAWING No.	REVISION		
INT-602	REV B		
SCALE	1:25 @A3	CHECKED	AN
DATE	16 May, 2023	DRAWN	TR

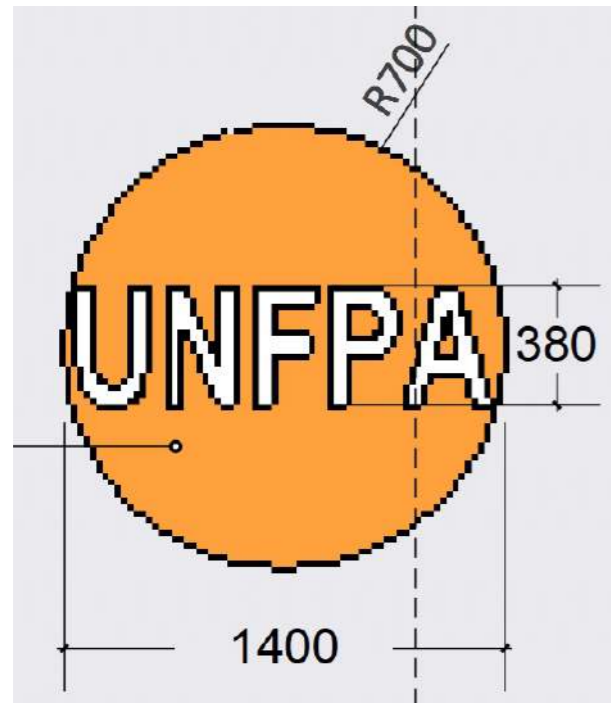

01
INT-600
DETAIL LETTERING LOGO
(WALL FINISH WORK D10)

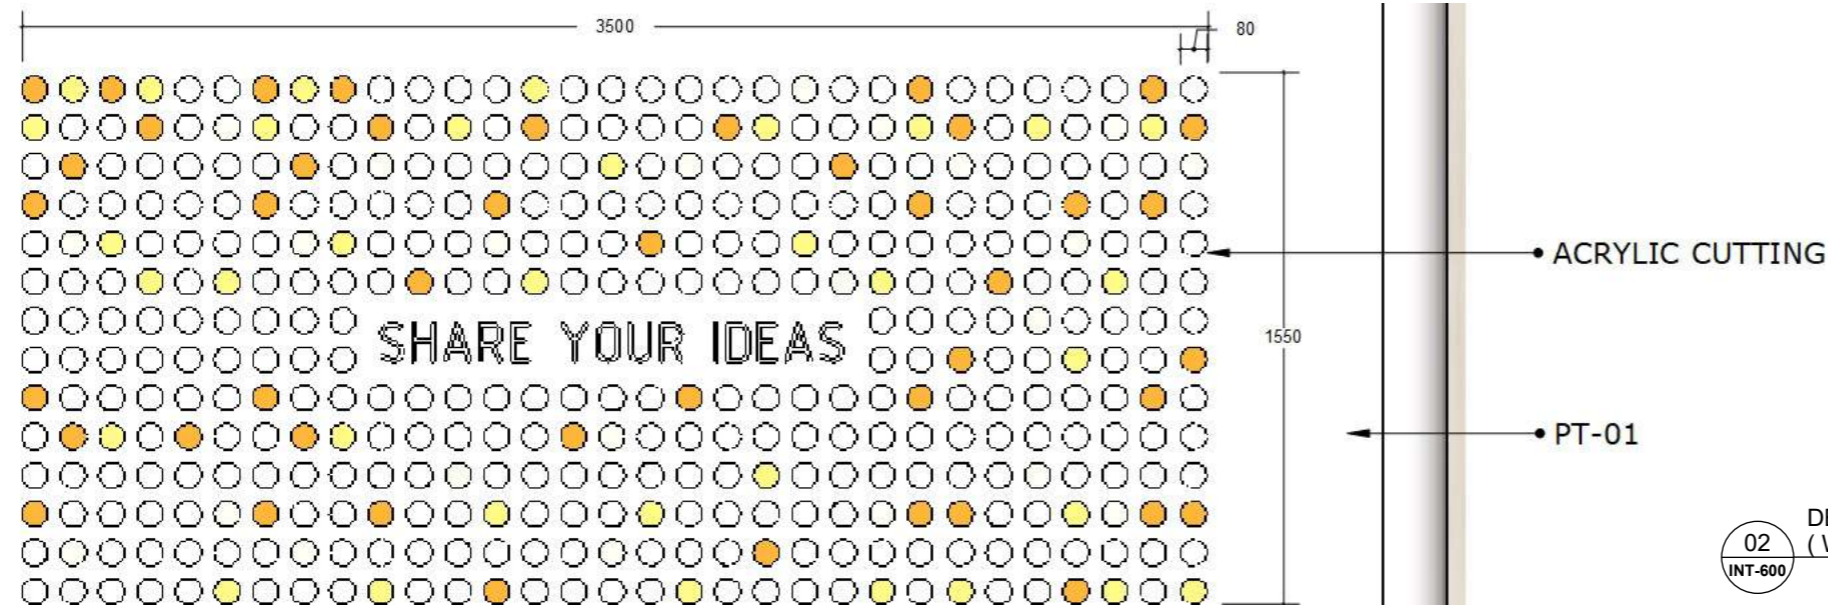

02
INT-600
DETAIL WALL DECORATION
(WALL FINISH WORK D11)

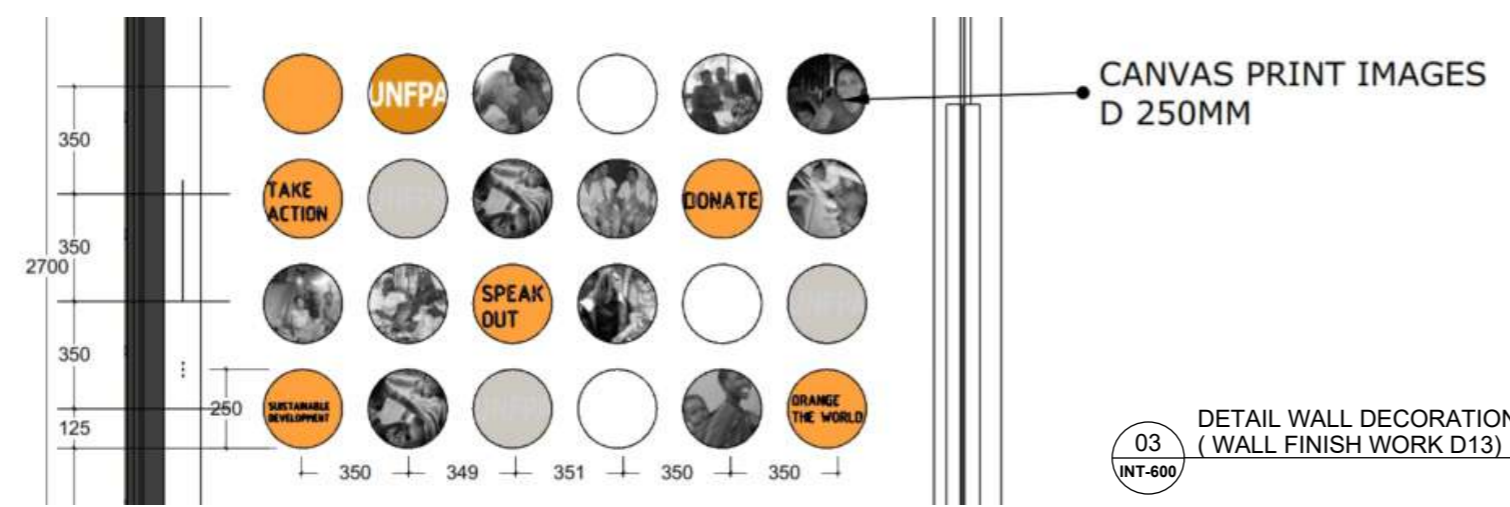

03
INT-600
DETAIL WALL DECORATION
(WALL FINISH WORK D13)